


ROHLWING ROAD

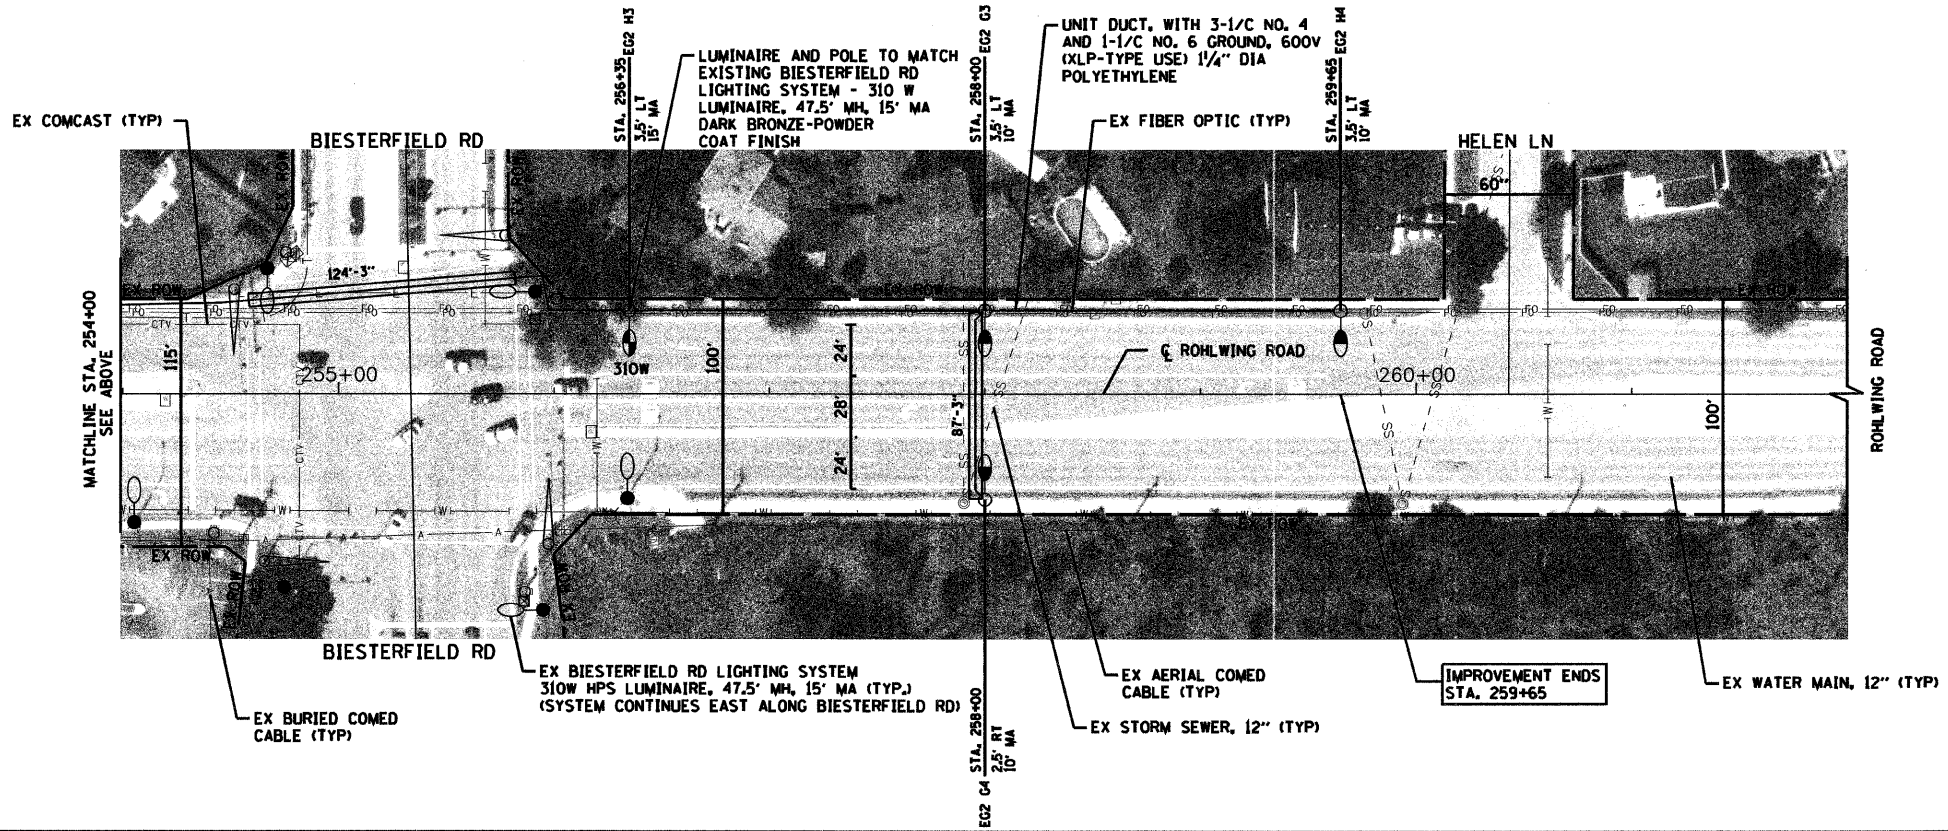

ROHLWING ROAD

- NOTES**
1. SEE SHEET NO. 2 FOR LEGEND.
  2. ALL POLES ARE SET BACK 4' BEHIND THE BACK OF CURB UNLESS OTHERWISE NOTED.

FILE NAME = g:\ch09\0132\road\Plan Roehling 3.dgn	USER NAME = ajpondexter	DESIGNED - KB	REVISED -	<b>STATE OF ILLINOIS DEPARTMENT OF TRANSPORTATION</b>	<b>LIGHTING PLAN ROHLWING ROAD</b>	F.A.U. RTE.	SECTION	COUNTY	TOTAL SHEETS	SHEET NO.	
PL01 SCALE = #SCALE#	CHECKED - SRF	REVISIED -	REVISIED -			2578	10-00059-00-LT	COOK	21	9	
PL01 DATE = 12/22/2011	DATE - 11/04/2011	REVISIED -	REVISIED -			2585	JOB NO. C-91-460-10	CONTRACT NO. 63530			
						SCALE: 1" = 40'	SHEET NO. 9 OF 21 SHEETS	STA. 244+00	TO STA. 262+00	FED. ROAD DIST. NO. ILLINOIS FED. AID PROJECT	