


NERGE ROAD

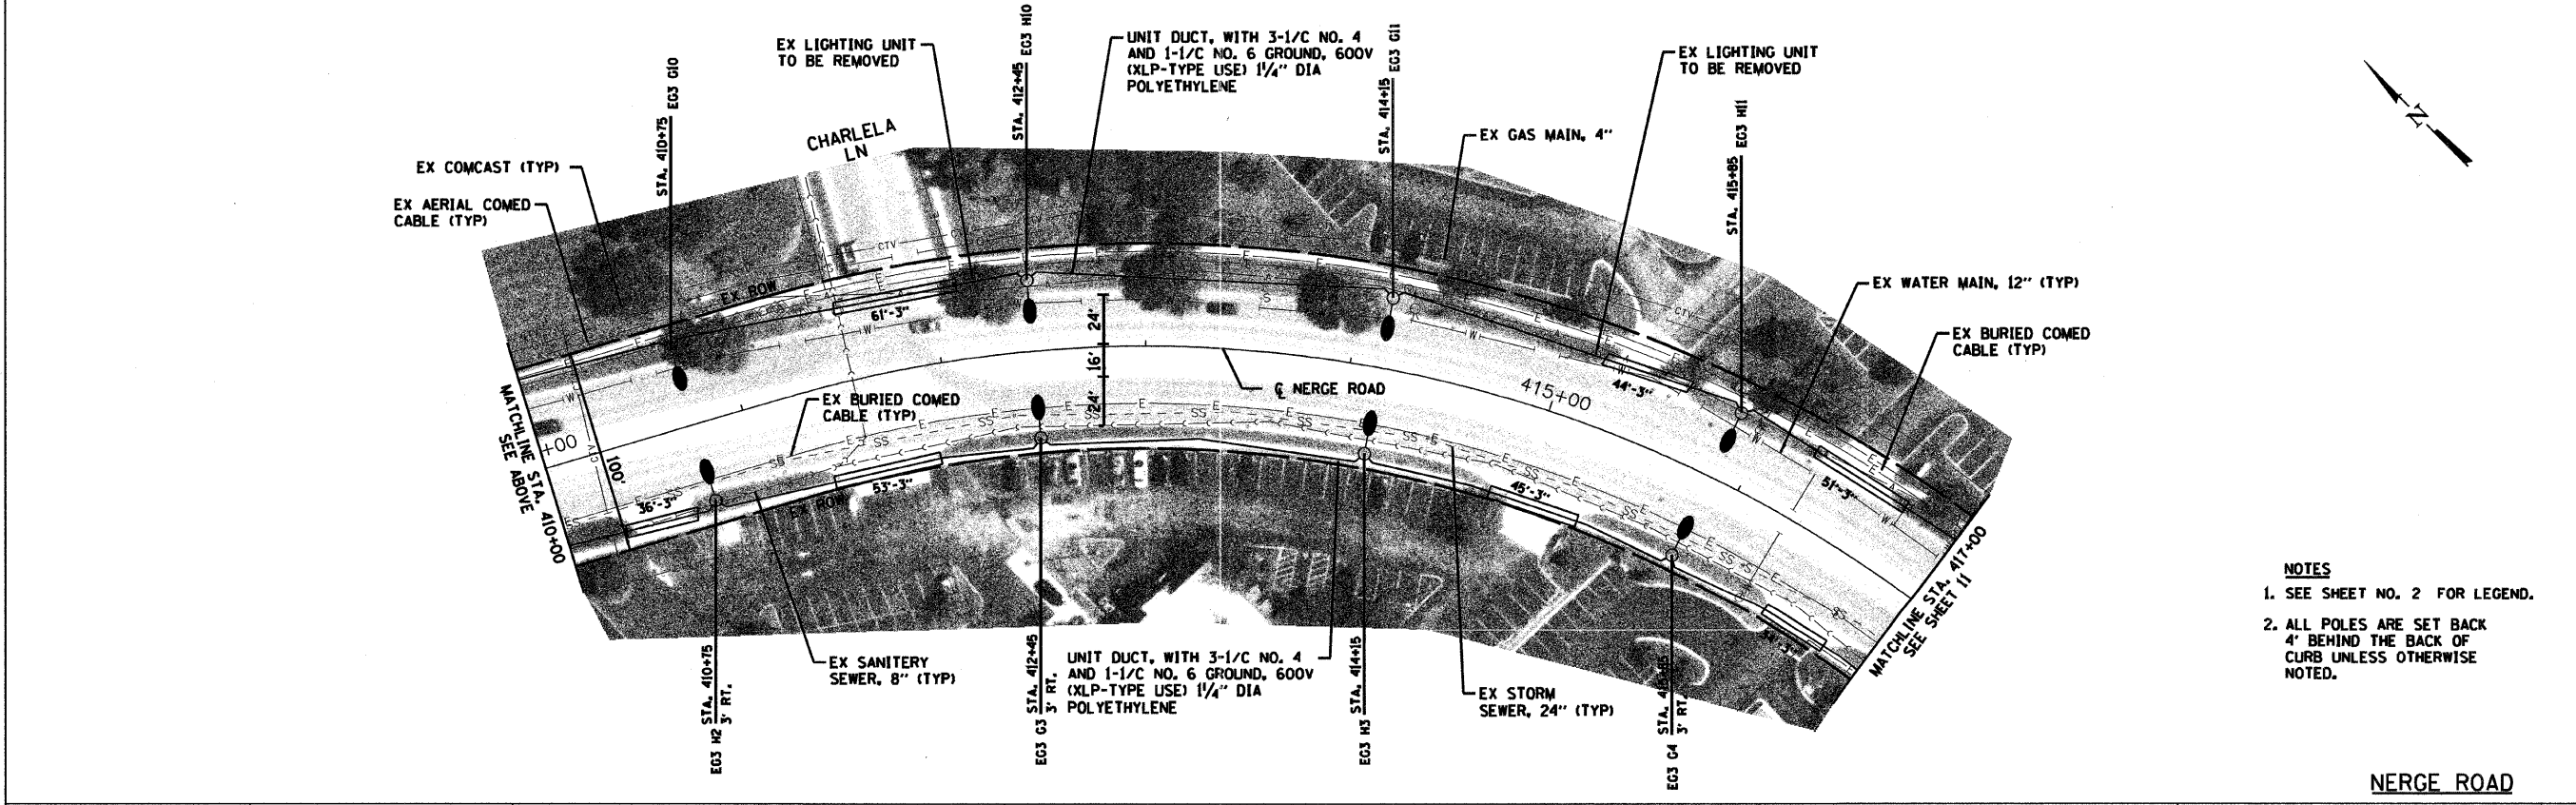

NERGE ROAD

- NOTES**
1. SEE SHEET NO. 2 FOR LEGEND.
  2. ALL POLES ARE SET BACK 4' BEHIND THE BACK OF CURB UNLESS OTHERWISE NOTED.

FILE NAME = g:\ch09\132\road\Plan Nerge I.dgn	USER NAME = ejpindexter	DESIGNED - KB	REVISED -	<b>STATE OF ILLINOIS DEPARTMENT OF TRANSPORTATION</b>	<b>LIGHTING PLAN NERGE ROAD</b>	F.A.U. RTE.	SECTION	COUNTY	TOTAL SHEETS	SHEET NO.
		DRAWN - AJP	REVISED -			2578	10-00059-00-LT	COOK	21	10
		CHECKED - SRF	REVISED -			2585	JOB NO. C-91-460-10	CONTRACT NO. 63530		
		DATE - 11/04/2011	REVISED -			SCALE: 1" = 40'		SHEET NO. 10 OF 21 SHEETS		STA. 400+00 TO STA. 417+00