


DEVON AVENUE

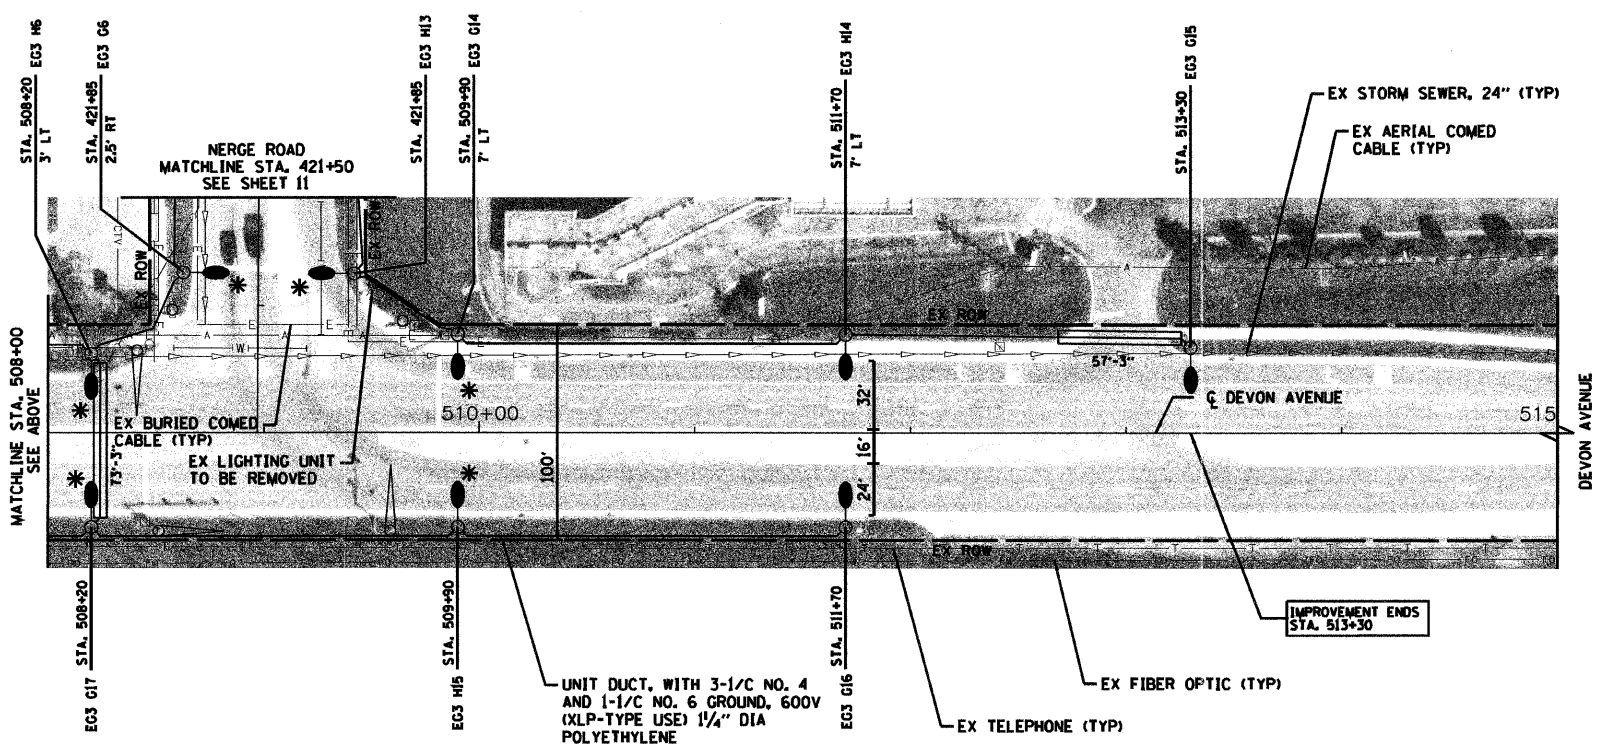

DEVON AVENUE

* LUMINAIRE WILL NOT INCLUDE HOUSESIDE SHIELD

- NOTES**
1. SEE SHEET NO. 2 FOR LEGEND.
 2. ALL POLES ARE SET BACK 4' BEHIND THE BACK OF CURB UNLESS OTHERWISE NOTED.

FILE NAME = g:\CH09\10132\Road\Plan Devon 1.dgn	USER NAME = ajpondexter	DESIGNED - KB	REVISED -	STATE OF ILLINOIS DEPARTMENT OF TRANSPORTATION	LIGHTING PLAN DEVON AVENUE	F.A.U. RITE:	SECTION	COUNTY	TOTAL SHEETS	SHEET NO.		
	PLOT SCALE = #SCALE#	CHECKED - SRF	REVISED -			SCALE: 1" = 40'	SHEET NO. 12 OF 21 SHEETS	2578	10-00059-00-LT	COOK	21	12
	PLOT DATE = 12/22/2011	DATE - 11/04/2011	REVISED -			STA. 500+00	TO STA. 515+00	2585	JOB NO. C-91-460-10	CONTRACT NO. 63530		
								FED. ROAD DIST. NO. ILLINOIS FED. AID PROJECT				