



WEST SIDE PROFILE

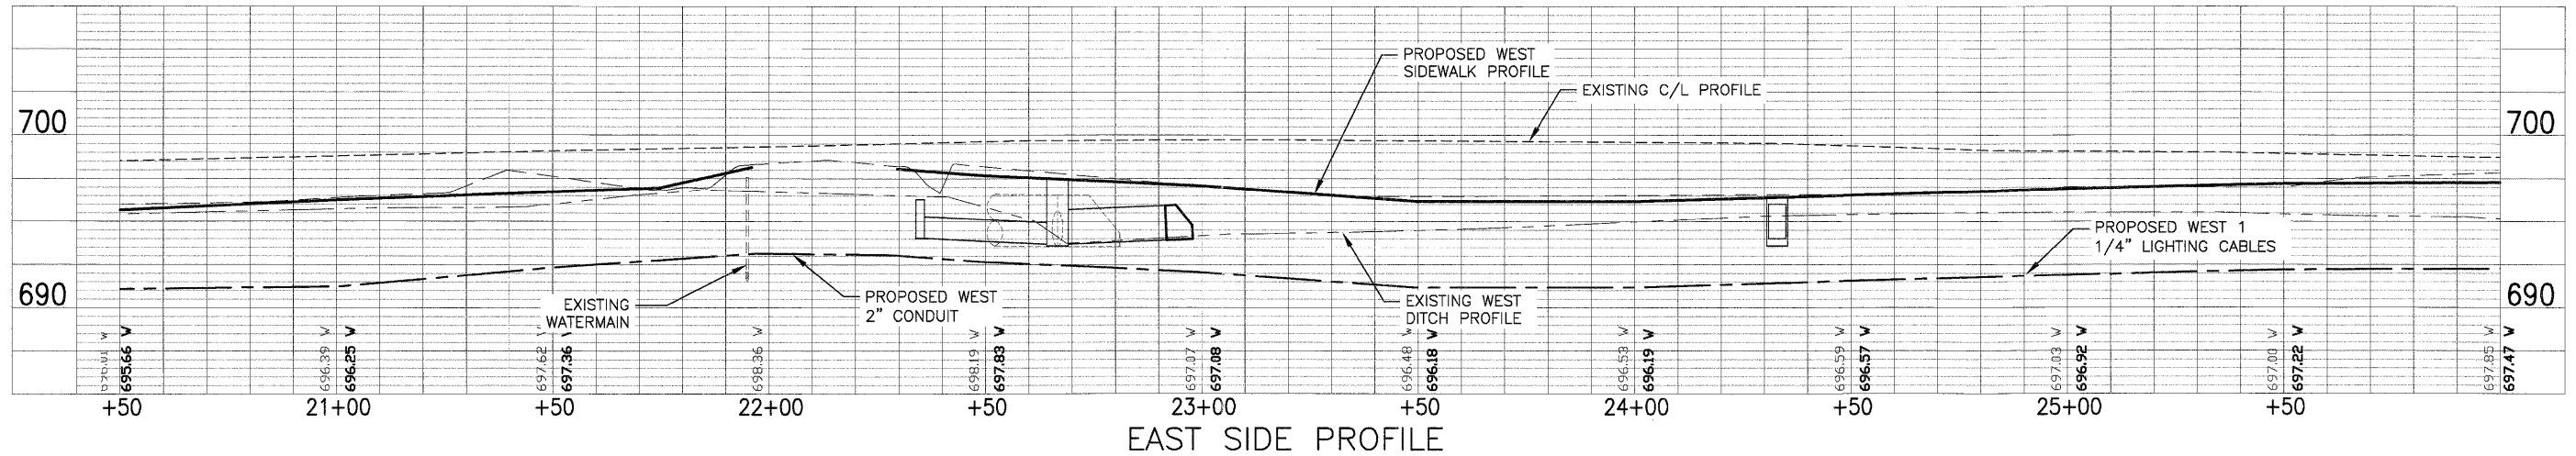

EAST SIDE PROFILE

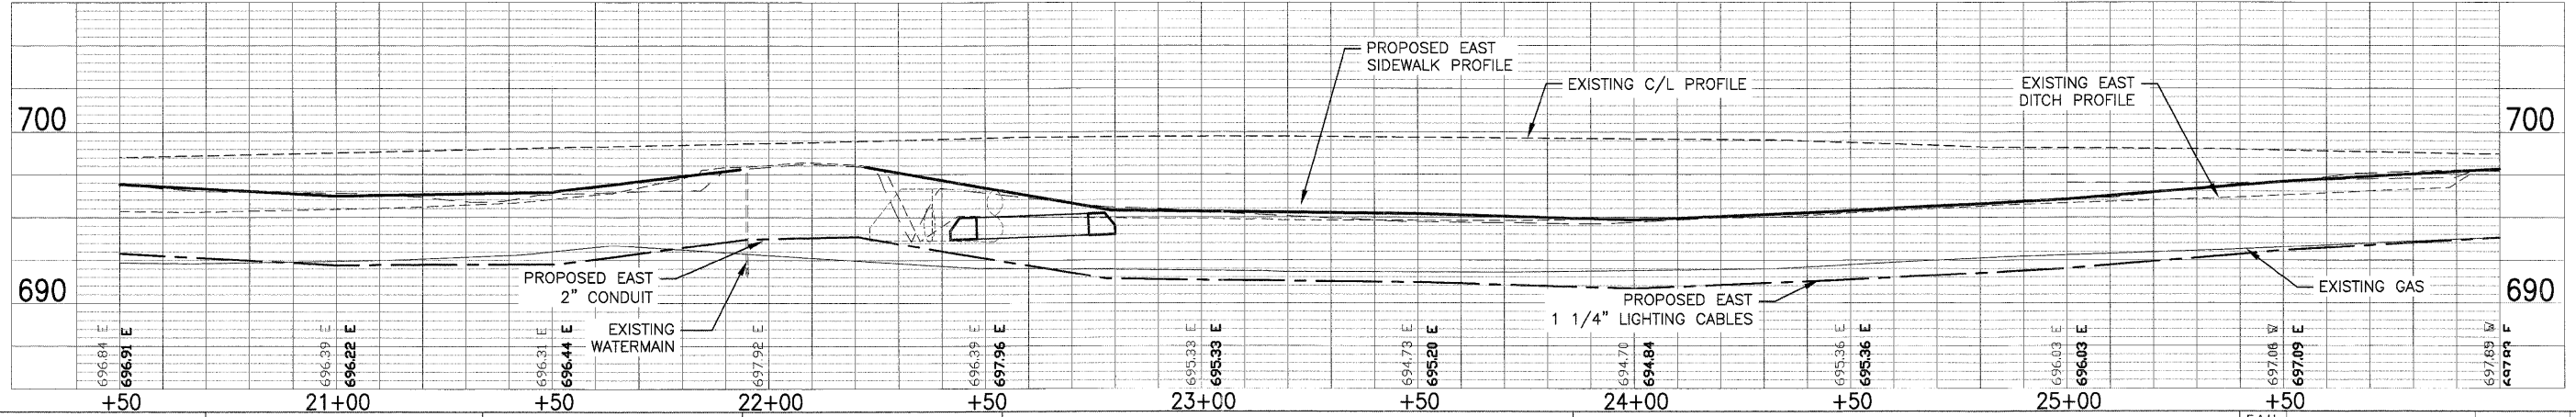

FILE NAME = P:\P01001\00\SURVEY\2010\FED\GREENLEAF.DWG	USER NAME =	DESIGNED - EKS	REVISED -	STATE OF ILLINOIS DEPARTMENT OF TRANSPORTATION	GREENLEAF AVENUE SIDEWALKS LIGHTING PLAN	F.A.U. RTE. = 2701	SECTION = 10-00042-00-SW	COUNTY = LAKE	TOTAL SHEETS = 34	SHEET NO. = 20	
	PLOT SCALE = AS SHOWN	DRAWN - SRU	REVISED -			SHEET NO. 20 OF 34 SHEETS	STA. 20+50 TO STA. 26+00	CONTRACT NO. 63605		ILLINOIS FED. AID PROJECT	
	PLOT DATE =	CHECKED - MKK	REVISED -								
		DATE - 12/29/2011	REVISED -								