



WEST SIDE PROFILE

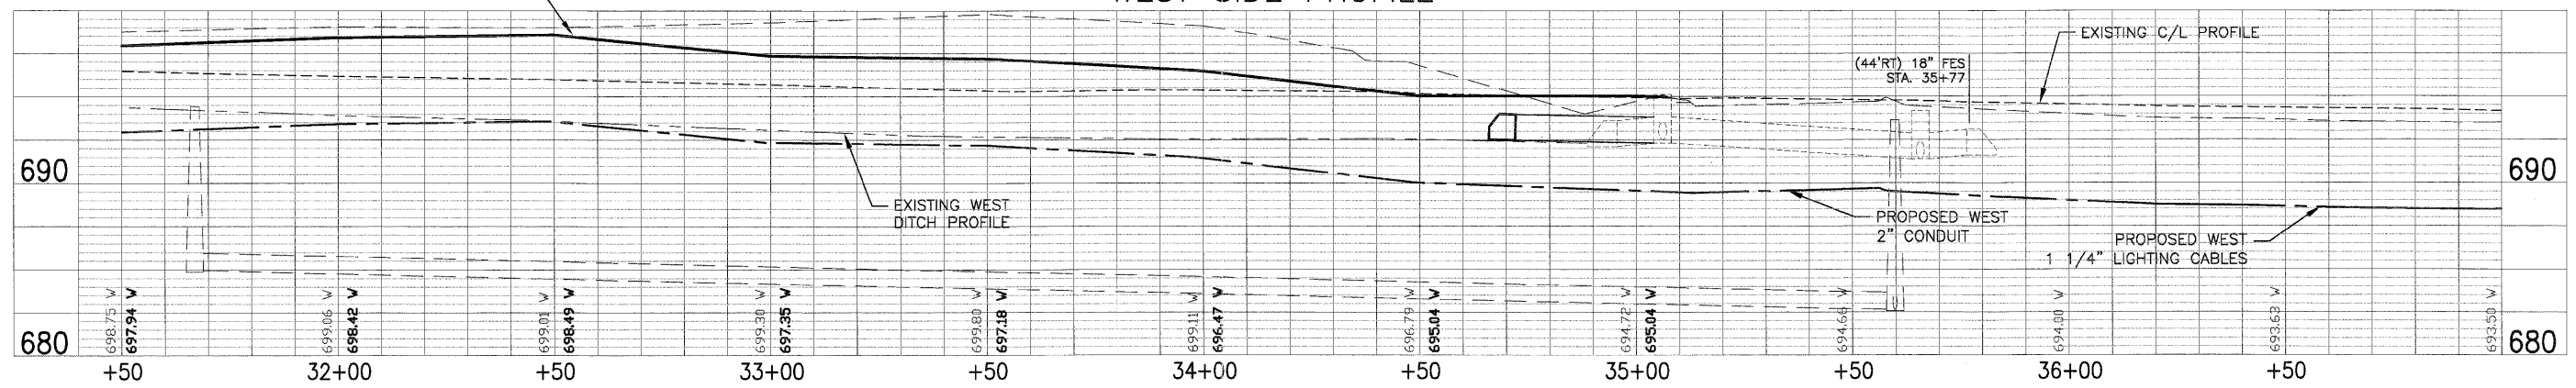

EAST SIDE PROFILE

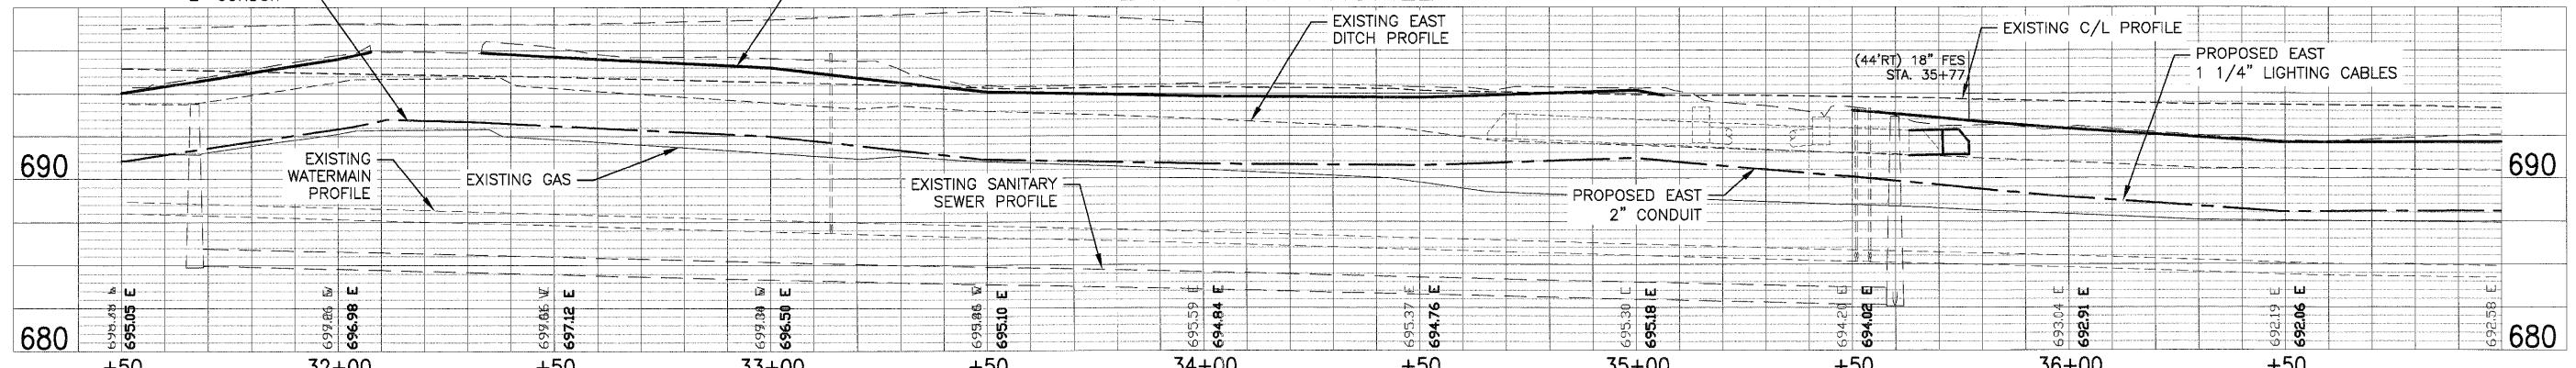

FILE NAME = F:\P0100150\SURVEY\2010 FED\GREENLEAF.DWG	USER NAME =	DESIGNED - EKS	REVISED -	STATE OF ILLINOIS DEPARTMENT OF TRANSPORTATION	GREENLEAF AVENUE SIDEWALKS LIGHTING PLAN	F.A.U. RTE. 2701	SECTION 10-00042-00-SW	COUNTY LAKE	TOTAL SHEETS 34	SHEET NO. 22	
PLOT SCALE = AS SHOWN	CHECKED - MKK	REVISOR -	REVISOR -			SHEET NO. 22 OF 34 SHEETS		STA. 31+50 TO STA. 37+00		CONTRACT NO. 63605	
PLOT DATE =	DATE - 12/29/2011	REVISOR -	REVISOR -			ILLINOIS		FED. AID PROJECT			