



United Way Of Lake County, Inc  
330 S. Greenleaf Ct  
0725122002


G.P. Management  
310 S. Greenleaf Ct  
0725122001

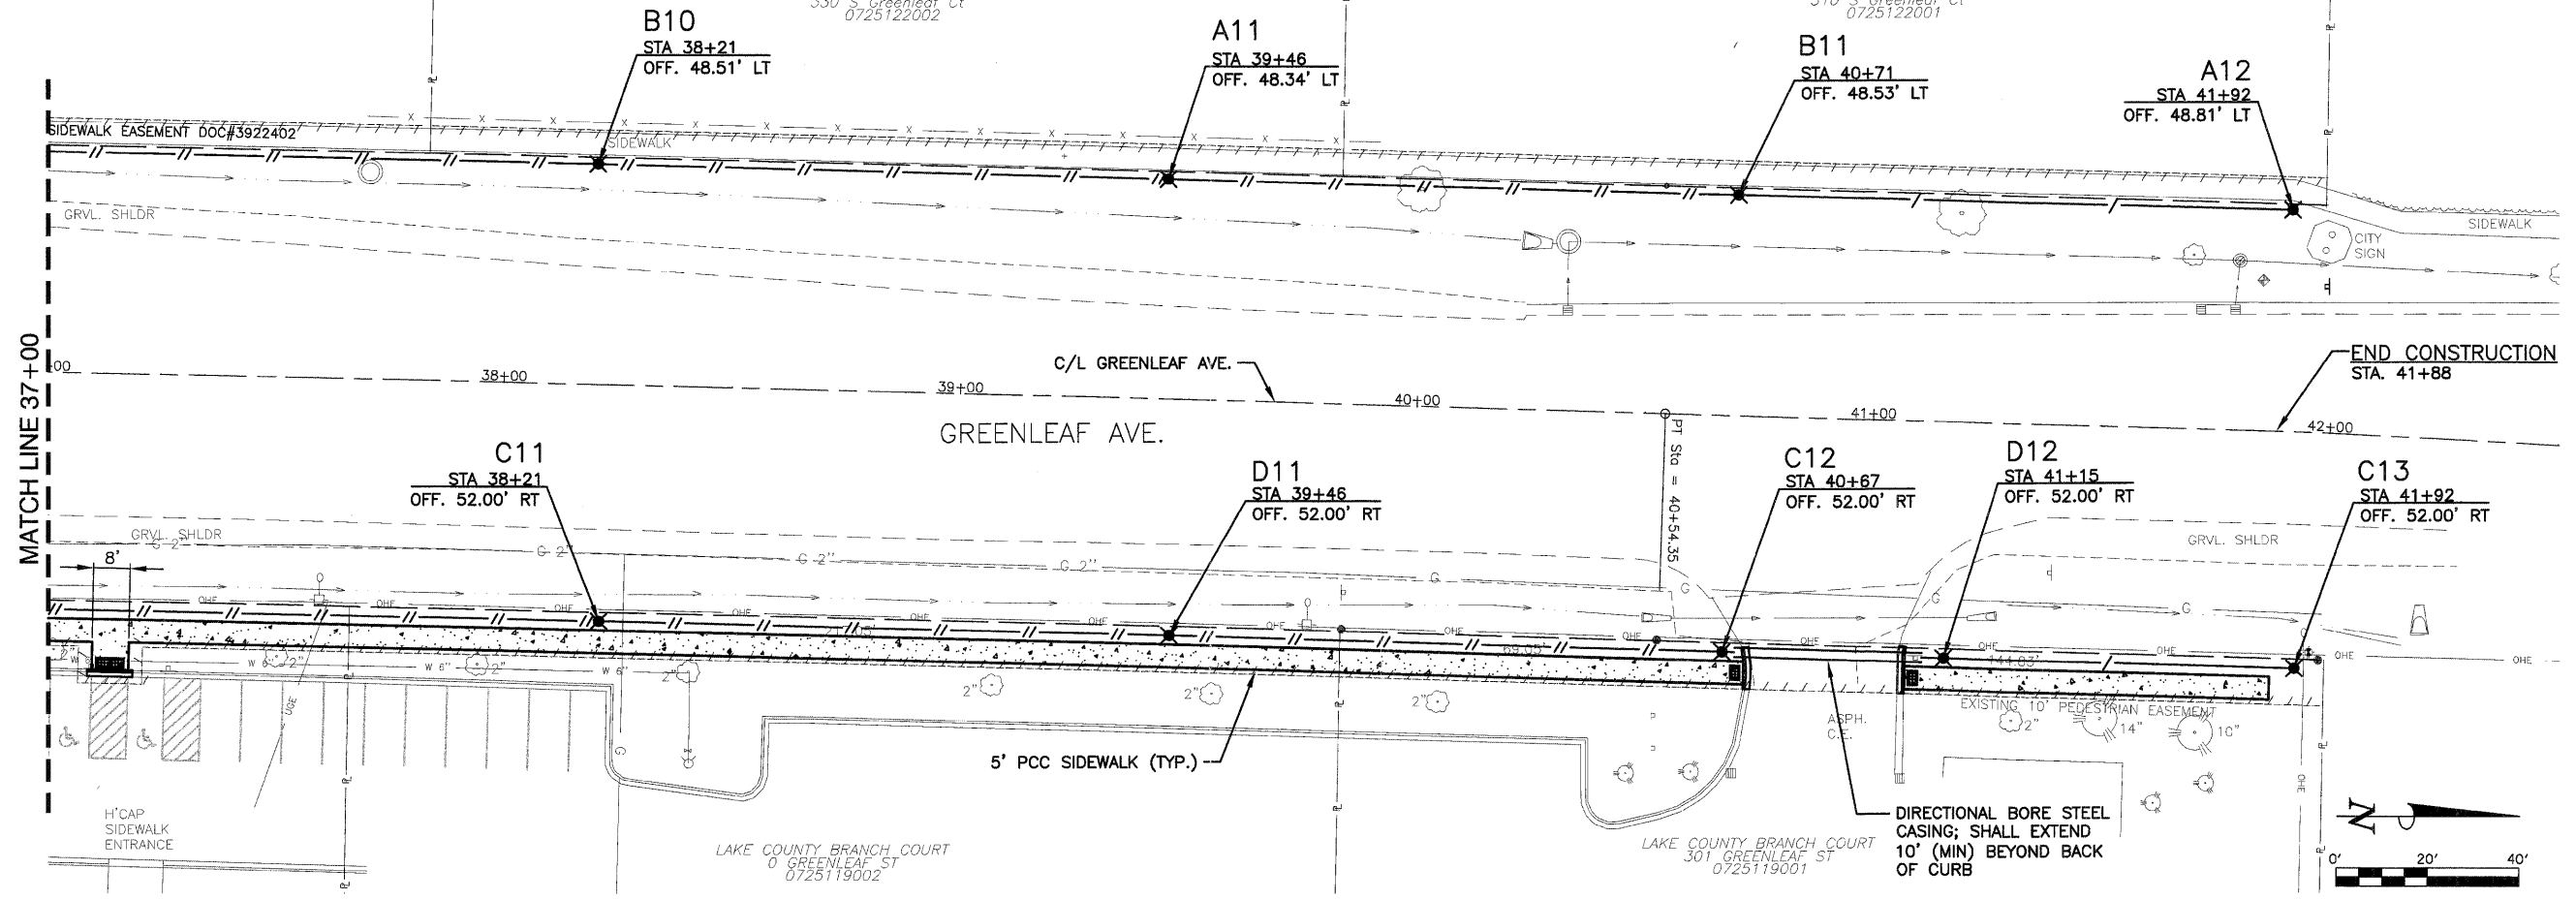

WEST SIDE PROFILE

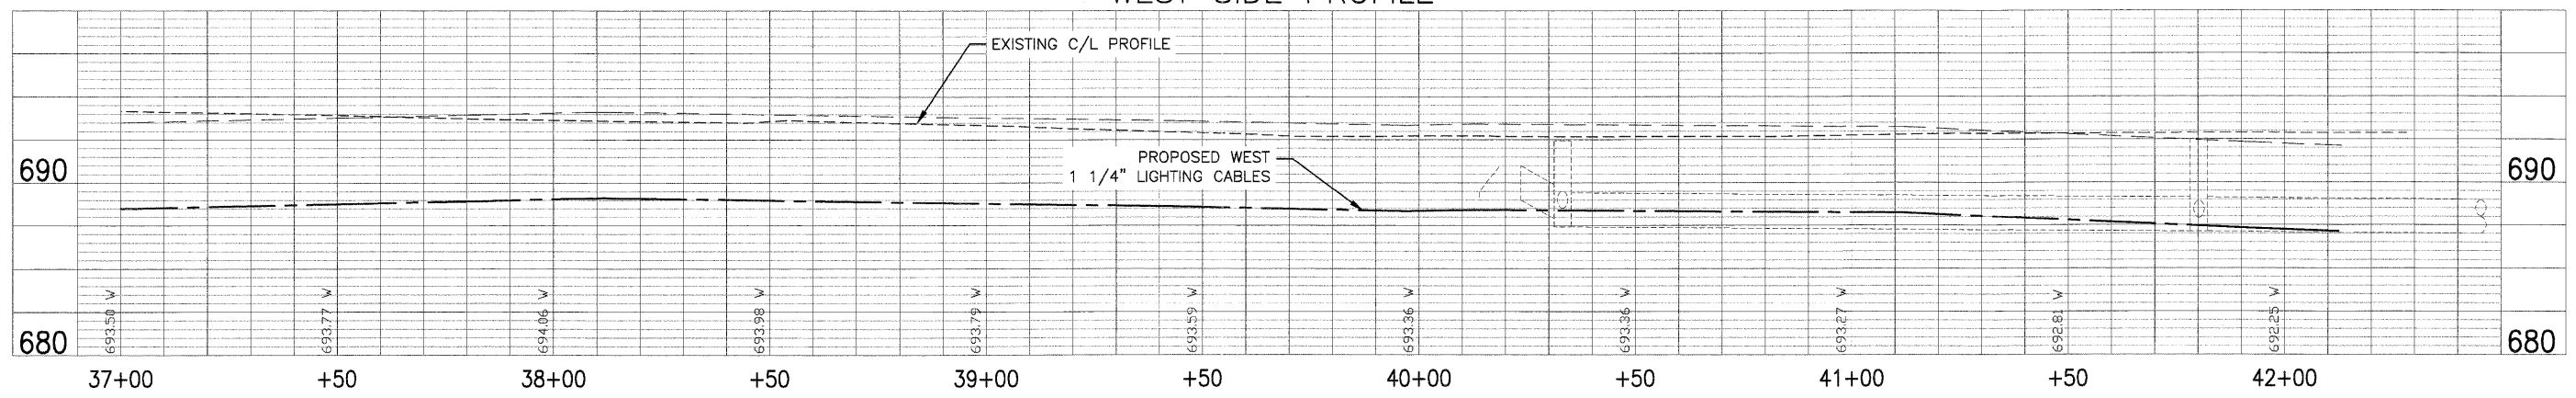

EAST SIDE PROFILE

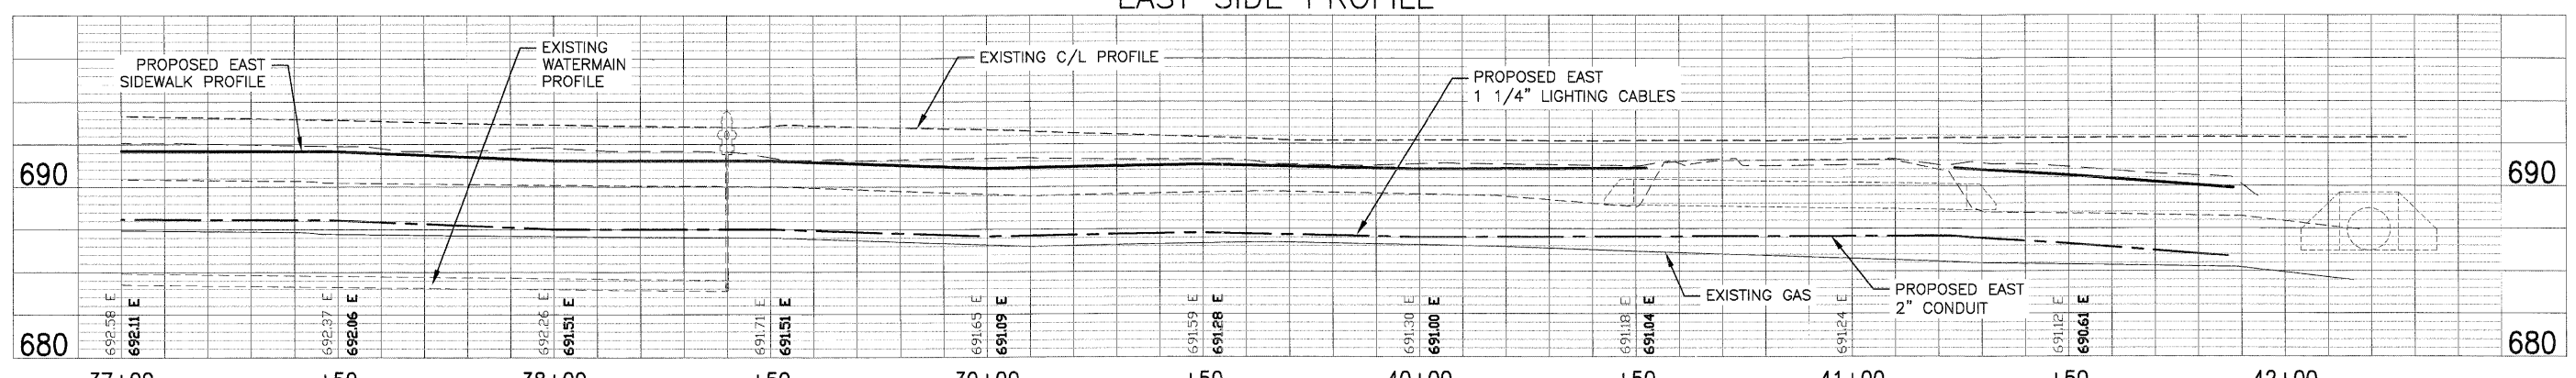

FILE NAME = P:\P0100\50\SURVEY\2010 FED\GREENLEAF.DWG	USER NAME =	DESIGNED - EKS	REVISED -	STATE OF ILLINOIS DEPARTMENT OF TRANSPORTATION	GREENLEAF AVENUE SIDEWALKS LIGHTING PLAN	F.A.U. RTE. = 2701	SECTION = 10-00042-00-SW	COUNTY = LAKE	TOTAL SHEETS = 34	SHEET NO. = 23		
	PLOT SCALE = AS SHOWN	DRAWN - SRU	REVISED -			SHEET NO. 23 OF 34 SHEETS		STA. 37+00 TO STA. 42+00		CONTRACT NO. 63605		
	PLOT DATE =	CHECKED - MKK	REVISED -			ILLINOIS		FED. AID PROJECT				
		DATE - 12/29/2011	REVISED -									