


 





J:\PROJECTS\7005\0745-VILLAGE OF OAK BROOK\008-22ND STREET ITEP ENHANCEMENTS\H GRAPHICS\05-DD-CO\10-11-ELECTRICAL.DWG 11
 Plotfile: 12/19/2011 11:42 AM By: TKING
 Copyright © 2011, By: Hitchcock Design Group

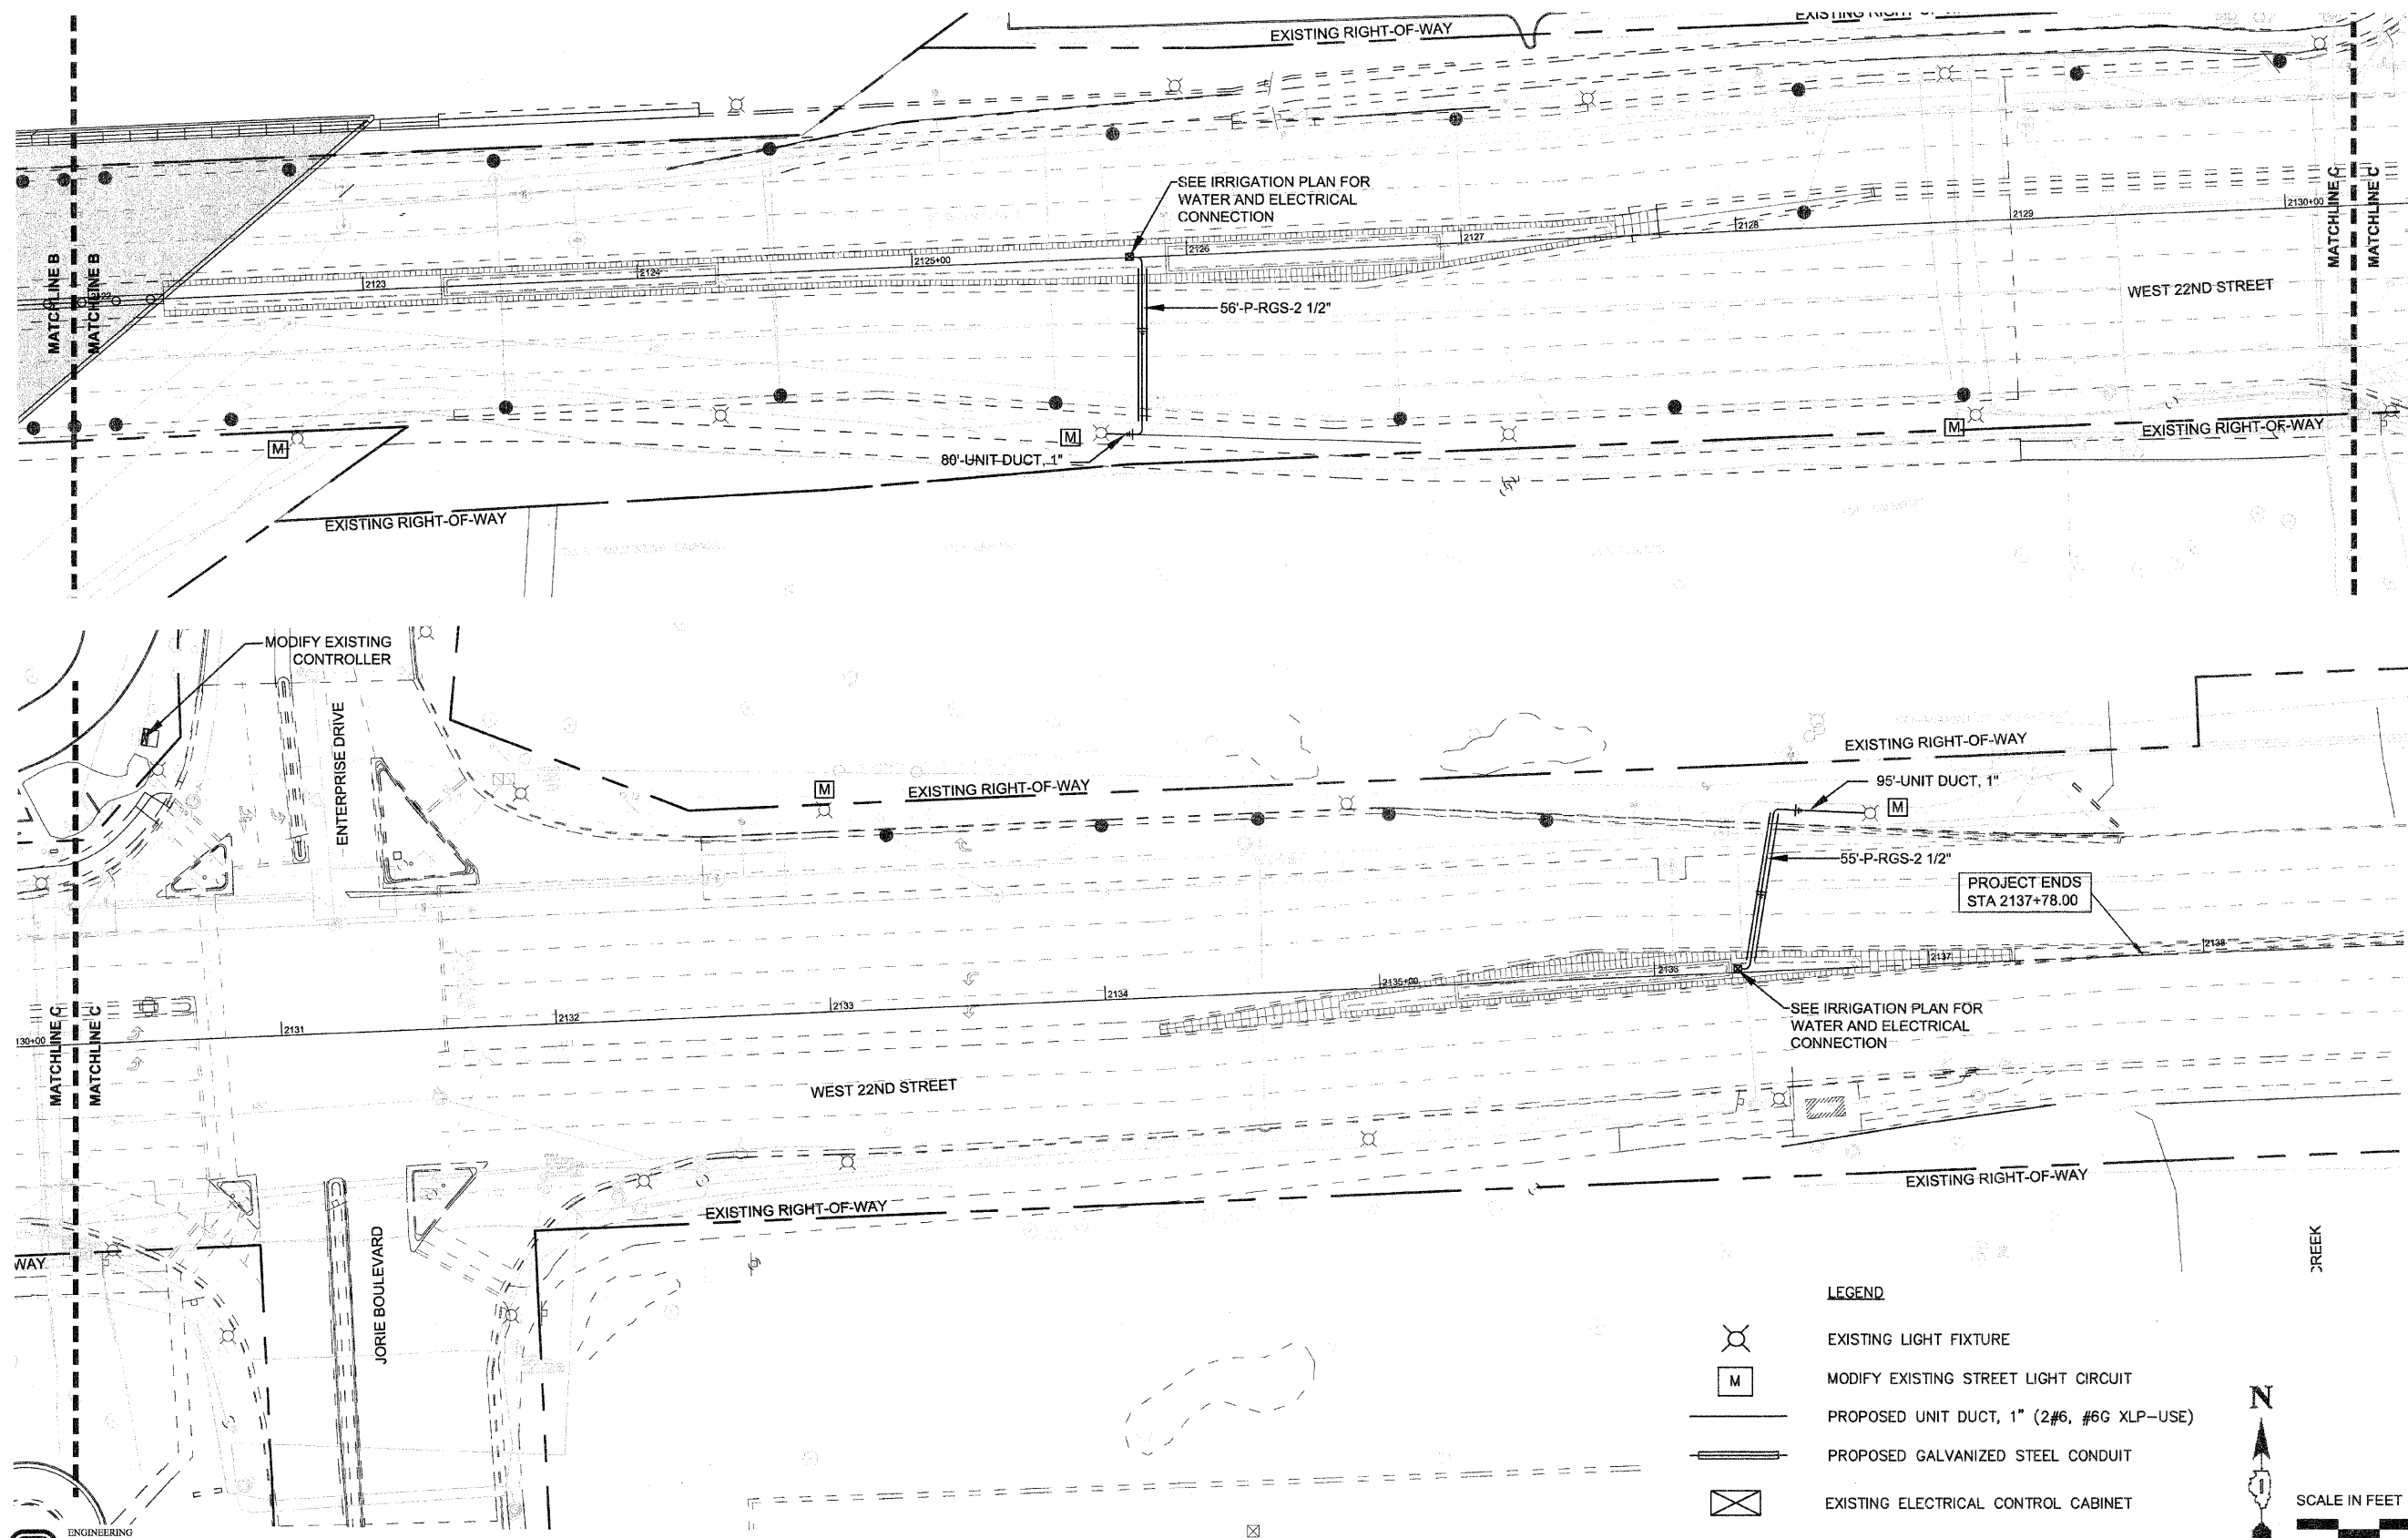

- LEGEND**
-  EXISTING LIGHT FIXTURE
 -  MODIFY EXISTING STREET LIGHT CIRCUIT
 -  PROPOSED UNIT DUCT, 1" (2#6, #6G XLP-USE)
 -  PROPOSED GALVANIZED STEEL CONDUIT
 -  EXISTING ELECTRICAL CONTROL CABINET



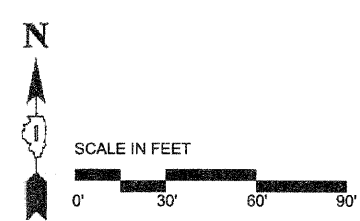HITCHCOCK DESIGN GROUP
 creating better places

DESIGNED - MEU	REVISED -
DRAWN - BLG	REVISED -
CHECKED - TCK	REVISED -
DATE - 12-19-11	REVISED -

**STATE OF ILLINOIS
 DEPARTMENT OF TRANSPORTATION**

ELECTRICAL PLAN

SCALE: 1" = 30' PROJECT - 03-0745-008 STA. 2122+83.00 TO STA. 2138+83.00

F.A.U. RTE. 1453	SECTION 11-00043-00-LS	COUNTY DUPAGE	TOTAL SHEETS 20	SHEET NO. 11
CONTRACT 63663				
FED. ROAD DIST. NO. 1 ILLINOIS FED. AID PROJECT TE-001 (672)				