


FOUNDATION PLAN

SCALE: 1/4" = 1'-0"

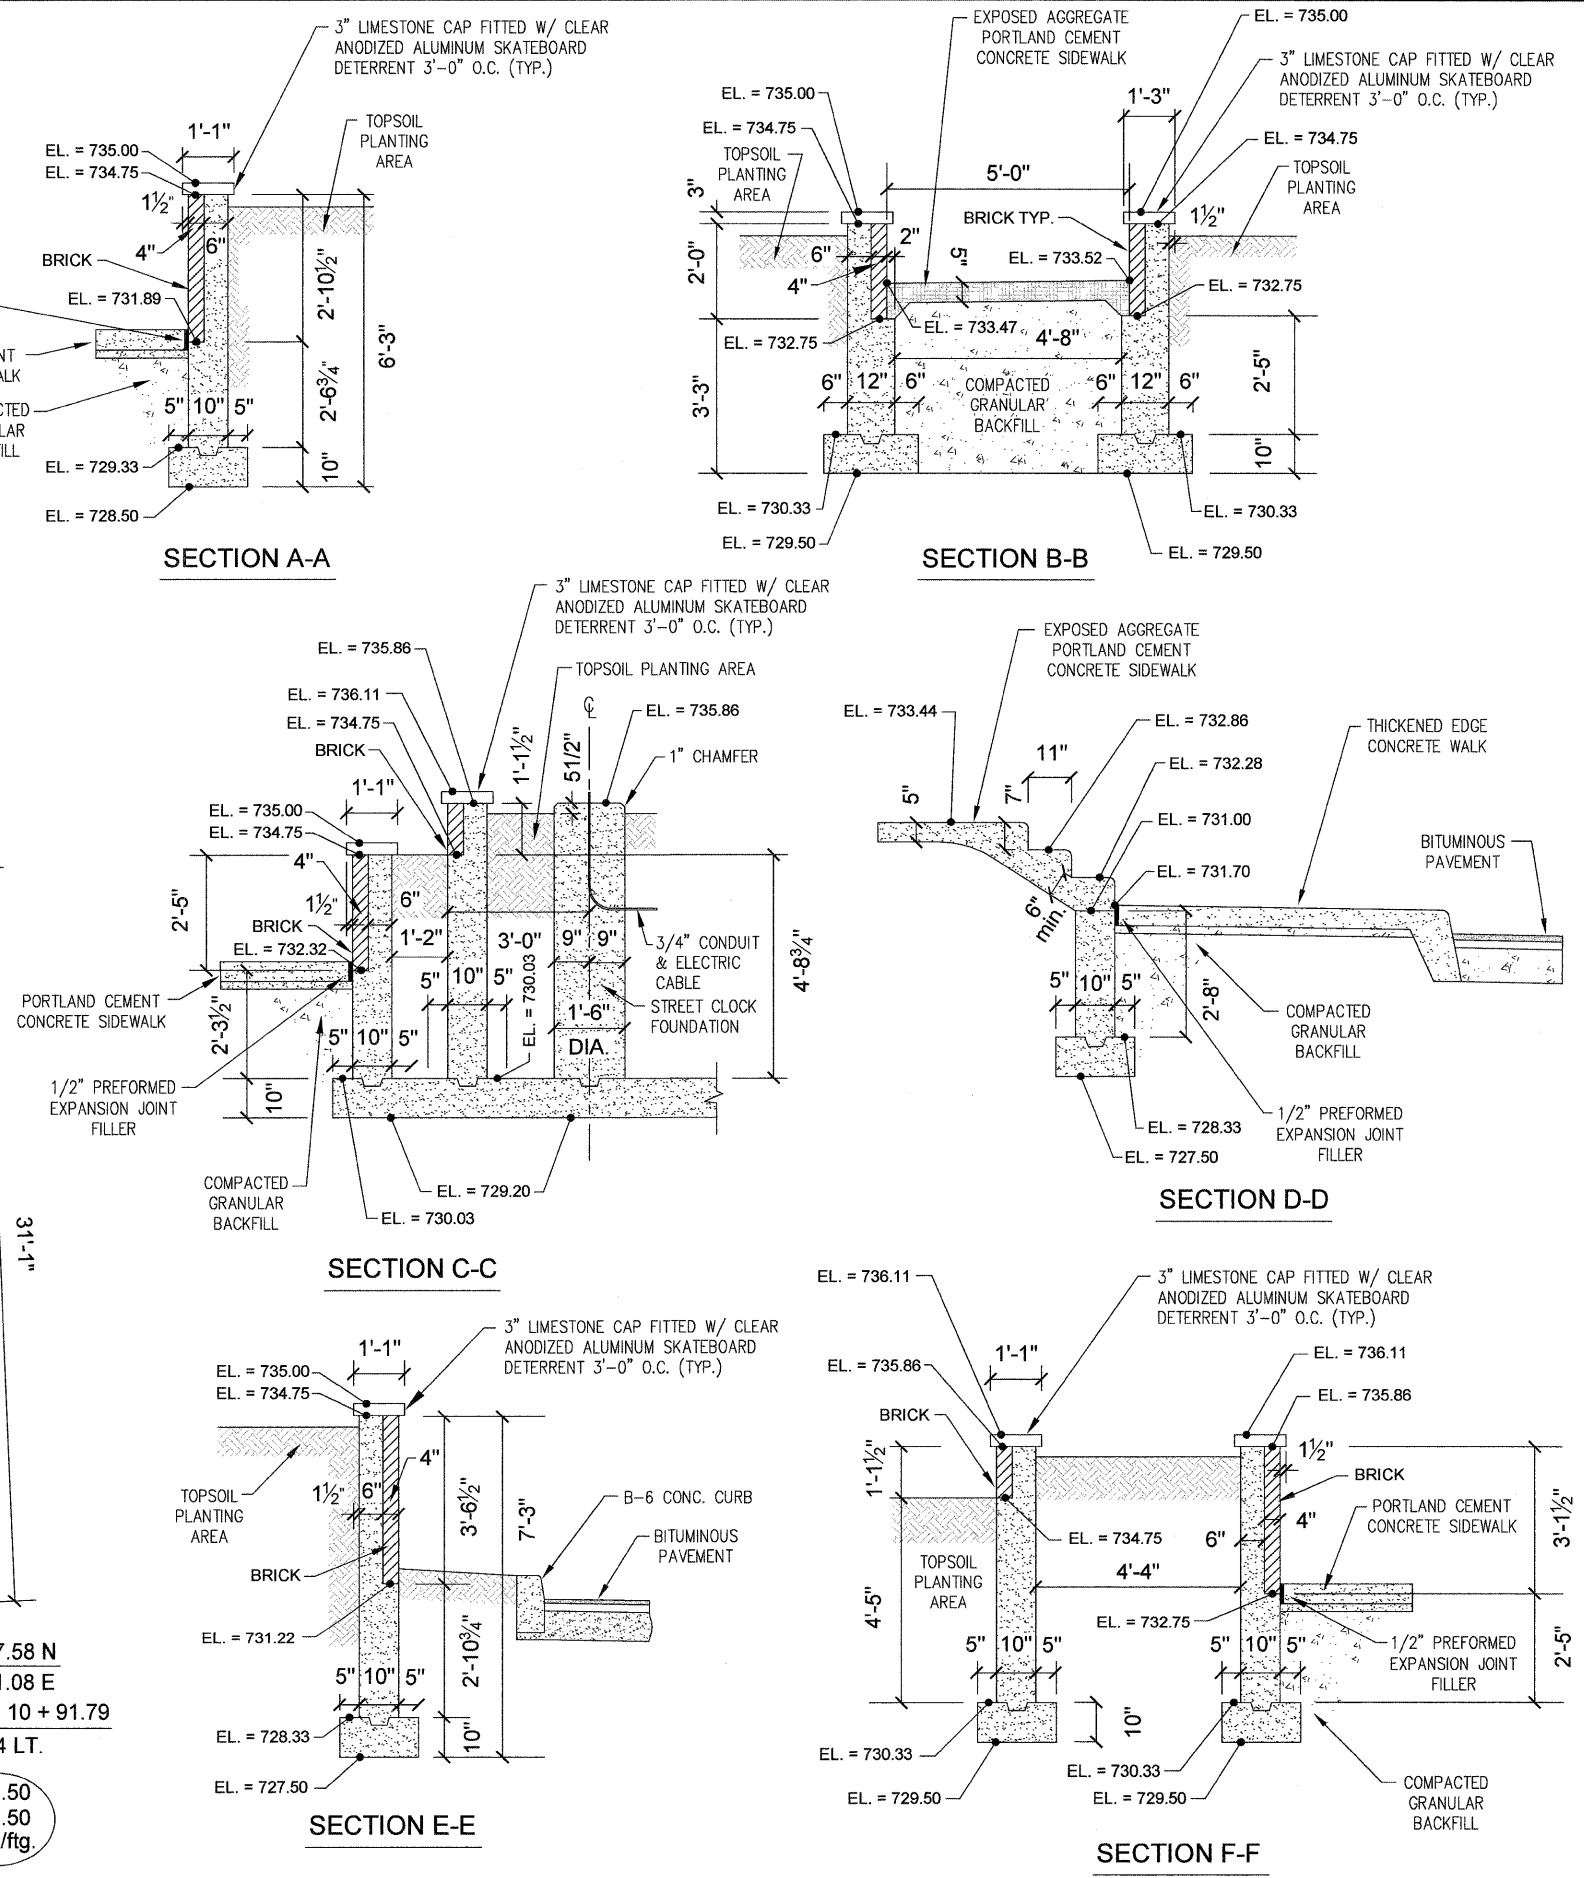

TECH 3 Consulting Group, Inc.
 ENGINEERS SURVEYORS
 787 West Exchange St., Crete, IL 60417
 PH: 708.672.4994 FAX: 708.672.3709
 ILLINOIS PROFESSIONAL DESIGN FIRM NO. 184-002235

USER NAME =
 PLOT SCALE =
 PLOT DATE =

DESIGNED - WJS
 DRAWN - EGH
 CHECKED - WJS
 DATE - JUNE 23, 2011

REVISED - DEC. 21, 2011
 REVISED -
 REVISED -
 REVISED -

STATE OF ILLINOIS
DEPARTMENT OF TRANSPORTATION

Village of CRETE
 WILL COUNTY, ILLINOIS
 534 EXCHANGER STREET • P.O. BOX 397 • Phone: 708-672-5431

FOUNDATION PLAN & SECTIONS
ILLINOIS ROUTE 1 & EXCHANGE
STREET LANDSCAPING

F.A. RITE.	SECTION	COUNTY	TOTAL SHEETS	SHEET NO.
876	06-00044-004S	WILL	10	6
JOB NO. C-91-051-07		CONTRACT NO. 63664		
FED. ROAD DIST. NO. 1		ILLINOIS FED. AID PROJECT: TE-00DI (728)		

SCALE: 1/4" = 1'-0"

SHEET NO. 6 OF 10 SHEETS

STA. - TO STA. -