
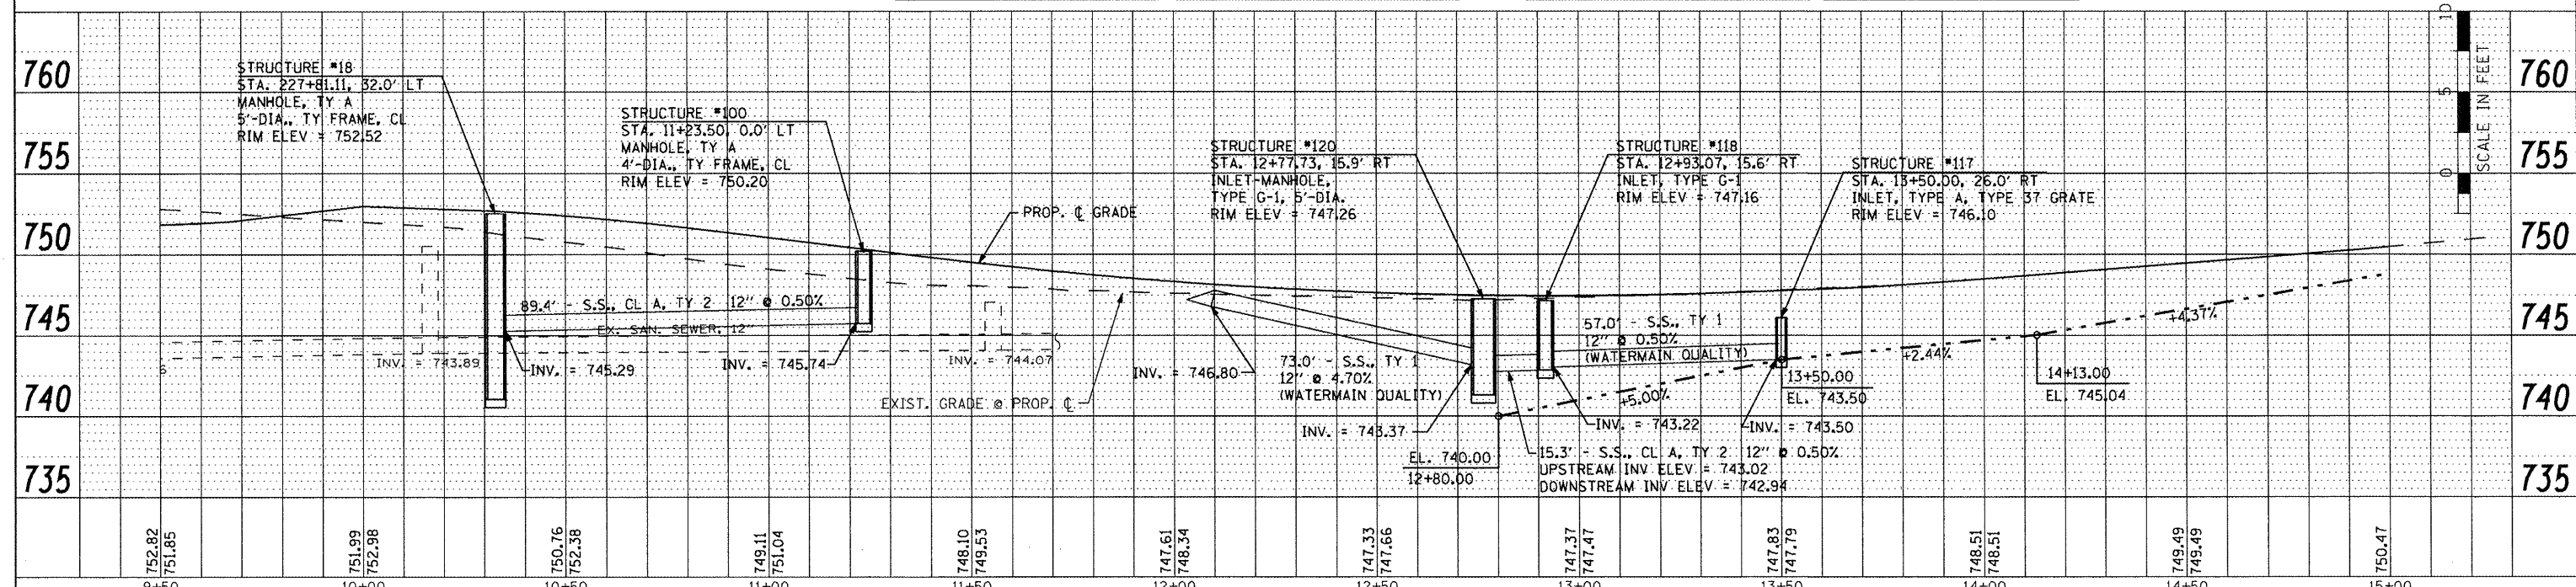


DATE	
BY	
PLAN	SURVEYED
	ALIGNED
	CHECKED
	RT. OF WAY
	CHECKED
	NO. _____
	FILE NAME
	NO. _____

DATE	
BY	
PROFILE	SURVEYED
	PLOTTED
	CHECKED
	RT. OF WAY
	CHECKED
	NO. _____
	FILE NAME
	NO. _____

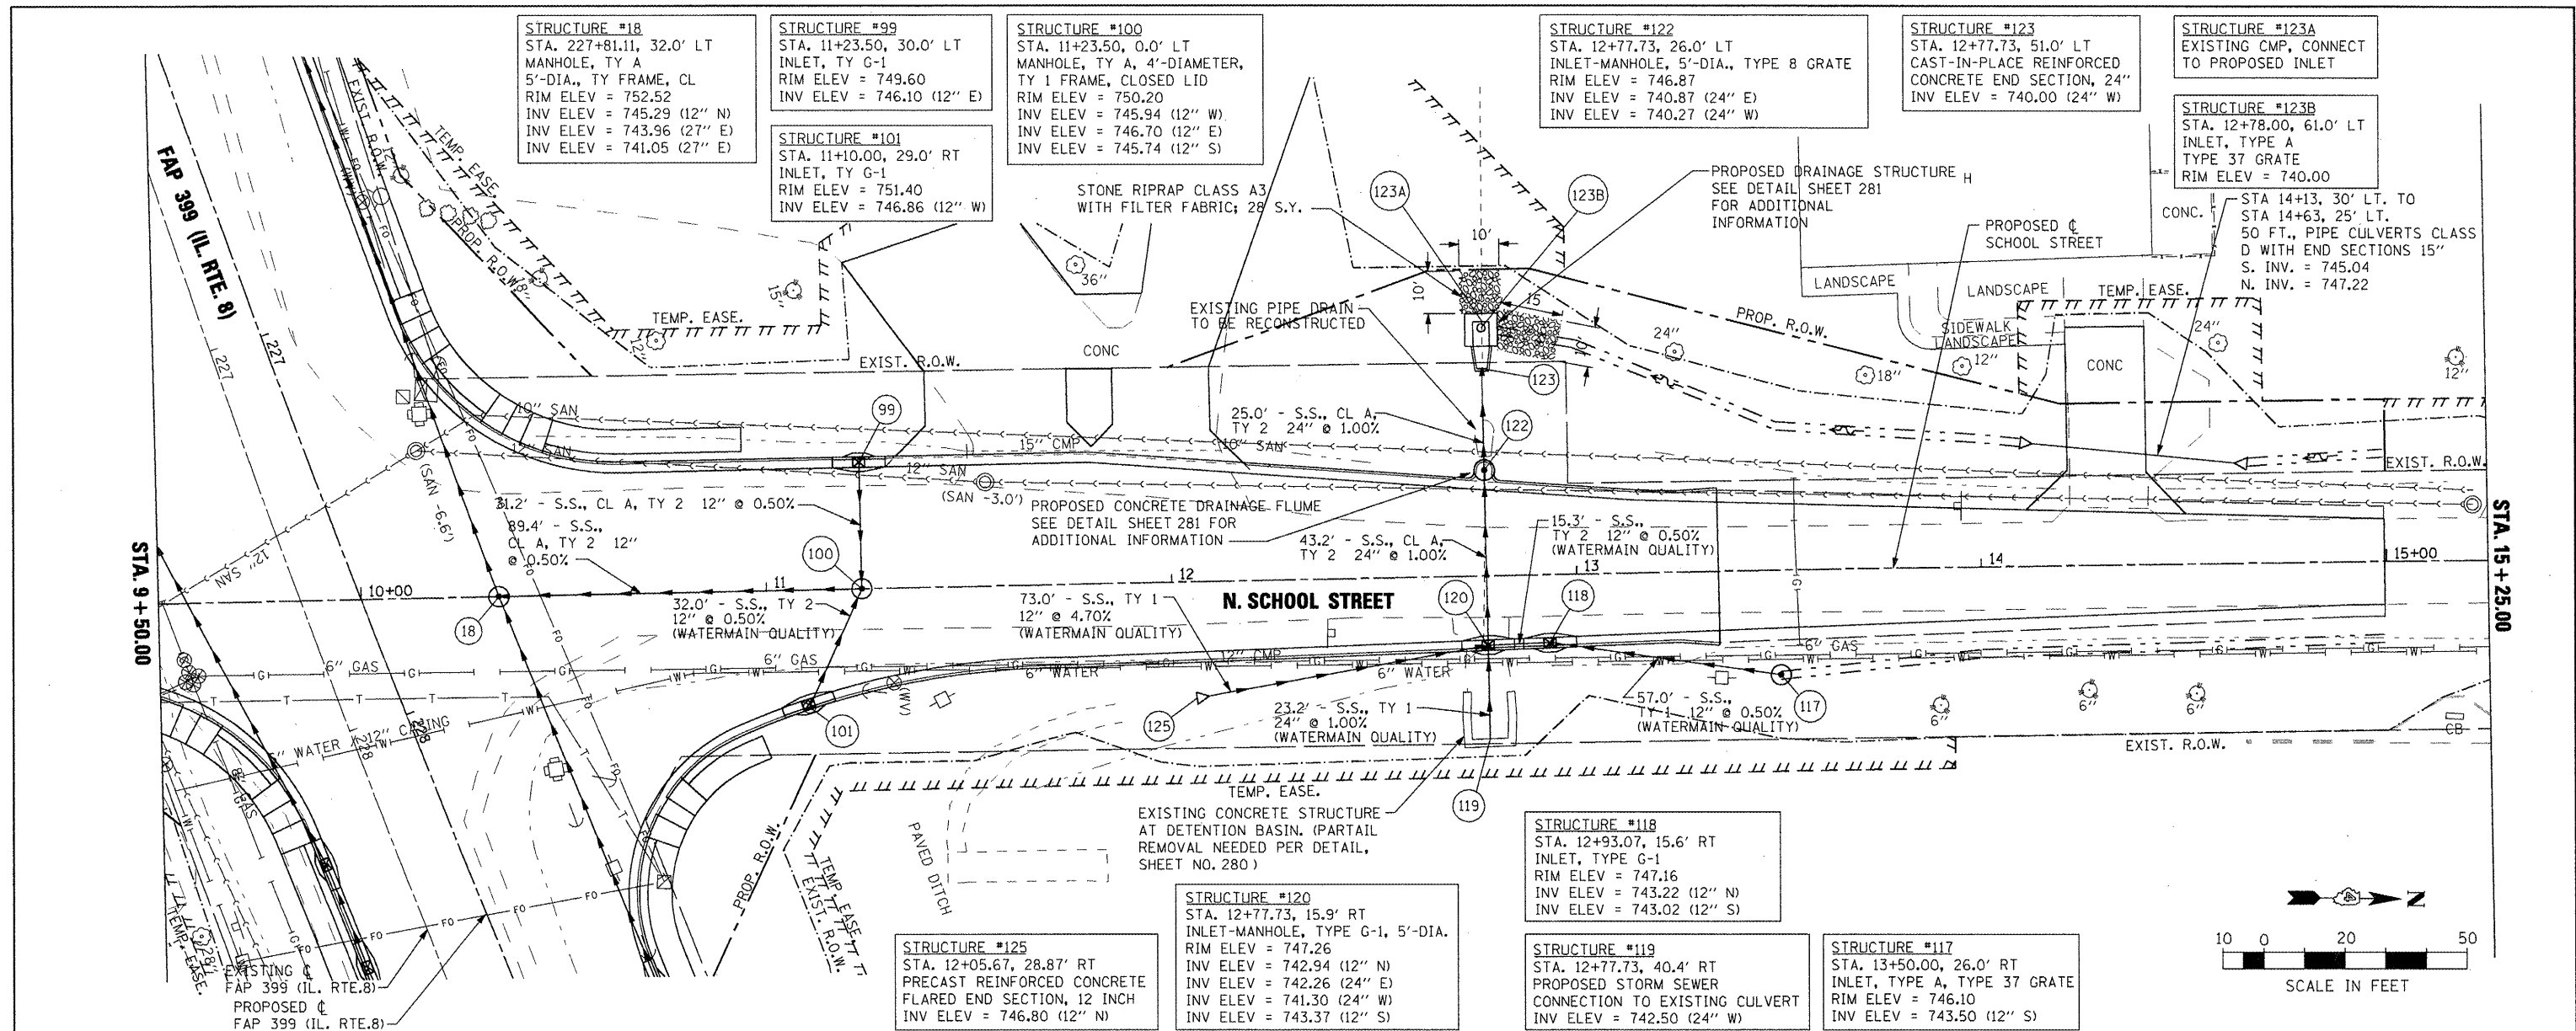

FILE NAME =	USER NAME =	DESIGNED -	REVISED -	STATE OF ILLINOIS		FAP 399 (IL. RTE. 8)		F.A.P. R.T.E. =	SECTION	COUNTY	TOTAL SHEETS	SHEET NO.
\\projects\200803566\dgn\04-Rte8-shr\DRN-N-School.dgn	DDT	DDT	DDT	DEPARTMENT OF TRANSPORTATION		NORTH SCHOOL STREET - DRAINAGE PLAN AND PROFILE		399	36 R-7	TAZEWELL	390	202
PLOT SCALE = 48.00' / IN.	CHECKED -	REVISED -	REVISED -	SCALE: AS SHOWN		SHEET NO. OF SHEETS		STA. 9+50.00 TO STA. 15+25.00		CONTRACT NO. 68370		
PLOT DATE = 10/21/2011	DATE	REVISED -	REVISED -	ILLINOIS FED. AID PROJECT								