

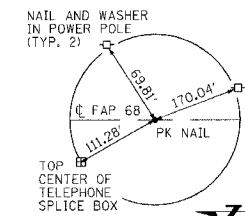


F.A.P. RTE.	SECTION	COUNTY	TOTAL SHEETS	SHEET NO.
68	105 BR-1	LIVINGSTON	45	9
STA. 592+50.00 TO STA. 597+00.00		ILLINOIS FED. AID PROJECT		

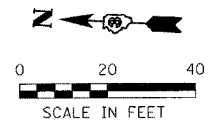

P.O.T. STA. 596+00

PLAN	DATE
BY	
NOTED	
CHECKED	
BY	
DATE	

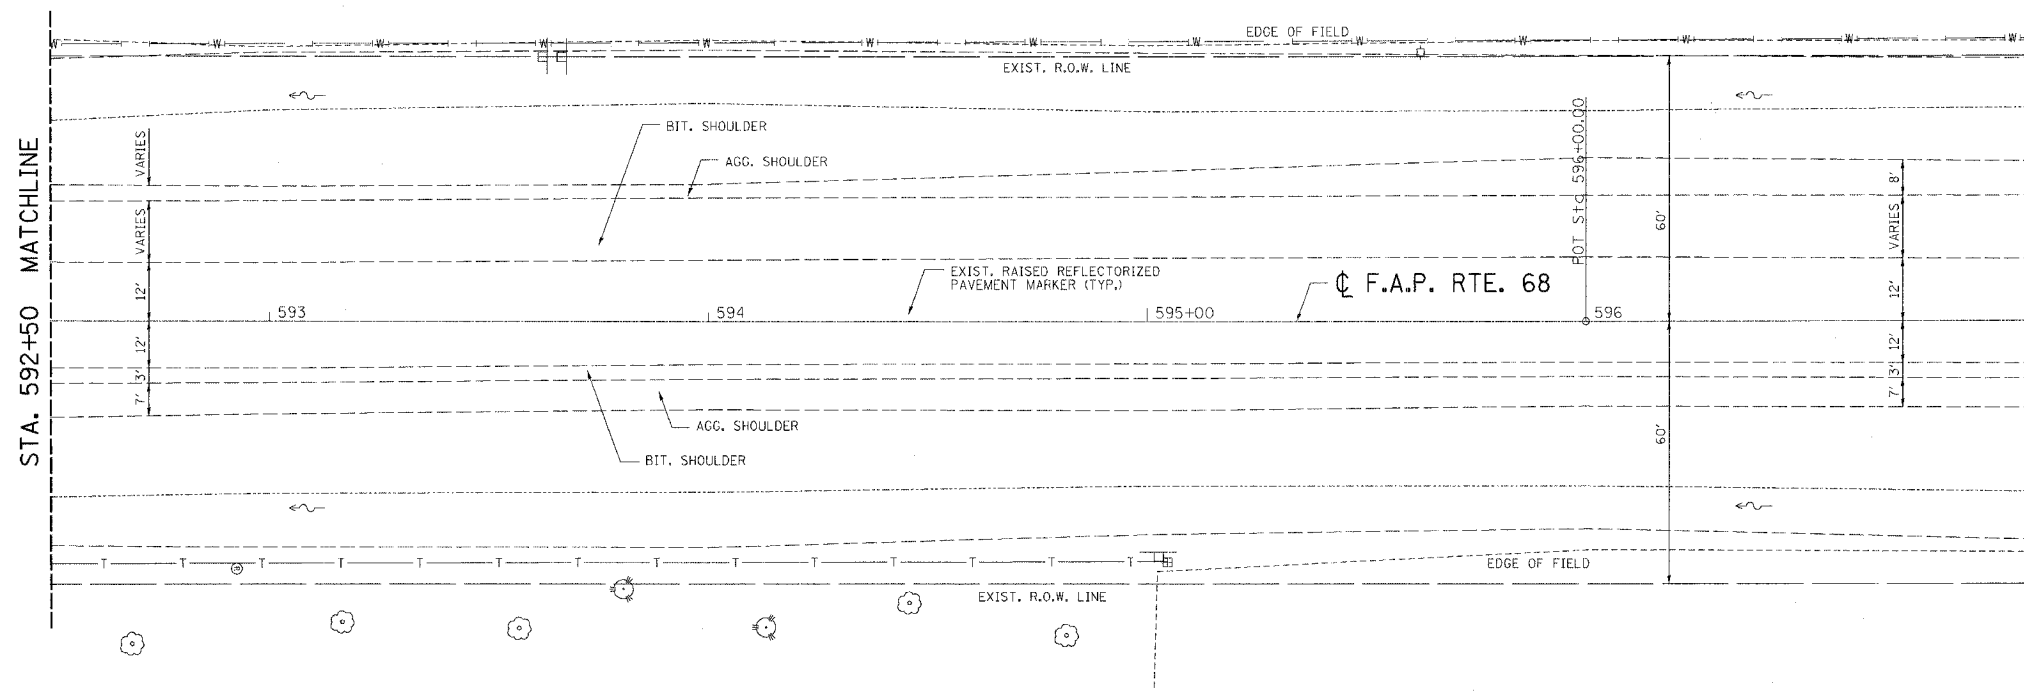


REVISION	DATE	BY

GREEN & BRADFORD, INC.
CONSULTING ENGINEERS
 2001 W. STATE ST.
 SPRINGFIELD, ILLINOIS 62760
 PHONE: 217-223-1111 FAX: 217-223-1112
 000 700 804 200 700 500 700 500 700 500

COMPUTER FILE NO.
03236.W011.PP-4
 PROJECT 03236 W11
 11/15/05 - MDS

PROFILE	DATE
BY	
NOTED	
CHECKED	
BY	
DATE	

PLOT DATE = 12/21/2005
 FILE NAME = J:\03236\w011\p\m\p\m\03236.W011.PP.dgn
 PLOT SCALE = 20.000000 / IN.
 OPERATOR = mds

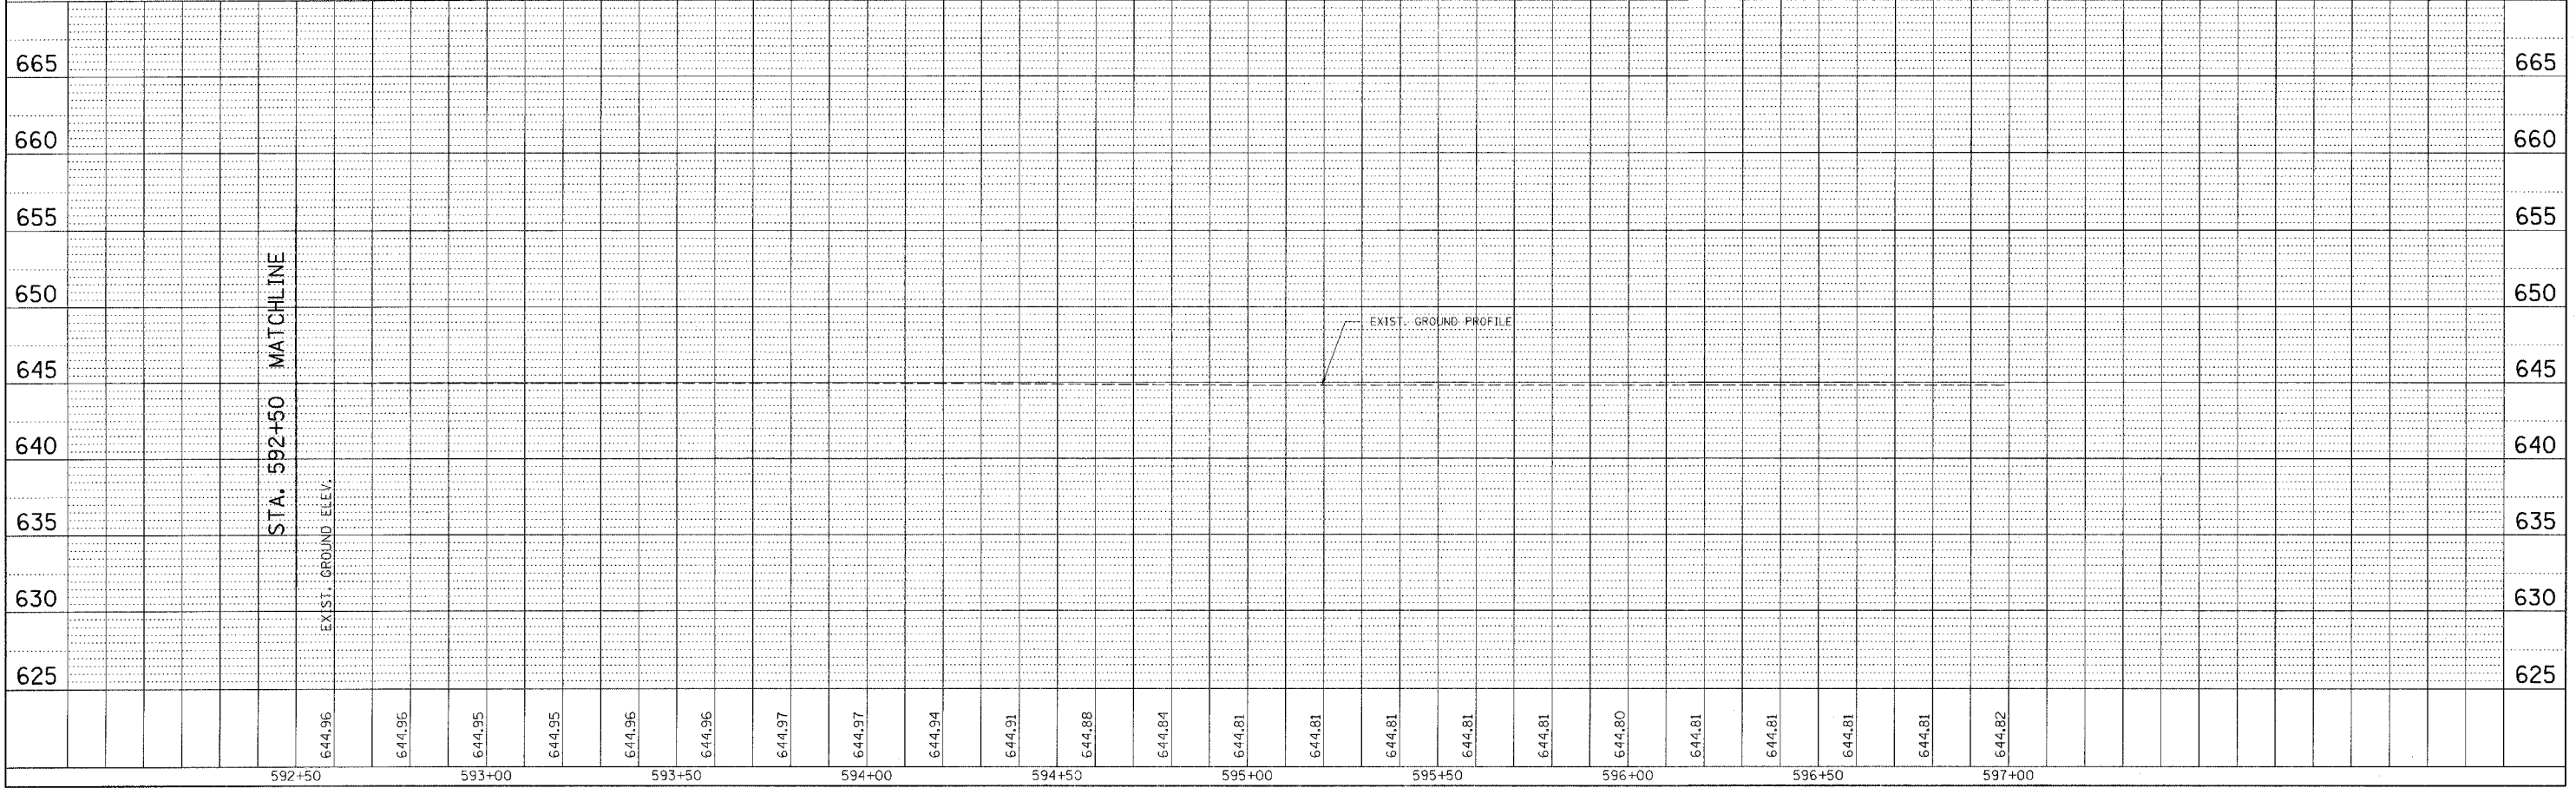

F.A.P. RTE. 68 PLAN AND PROFILE - PROPOSED STRUCTURE REPLACEMENT