



F.A.P. RTE.	SECTION	COUNTY	TOTAL SHEETS	SHEET NO.
68	105 BR-1	LIVINGSTON	45	10
STA. 1580+00		TO STA. 1590+00		
FED. ROAD DIST. NO.		ILLINOIS	FED. AID PROJECT	

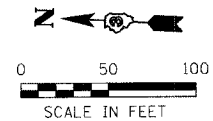


NOTE : TEMPORARY RUMBLE STRIPS AND SIGNS AS SHOWN IN TRAFFIC CONTROL AND PROTECTION STANDARD 701321 AND 702001 SHALL BE INSTALLED.

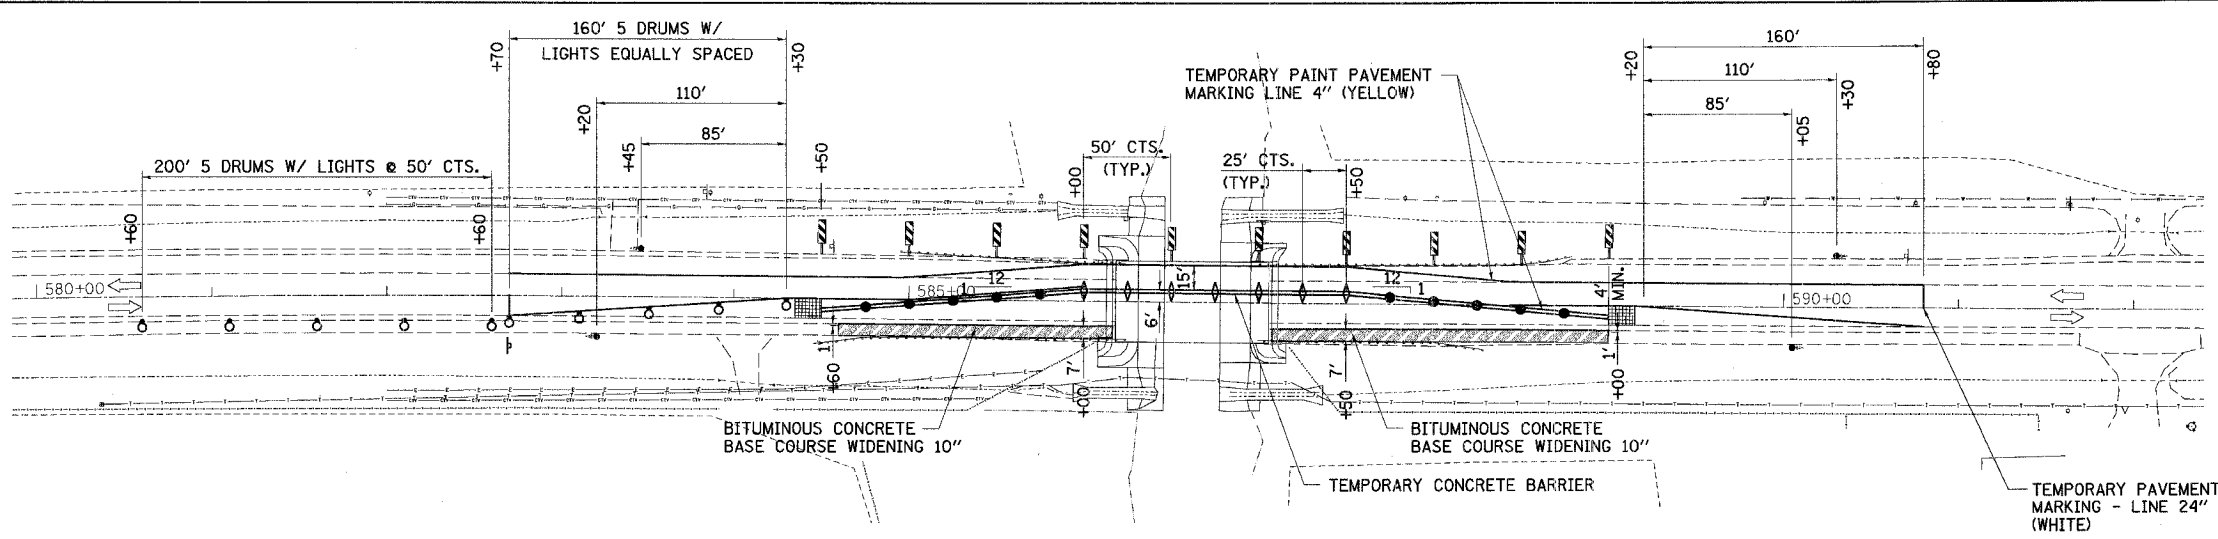

TRAFFIC CONTROL

STAGE I SEQUENCE OF OPERATIONS


1. INSTALL TEMPORARY TRAFFIC SIGNALS, ATTENUATOR BASES, ATTENUATORS, TEMPORARY CONCRETE BARRIERS AND DRUMS WITH THE AID OF TRAFFIC CONTROL AND PROTECTION STANDARDS 701201 AND 701006. ALL OTHER ITEMS AS PER THESE DETAILS AND AS PER LANE CLOSURE 2L, 2W, BRIDGE REPAIR WITH BARRIER STANDARD 701321. BEGIN OPERATING UNDER STAGE I TRAFFIC CONDITIONS WITH THE AID OF TRAFFIC CONTROL AND PROTECTION STANDARD 701201 AND 701006.
2. REMOVE EXISTING AGGREGATE SHOULDERS, GUARDRAIL & TRAFFIC BARRIER TERMINALS, EXCAVATE, AND REMOVE PORTION OF EXISTING SUPER-STRUCTURE.
3. CONSTRUCT NEW PORTION OF PROPOSED SUPER-STRUCTURE, BACKFILL, COMPACT, BITUMINOUS CONCRETE BASE COURSE WIDENING, TRAFFIC BARRIER TERMINAL AND TEMPORARY RAMPS.

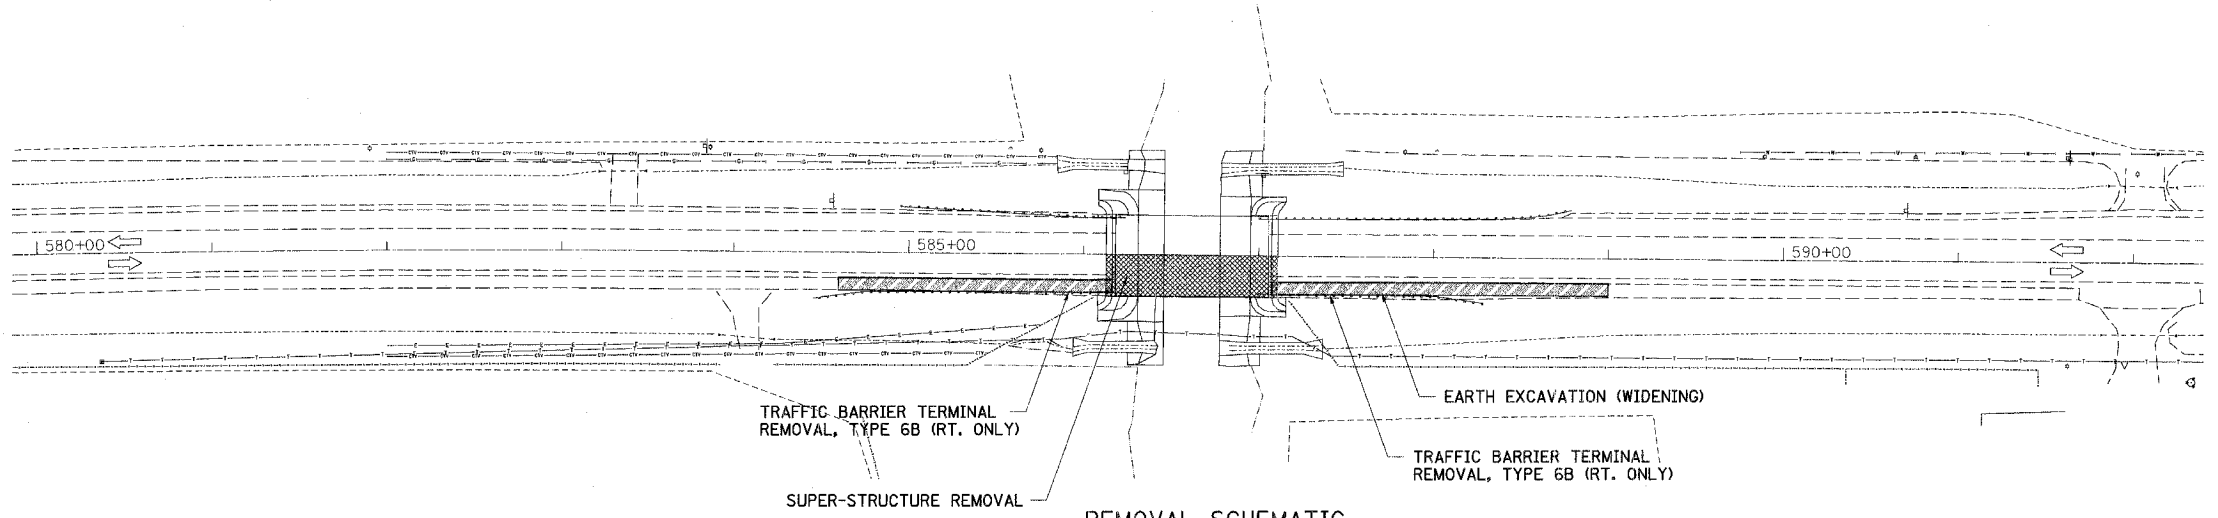

REMOVAL SCHEMATIC

LEGEND

- STRUCTURE REMOVAL
- BITUMINOUS CONCRETE BASE COURSE WIDENING 10"
- TYPE III BARRICADE WITH FLASHING LIGHTS
- TRAFFIC SIGNALS
- DRUM WITH STEADY BURNING LIGHT
- STOP LINE 24"
- SAND MODULE IMPACT ATTENUATOR
- DOUBLE VERTICAL PANEL
- TYPE C BIDIRECTIONAL REFLECTOR
- STEADY BURNING LIGHTS AND DOUBLE VERTICAL PANEL

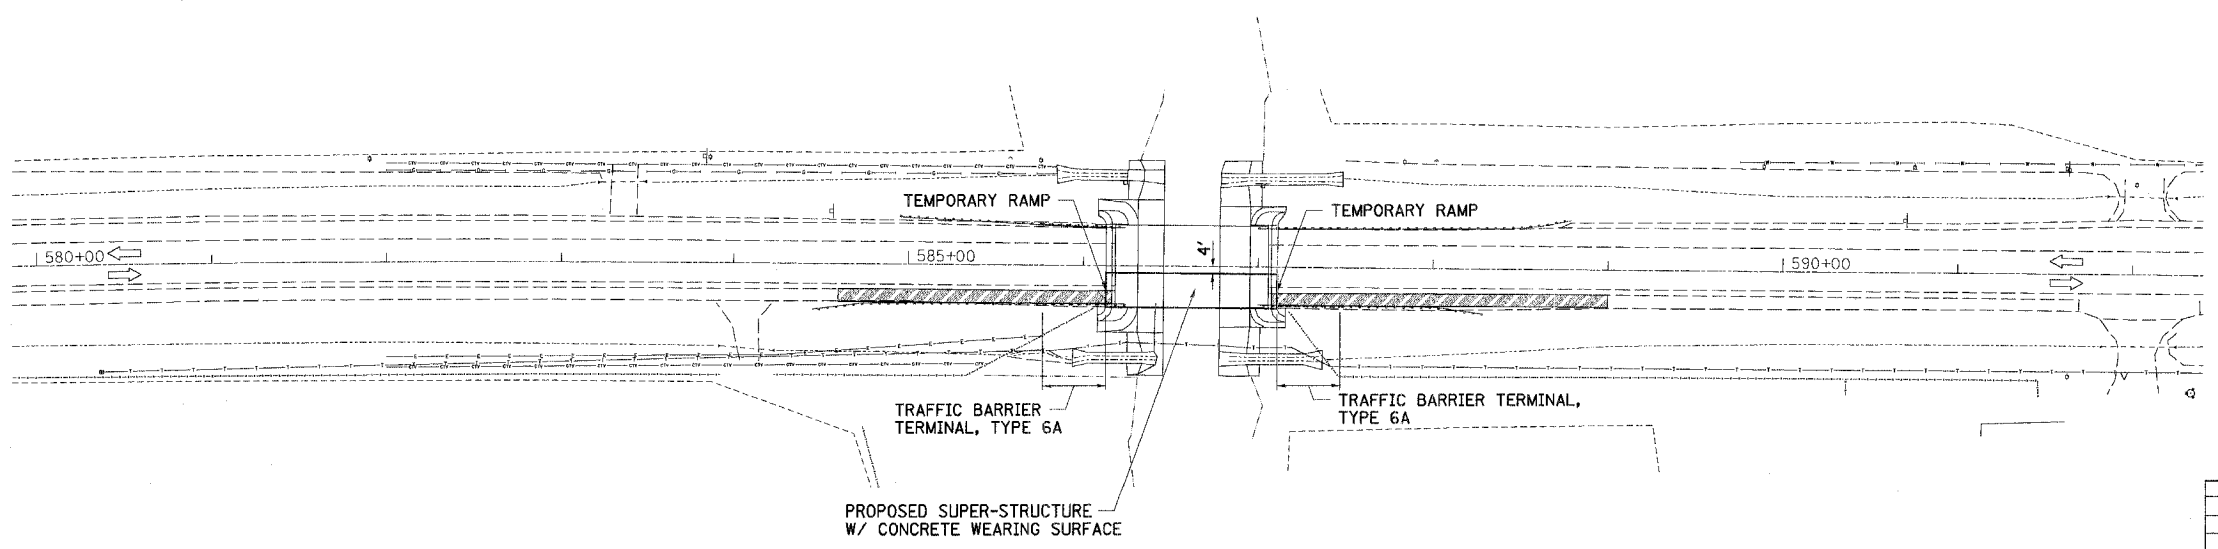

CONSTRUCTION SCHEMATIC

PLOT DATE = 12/21/2005  
 FILE NAME = J:\03236\w011\drawings\03236\_W011\_STG1.dgn  
 PLOT SCALE = 50.000000 / IN.  
 REFERENCE = .REF  
 DEPARTMENT = mdrn01141

REVISIONS	
NAME	DATE

ILLINOIS DEPARTMENT OF TRANSPORTATION

**STAGE I CONSTRUCTION**

FAP ROUTE 68 (IL RTE. 23)  
 SECTION 105 BR-1  
 LIVINGSTON COUNTY

SCALE: VERT. \_\_\_\_\_  
 HORIZ. \_\_\_\_\_

DATE: \_\_\_\_\_

DRAWN BY: BISHOP  
 CHECKED BY: BOTT

GREENE & BRADFORD, INC.  
 CONSULTING ENGINEERS  
 1201 N. WASHINGTON ST., SUITE 200  
 DECATUR, IL 62521-1000  
 (312) 424-1200 FAX (312) 424-1201  
 WWW.GREENE-AND-BRADFORD.COM

COMPUTER FILE NO.  
 03236\_W011\_STG1  
 PROJECT 03236 W011  
 11/15/05 - MDS