



JAN 18, 2006 10:46 PM RAW  
 F:\AIRPORTS\KEWANEE\810-06TXYD\AIRPORT\SHEETS\R-142ELE.DWG - STA. 20+00 TO STA. 26+00

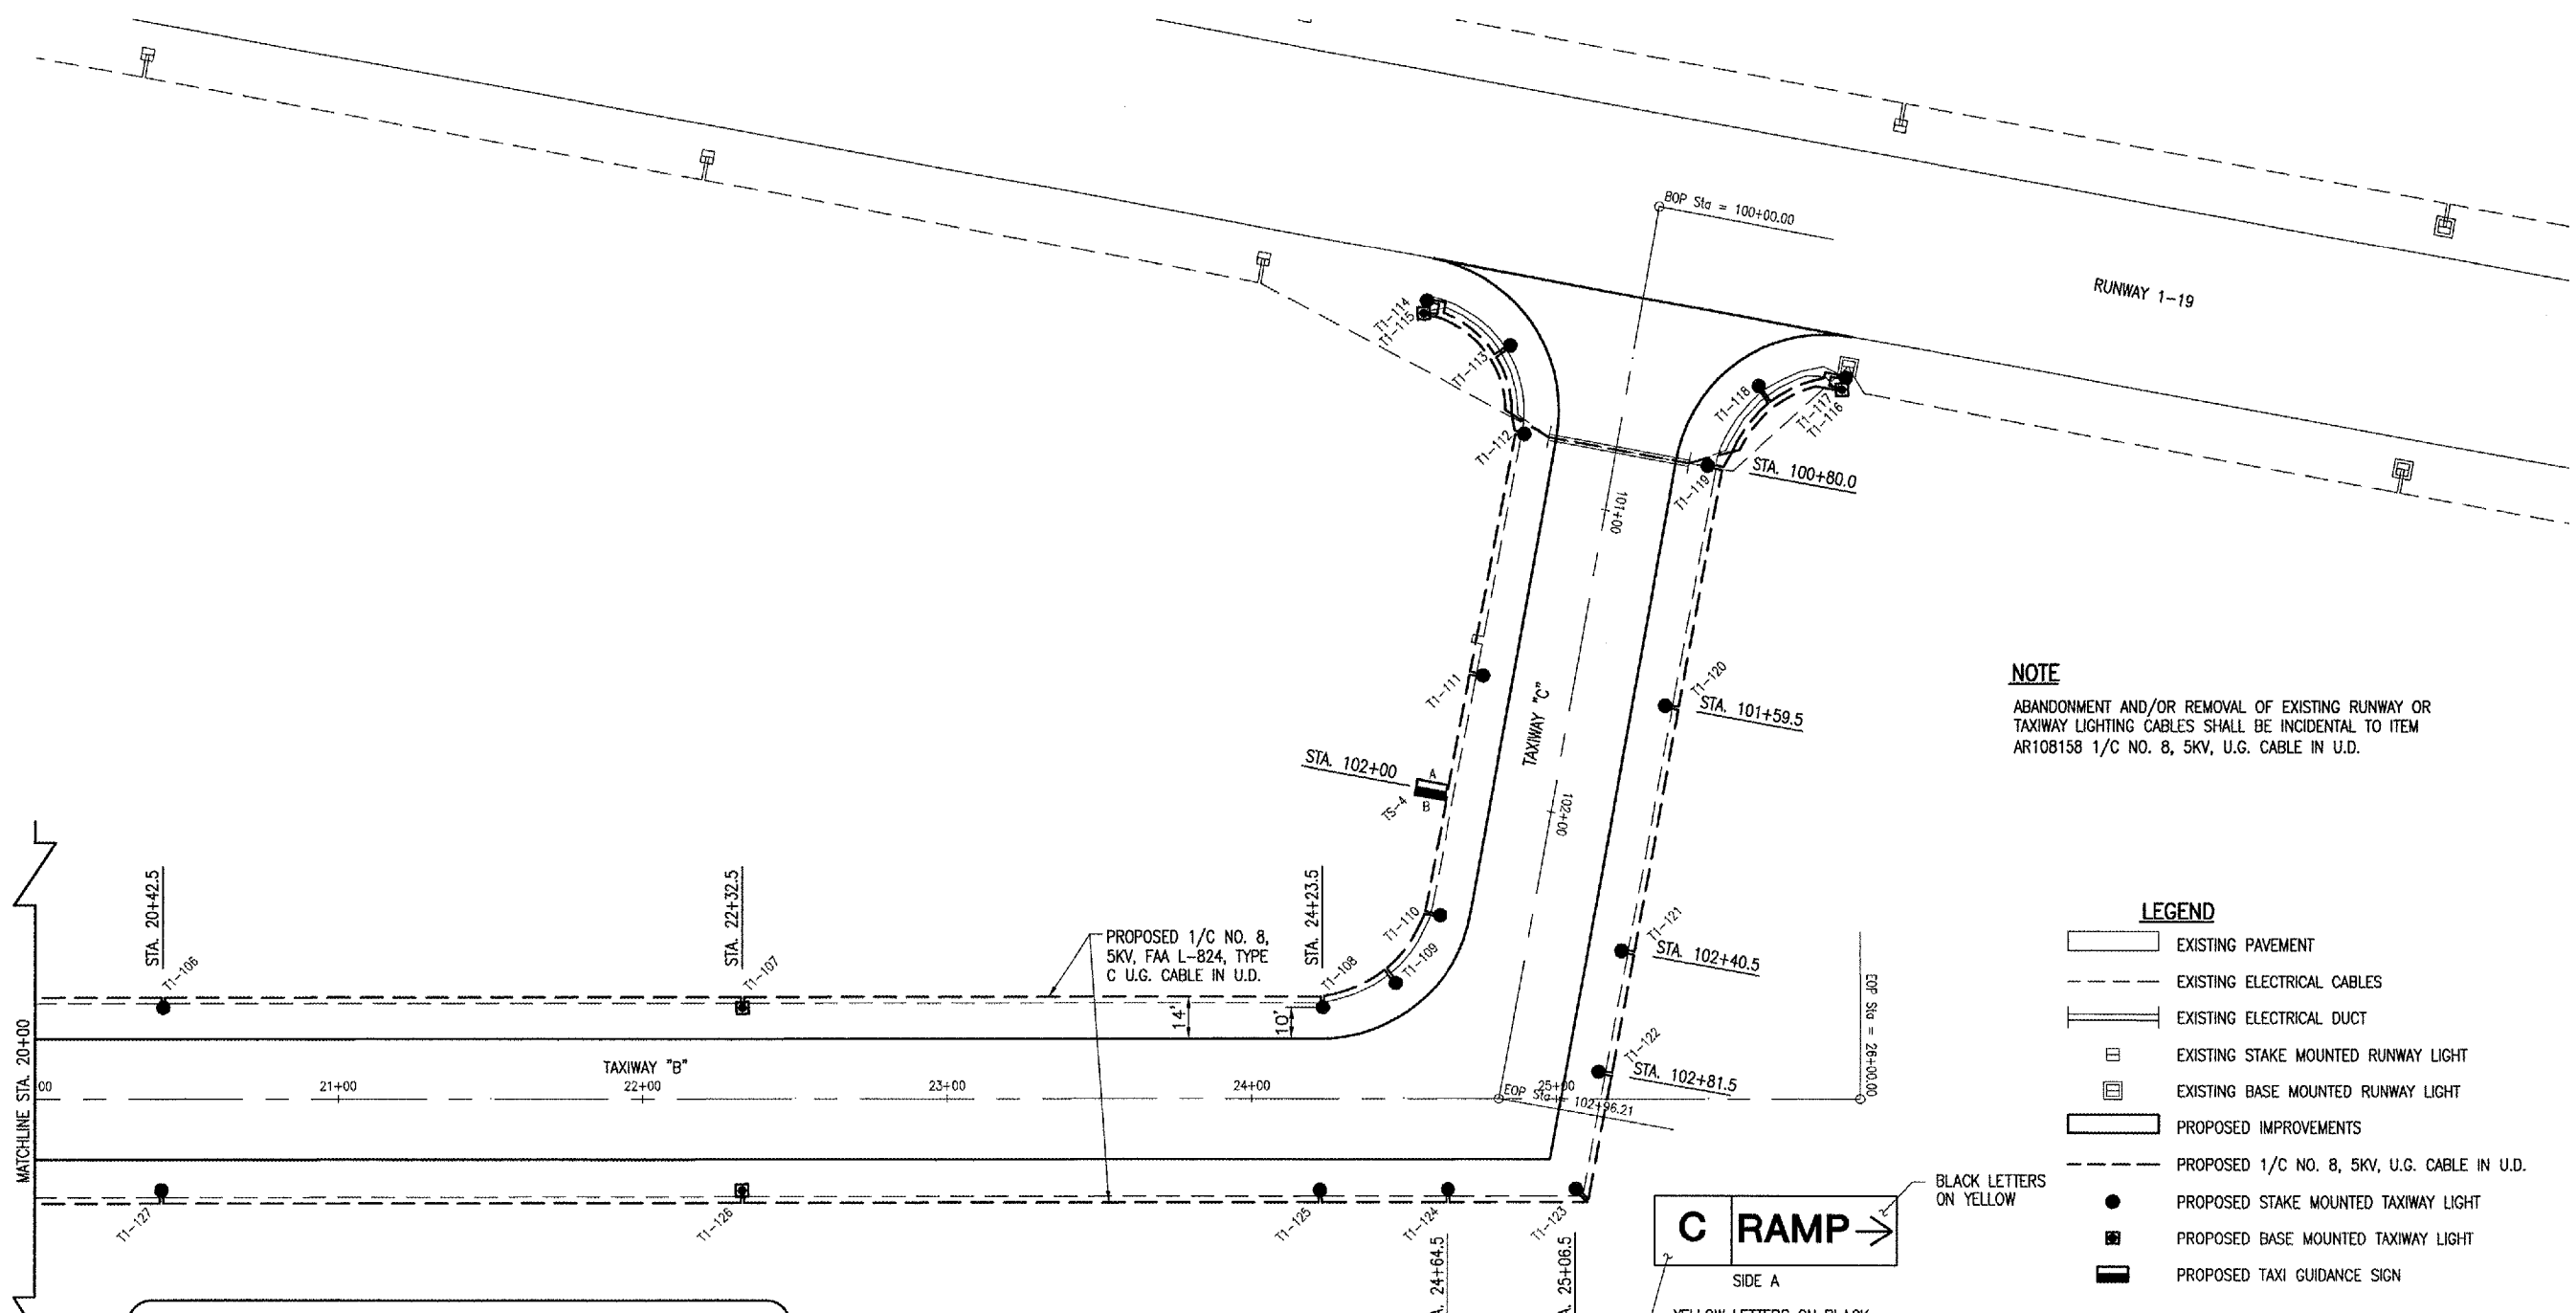


**NOTE**  
 ABANDONMENT AND/OR REMOVAL OF EXISTING RUNWAY OR TAXIWAY LIGHTING CABLES SHALL BE INCIDENTAL TO ITEM AR108158 1/C NO. 8, 5KV, U.G. CABLE IN U.D.

- LEGEND**
- EXISTING PAVEMENT
  - EXISTING ELECTRICAL CABLES
  - EXISTING ELECTRICAL DUCT
  - EXISTING STAKE MOUNTED RUNWAY LIGHT
  - EXISTING BASE MOUNTED RUNWAY LIGHT
  - PROPOSED IMPROVEMENTS
  - PROPOSED 1/C NO. 8, 5KV, U.G. CABLE IN U.D.
  - PROPOSED STAKE MOUNTED TAXIWAY LIGHT
  - PROPOSED BASE MOUNTED TAXIWAY LIGHT
  - PROPOSED TAXI GUIDANCE SIGN

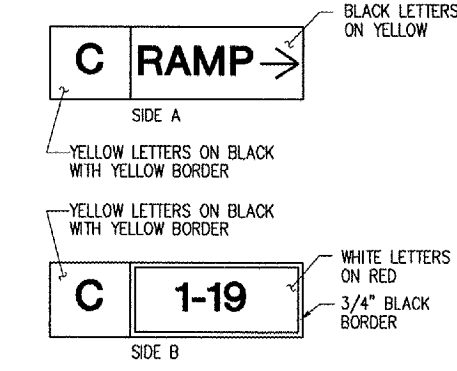

**TAXIWAY GUIDANCE SIGN  
 TS-4 DETAIL**  
 "NOT TO SCALE"

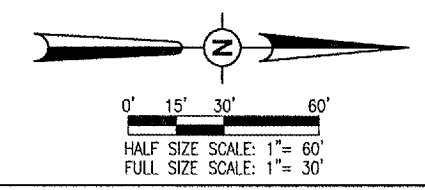

THE LOCATION, SIZE AND TYPE OF MATERIAL OF EXISTING UNDERGROUND UTILITIES INDICATED ON THE PLANS IS NOT REPRESENTED AS BEING ACCURATE, SUFFICIENT OR COMPLETE. IT SHALL BE THE CONTRACTOR'S RESPONSIBILITY TO DETERMINE THE ACTUAL LOCATION OF ALL SUCH FACILITIES, INCLUDING SERVICE CONNECTIONS TO UNDERGROUND UTILITIES. PRIOR TO CONSTRUCTION, THE CONTRACTOR SHALL NOTIFY THE UTILITY COMPANIES OF HIS OPERATIONAL PLANS AND SHALL OBTAIN FROM THE RESPECTIVE UTILITY COMPANIES DETAILED INFORMATION AND ASSISTANCE RELATIVE TO THE LOCATION OF THEIR FACILITIES AND THE WORKING SCHEDULE OF THE COMPANIES FOR REMOVAL OR ADJUSTMENT WHERE REQUIRED. IN THE EVENT AN UNEXPECTED UTILITY INTERFERENCE IS ENCOUNTERED DURING CONSTRUCTION, THE CONTRACTOR SHALL IMMEDIATELY NOTIFY THE UTILITY COMPANY OF JURISDICTION. THE ENGINEER SHALL ALSO BE IMMEDIATELY NOTIFIED. ANY SUCH MAINS AND SERVICES SHALL BE RESTORED TO SERVICE AT ONCE AND PAID FOR BY THE CONTRACTOR AT NO ADDITIONAL COST TO THE CONTRACT.

CALL J.U.L.I.E. FOR UTILITY INFORMATION AT 1-800-892-0123.

DATE	REVISION	BY

**KEWANEE MUNICIPAL AIRPORT  
 KEWANEE, HENRY COUNTY, ILLINOIS**

IL PROJ.: E21-3533 A.I.P. PROJ.: 3-17-0058-810

HE Project No. 810-06TXYD 0800	FILENAME R-142ELE.DWG
Scale 1"=30'	Date 08/02/05
LAYOUT R.A.W. 08/02/05	DRAWN B.A.K. 08/02/05
REVIEWED C.A.H.	xx/xx/xx

**HANSON**  
 Hanson Professional Services Inc.  
 3125 Dandy Trail, Suite 100  
 Indianapolis, Indiana 46214  
 Offices Nationwide

**OVERLAY TXY & APRON  
 CONSTRUCT VAULT**

PROPOSED  
 ELECTRICAL PLAN

STA. 20+00 TO STA. 26+00