

FAI RTE.	SECTION	COUNTY	TOTAL SHEETS	SHEET NO.
90	1314B	COOK	160	27
FED. ROAD DIST. NO.	ILLINOIS FED. AID PROJECT		CONTRACT 60293	

**NOTE:**

ALL DRAINAGE STRUCTURES WITHIN PAVEMENT AREAS SHALL BE ADJUSTED AS FRAMES AND LIDS TO BE ADJUSTED (SPECIAL).


WHEN CARRYING OUT THE ADJUSTMENTS (SPECIAL), PLATING THE DRAINAGE STRUCTURES WILL NOT BE PERMITTED IN THE CITY OF CHICAGO, SEE GENERAL NOTES FOR MORE INFORMATION.

ALL DRAINAGE STRUCTURES ARE TO BE CLEANED UPON COMPLETION OF THE RESURFACING OPERATIONS.

THE DRAINAGE STRUCTURES TO BE CLEANED PAY ITEM IS ONLY APPLICABLE TO STRUCTURES WHICH HAVE NOT BEEN ADJUSTED/RECONSTRUCTED AND WHICH ARE NOT IMPACTED BY THE PROPOSED IMPROVEMENT.

TWO (2) FIRE HYDRANTS AND SEVENTEEN (17) WATER SERVICE BOXES ARE TO BE RELOCATED BY THE CITY OF CHICAGO WATER DEPARTMENT. THE CONTRACTOR SHALL CONTACT THE CITY OF CHICAGO WATER DEPARTMENT AT (312) 744-5941.

FOR TREATMENT OF CITY ELECTRIC MANHOLES, SEE TRAFFIC SIGNAL AND LIGHTING PLANS.

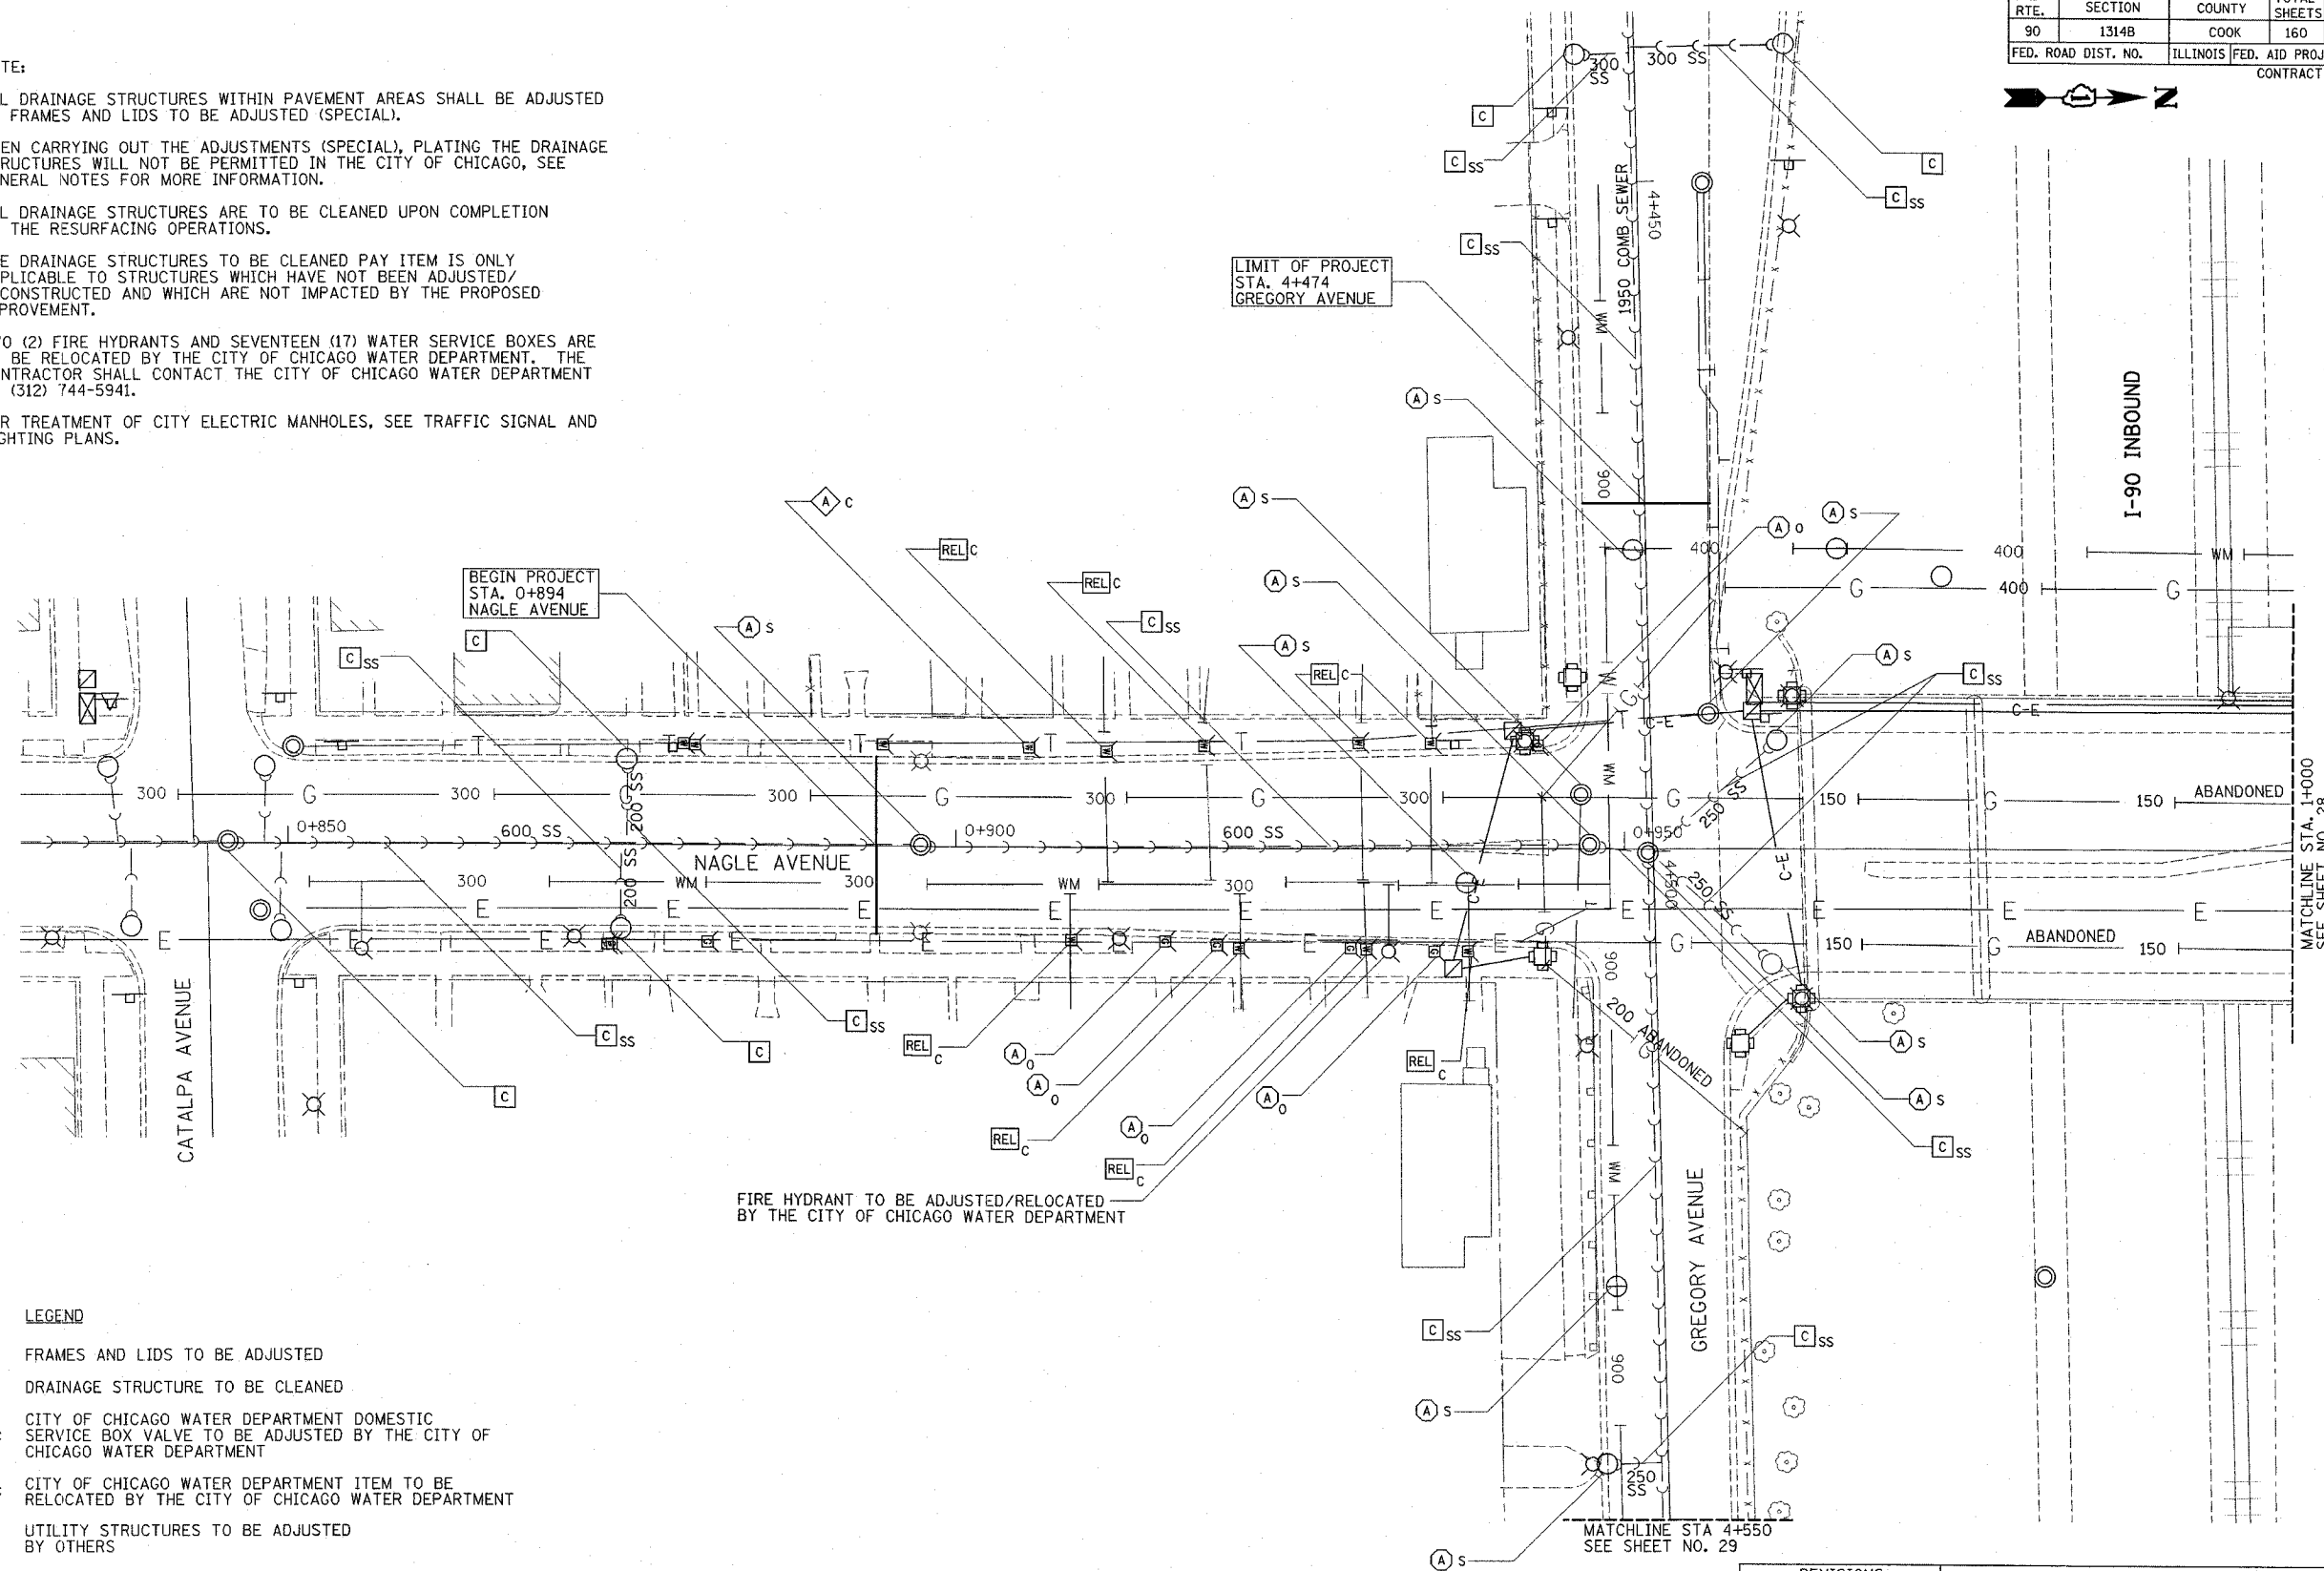

**LEGEND**

- (A) FRAMES AND LIDS TO BE ADJUSTED
- (C) DRAINAGE STRUCTURE TO BE CLEANED
- (A<sub>C</sub>) CITY OF CHICAGO WATER DEPARTMENT DOMESTIC SERVICE BOX VALVE TO BE ADJUSTED BY THE CITY OF CHICAGO WATER DEPARTMENT
- (REL C) CITY OF CHICAGO WATER DEPARTMENT ITEM TO BE RELOCATED BY THE CITY OF CHICAGO WATER DEPARTMENT
- (A<sub>O</sub>) UTILITY STRUCTURES TO BE ADJUSTED BY OTHERS
- (A<sub>S</sub>) FRAMES AND LIDS TO BE ADJUSTED (SPECIAL)
- (C<sub>SS</sub>) STORM SEWER TO BE CLEANED



**COLLINS ENGINEERS INC.**  
123 N. WACKER DR., SUITE 300  
CHICAGO, IL 60606  
(312) 704-9300  
ILLINOIS PROFESSIONAL DESIGN FIRM  
LICENSE NO. 184-006953

REVISIONS	
NAME	DATE

ILLINOIS DEPARTMENT OF TRANSPORTATION

EXISTING DRAINAGE AND UTILITIES PLAN

NAGLE AVENUE  
STA. 0+830 TO STA. 1+000

DATE: DECEMBER 2004

DRAWN BY: ML, DR, FD  
CHECKED BY: JMH, MDK