


F.A. RTE.	SECTION	COUNTY	TOTAL SHEETS	SHEET NO.
337	19R-1	LAKE	800	524
STA.	TO STA.			
FED. ROAD DIST. NO.	ILLINOIS	FED. AID PROJECT		
CONTRACT NO. 60997				

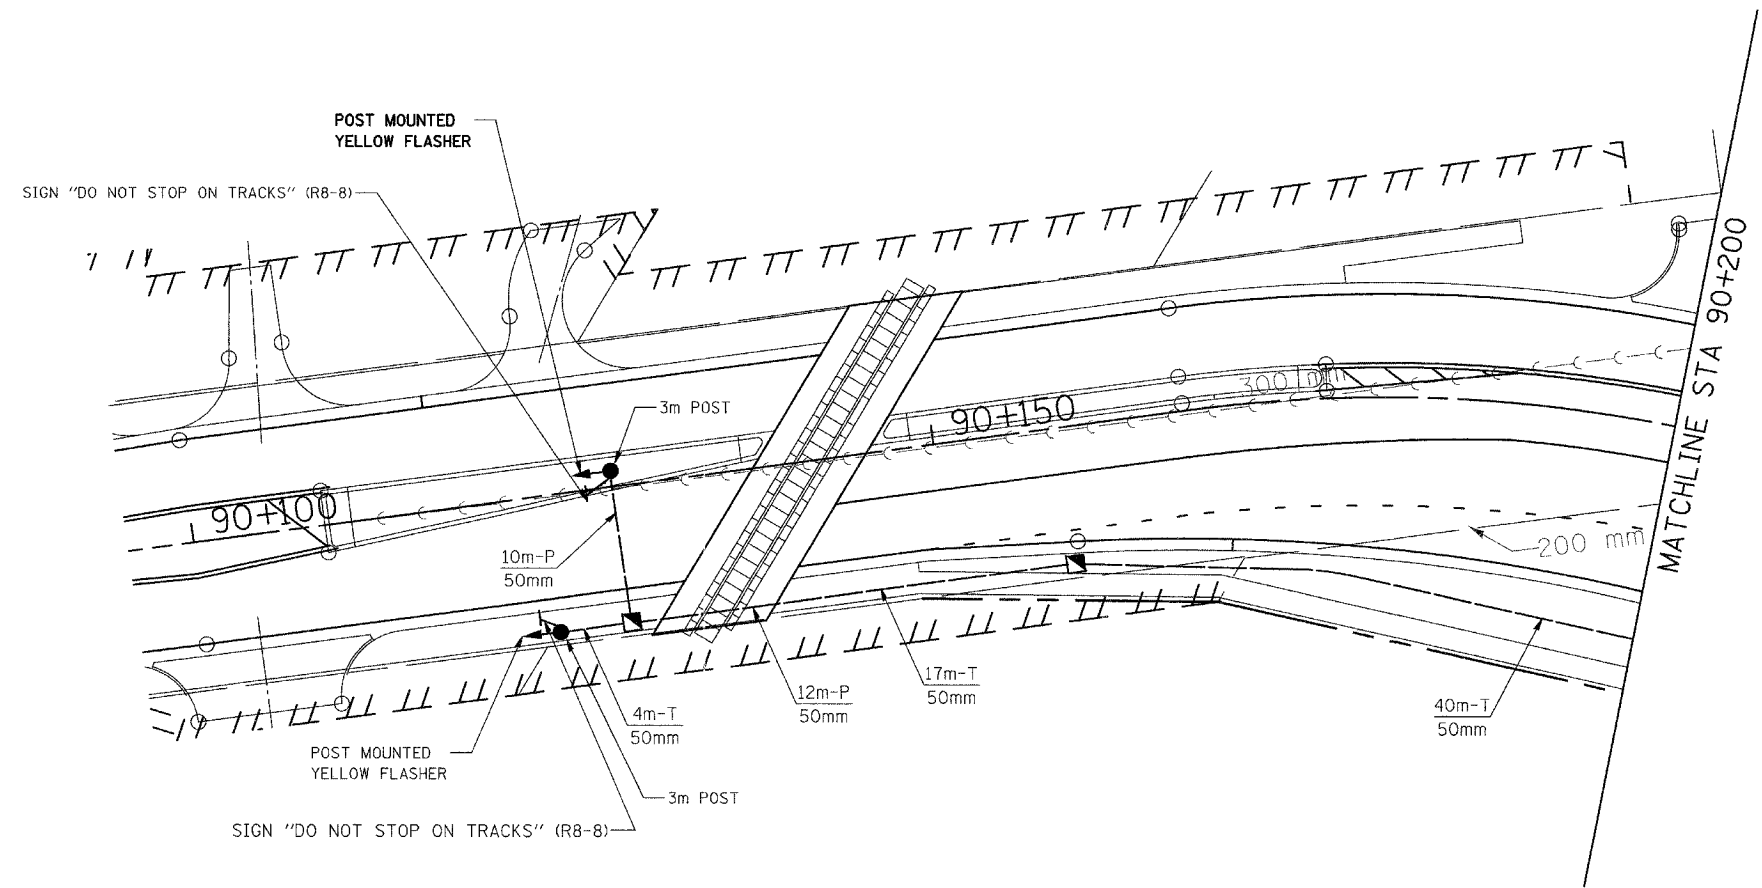

SEQUENCE OF OPERATION

EASTBOUND MAIN PHASE INDICATION	GREEN	YELLOW	RED	FLASH
FLASHER INDICATION	DARK	FLASH YELLOW	FLASH YELLOW	FLASH YELLOW

REVISIONS	
NAME	DATE

ILLINOIS DEPARTMENT OF TRANSPORTATION
 TRAFFIC SIGNAL INSTALLATION PLAN
 IL RTE 22 & MAIN STREET EAST

SCALE : 1:250
 DATE : 03/25/04

DRAWN BY VAP
 DESIGNED BY RAM
 CHECKED BY DDL