


SECTION	COUNTY	TOTAL SHEETS	SHEET NO.
2003-0311	COOK	976	841
STA.	TO STA.		
62583	62583		
FED. ROAD DIST. NO.	ILLINOIS	FED. AID PROJECT	

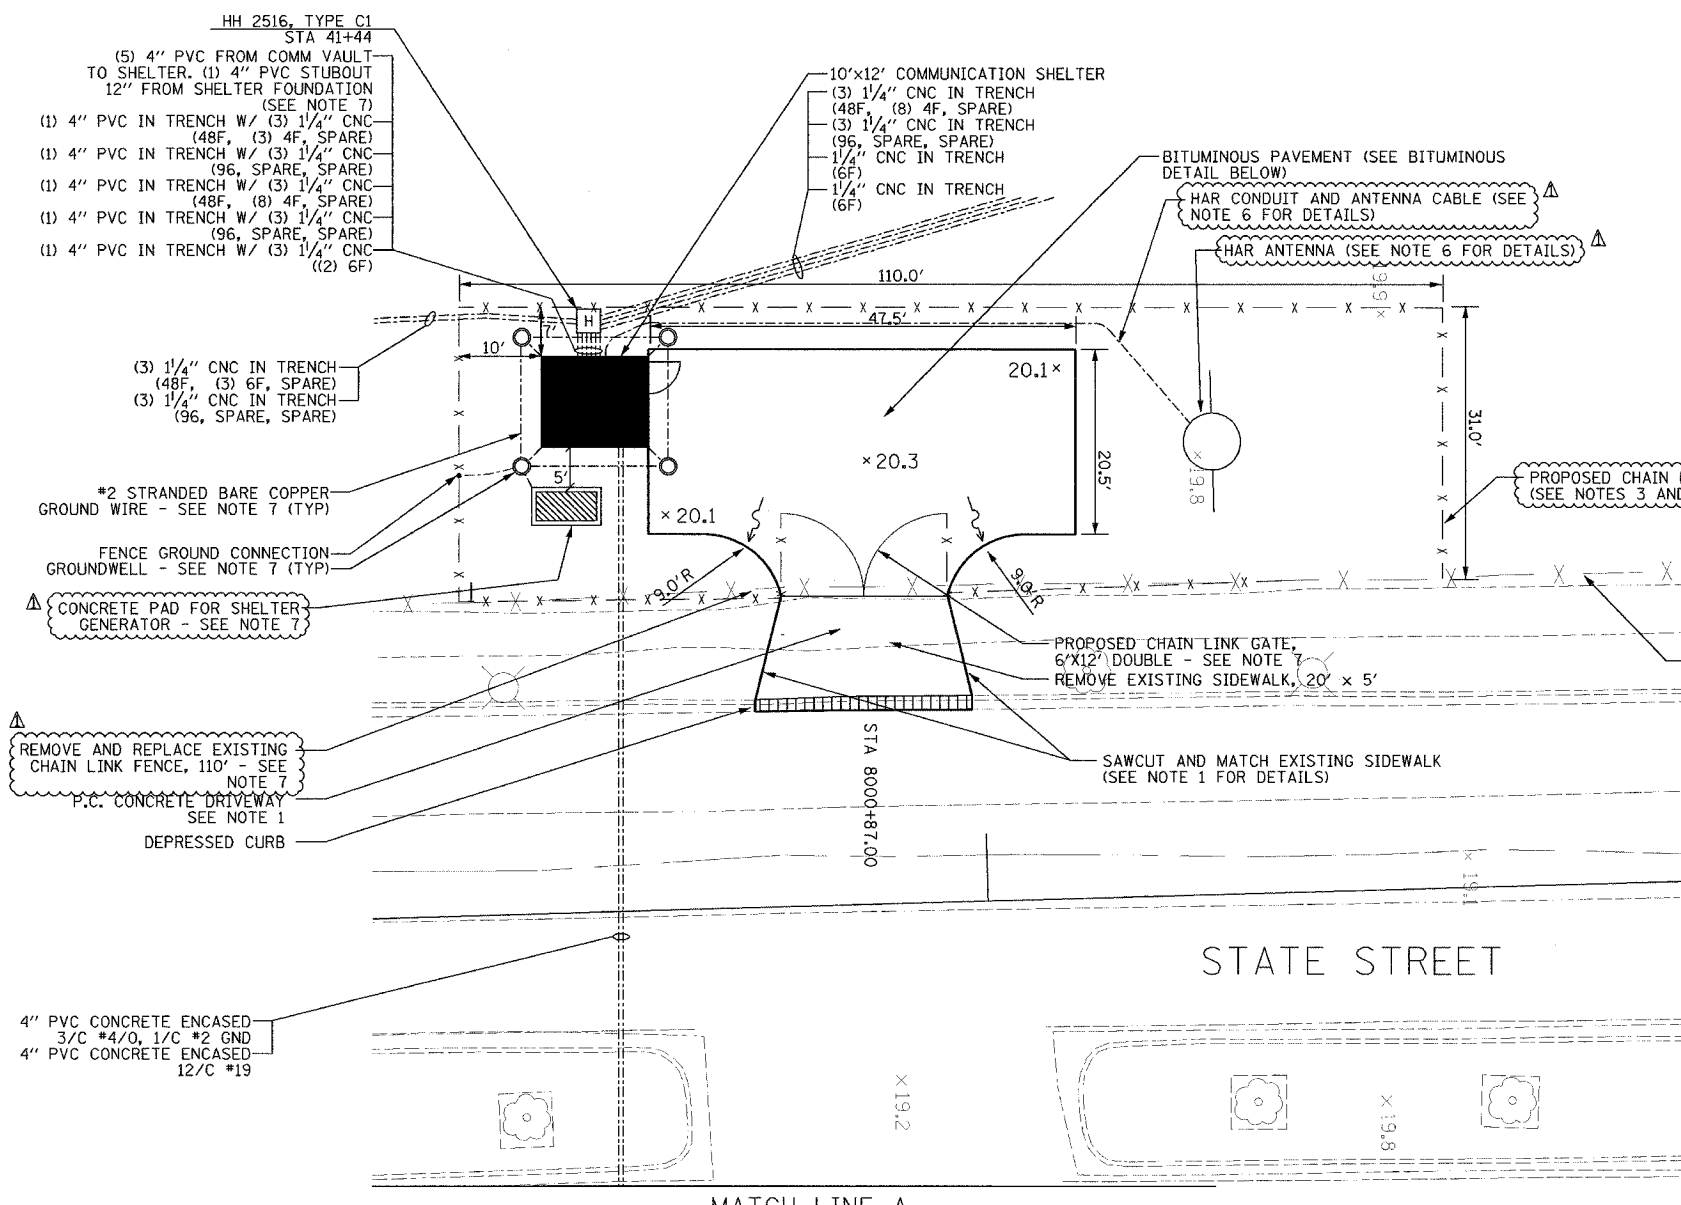

4" PVC CONCRETE ENCASED  
3/C #4/0, 1/C #2 GND  
4" PVC CONCRETE ENCASED  
12/C #19

MATCH LINE A  
STATE STREET

4" PVC CONCRETE ENCASED  
3/C #4/0, 1/C #2 GND  
4" PVC CONCRETE ENCASED  
12/C #19

HH 7302, TYPE S1

HH 7301, TYPE S1

PROPOSED CHAIN LINK FENCE  
(SEE NOTES 3 AND 7)

EXISTING CHAIN LINK FENCE

PROPOSED CHAIN LINK GATE,  
6'X12' DOUBLE - SEE NOTE 7  
REMOVE EXISTING SIDEWALK, 20' X 5'

SAWCUT AND MATCH EXISTING SIDEWALK  
(SEE NOTE 1 FOR DETAILS)

 
STATE STREET

4" PVC CONCRETE ENCASED  
3/C #4/0, 1/C #2 GND  
4" PVC CONCRETE ENCASED  
12/C #19

4" PVC CONCRETE ENCASED  
3/C #4/0, 1/C #2 GND  
4" PVC CONCRETE ENCASED  
12/C #19


EXISTING COMED UTILITY POLE

ELECTRIC UTILITY SERVICE CONNECTION  
ELECTRIC SERVICE INSTALLATION, 200A, 120/240V  
(SEE SHEET COMM-77 & ESD-01 FOR DETAILS)  
UNDERGROUND TELEPHONE SERVICE INSTALLATION



COMM-75

 BITUMINOUS PAVEMENT DETAIL



LEGEND

- × 20.50 EXISTING GRADES
- × 20.50 PROPOSED GRADES

NOTES:

1. FOR P.C. CONCRETE DRIVEWAY, REFER TO CDOT DETAIL SHEET BD17.
2. CENTERLINE OF PROPOSED DRIVEWAY TO ALIGN WITH CENTER LINE OF 66TH PLACE.
3. FOR COMMUNICATIONS SHELTER DETAILS, REFER TO SHEETS COMM-91 THRU COMM-94.
4. CONTRACTOR IS RESPONSIBLE FOR IDENTIFYING AND RELOCATING ALL EXISTING UNDERGROUND UTILITIES AS NECESSARY TO CONSTRUCT COMMUNICATIONS SHELTER.
5. FOR ELECTRIC SERVICE INSTALLATION DETAILS, SEE ESD-01.
6. FOR HIGHWAY ADVISOR RADIO TRANSMITTER PLANS, SEE SHEETS HAR-01 THRU HAR-03.
7. DESIGNATED WORK/MATERIALS TO BE PAID FOR AS PART OF SHELTER.
8. PAVEMENT AND SIDEWALK REPLACEMENT SHALL BE CONSIDERED INCLUDED IN THE COST OF THE CONCRETE ENCASED CONDUIT INSTALLATION.
9. ALL WORK ASSOCIATED WITH THE INSTALLATION OF THE SHELTER UTILITY SERVICE FEED MUST BE COORDINATED WITH AND APPROVED BY COMED.
10. ALL MATERIALS AND LABOR FOR THE INSTALLATION OF THE CONCRETE ENCASED DUCTBANK FOR UTILITY SERVICE FEED MUST MEET ALL COMED REQUIREMENTS AND STANDARDS.

REVISIONS	
NAME	DATE
REVISION 1	12/17/04
REVISION	2/11/05

ILLINOIS DEPARTMENT OF TRANSPORTATION  
F.A.I. 94/90 (DAN RYAN EXPRESSWAY)  
31st STREET to I-57

EAST SHELTER (R03)  
SITE PLAN

SCALE: 1"=10'  
DATE: October 29, 2004  
DRAWN BY: DHI  
CHECKED BY: MJL

**Edwards AND Kelcey**  
ONE NORTH FRANKLIN  
CHICAGO, IL 60606  
PHONE: (312) 251-3000  
FAX: (312) 251-3015  
WEB: WWW.EDKORP.COM

02/09/2005 03:42:10 PM