


|                     |           |                  |              |           |
|---------------------|-----------|------------------|--------------|-----------|
| F.A.I. RTE.         | SECTION   | COUNTY           | TOTAL SHEETS | SHEET NO. |
| 94/90               | 2003-0311 | COOK             | 976          | 116       |
| STA. 1596+00        |           | TO STA. 1608+00  |              |           |
| FED. ROAD DIST. NO. | ILLINOIS  | FED. AID PROJECT |              |           |
| 62583               |           |                  |              |           |

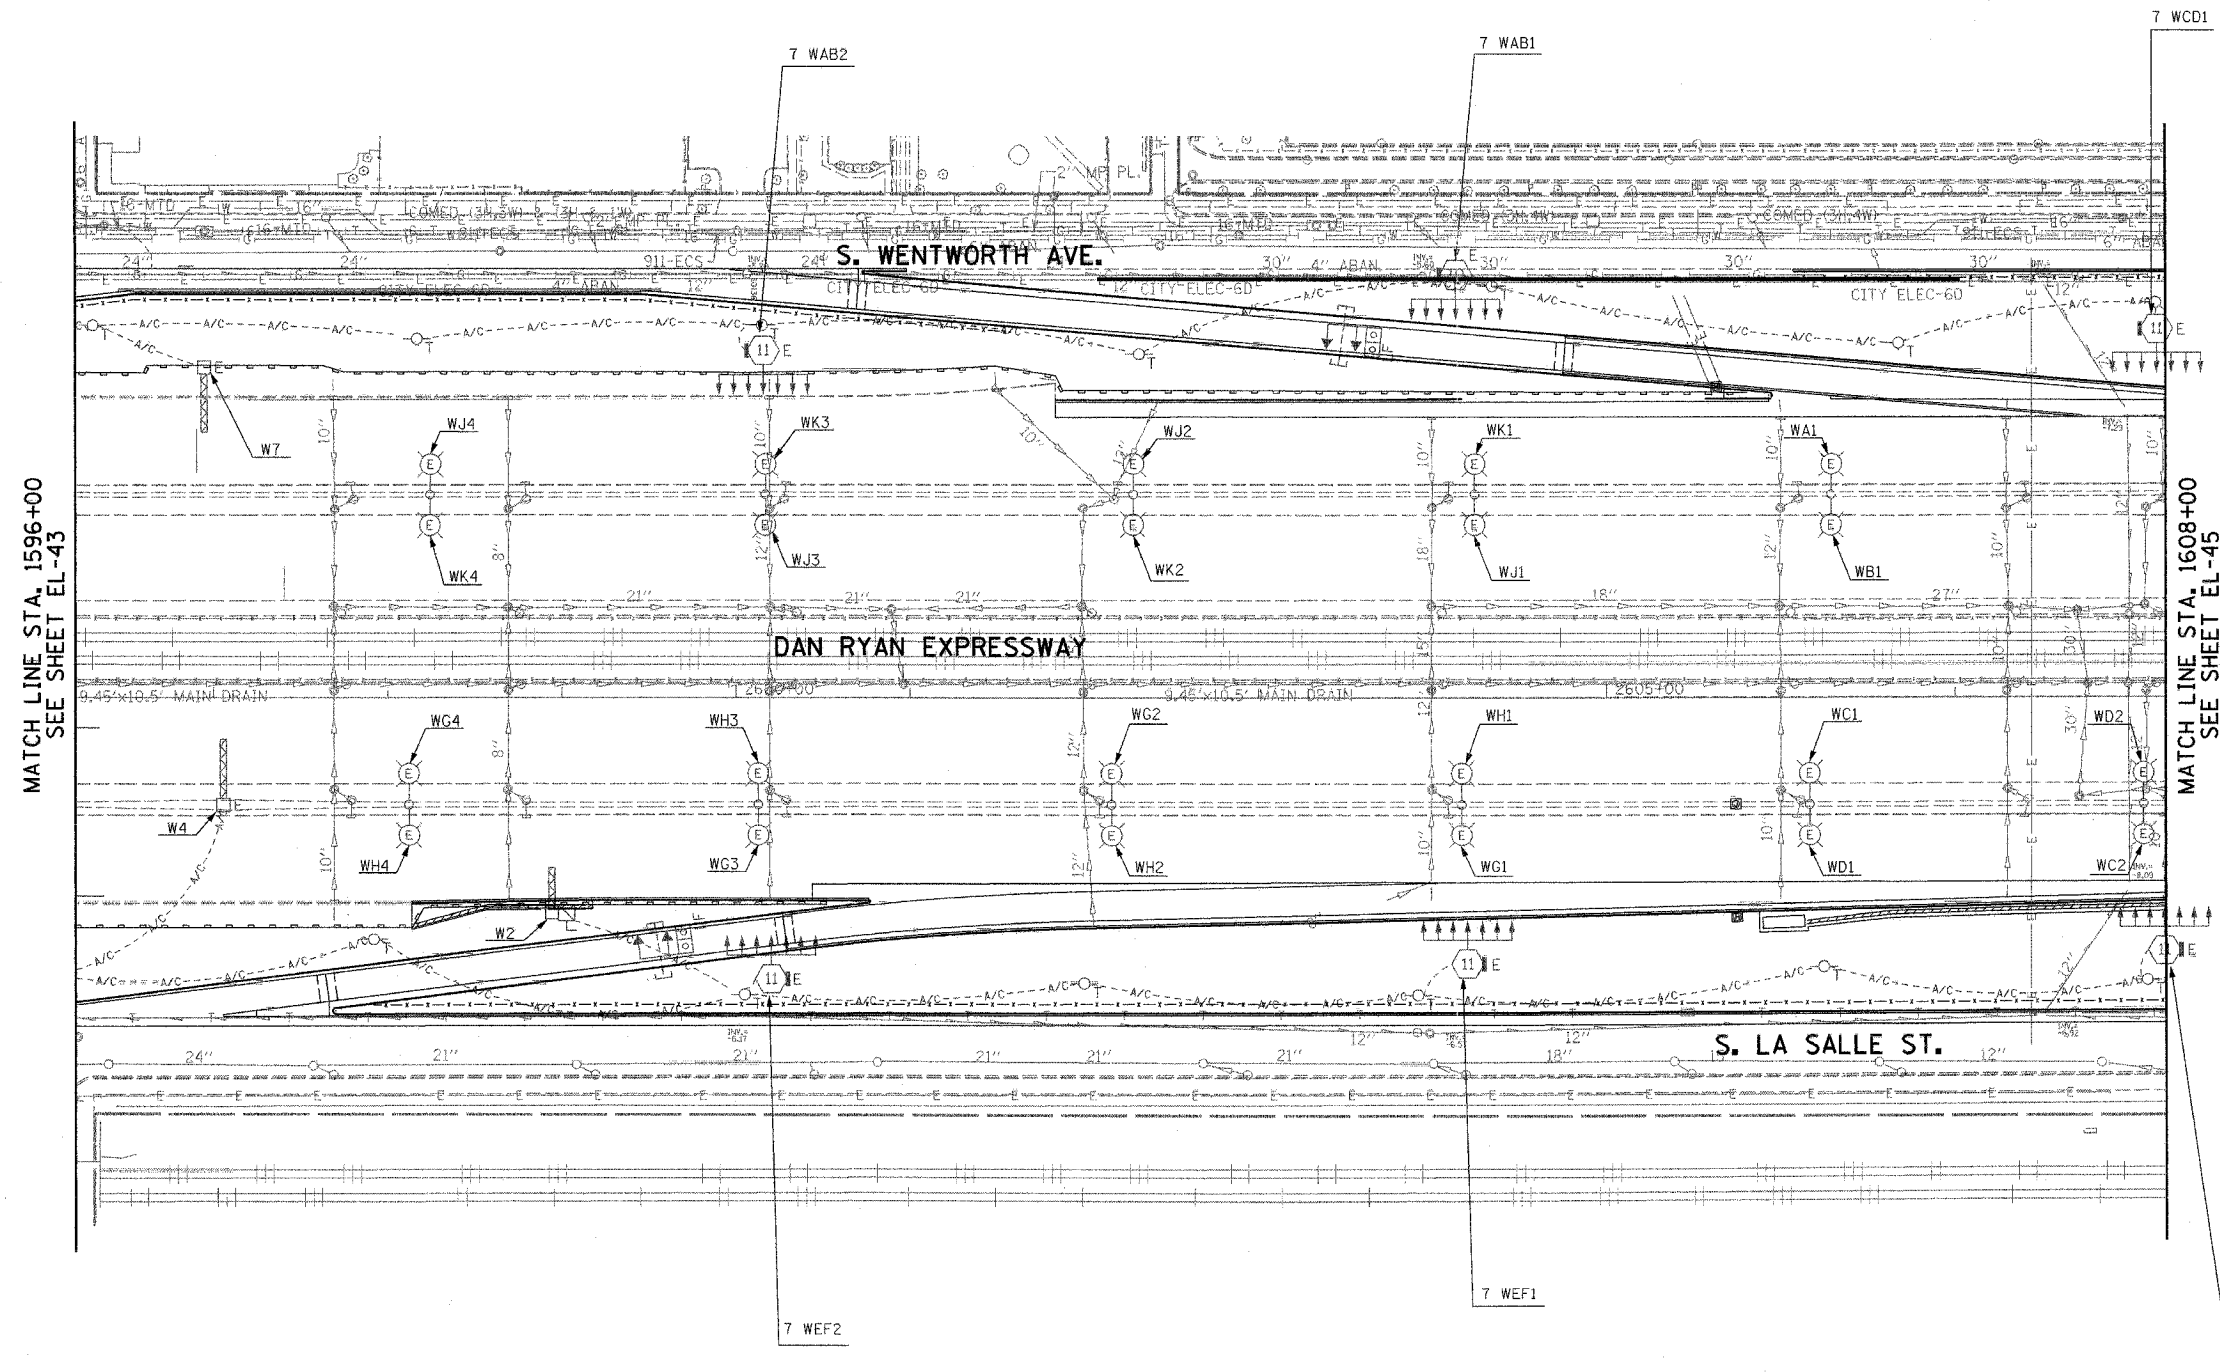

 
**NOTES:**  
 1. SEE DRAWINGS ME-01 AND ME-02 FOR ELECTRICAL SYMBOLS, AND ABBREVIATIONS.

MATCH LINE STA. 1596+00  
SEE SHEET EL-43

MATCH LINE STA. 1608+00  
SEE SHEET EL-45

EL-44

**K&E** KAM ENGINEERING, INC.  
 CONSULTING ENGINEERS  
 707A Davis Road, Suite 205  
 Elgin, Illinois 60123-1369



| REVISIONS |      |
|-----------|------|
| NAME      | DATE |
|           |      |
|           |      |
ILLINOIS DEPARTMENT OF TRANSPORTATION  
 F.A.I. 94/90 (DAN RYAN EXPRESSWAY)  
 31st STREET TO I-57

**ROADWAY LIGHTING PLANS  
 EXISTING CONDITIONS AND DEMOLITION**

SCALE: 1"=50'  
 DATE: OCTOBER 29, 2004

DRAWN BY: BL  
 CHECKED BY: SM

C:\projects\94\_329\SH\Lighting\EL2044.dwg 10/15/2004 09:22:20 AM