


F.A.I. RTE.	SECTION	COUNTY	TOTAL SHEETS	SHEET NO.
90/94	2003-0311	COOK	976	122
STA. 103+00		TO STA. 116+00		
FED. ROAD DIST. NO.	ILLINOIS FED. AID PROJECT		62583	

 
NOTES:  
 1. SEE DRAWINGS ME-01 AND ME-02 FOR ELECTRICAL SYMBOLS AND ABBREVIATIONS.

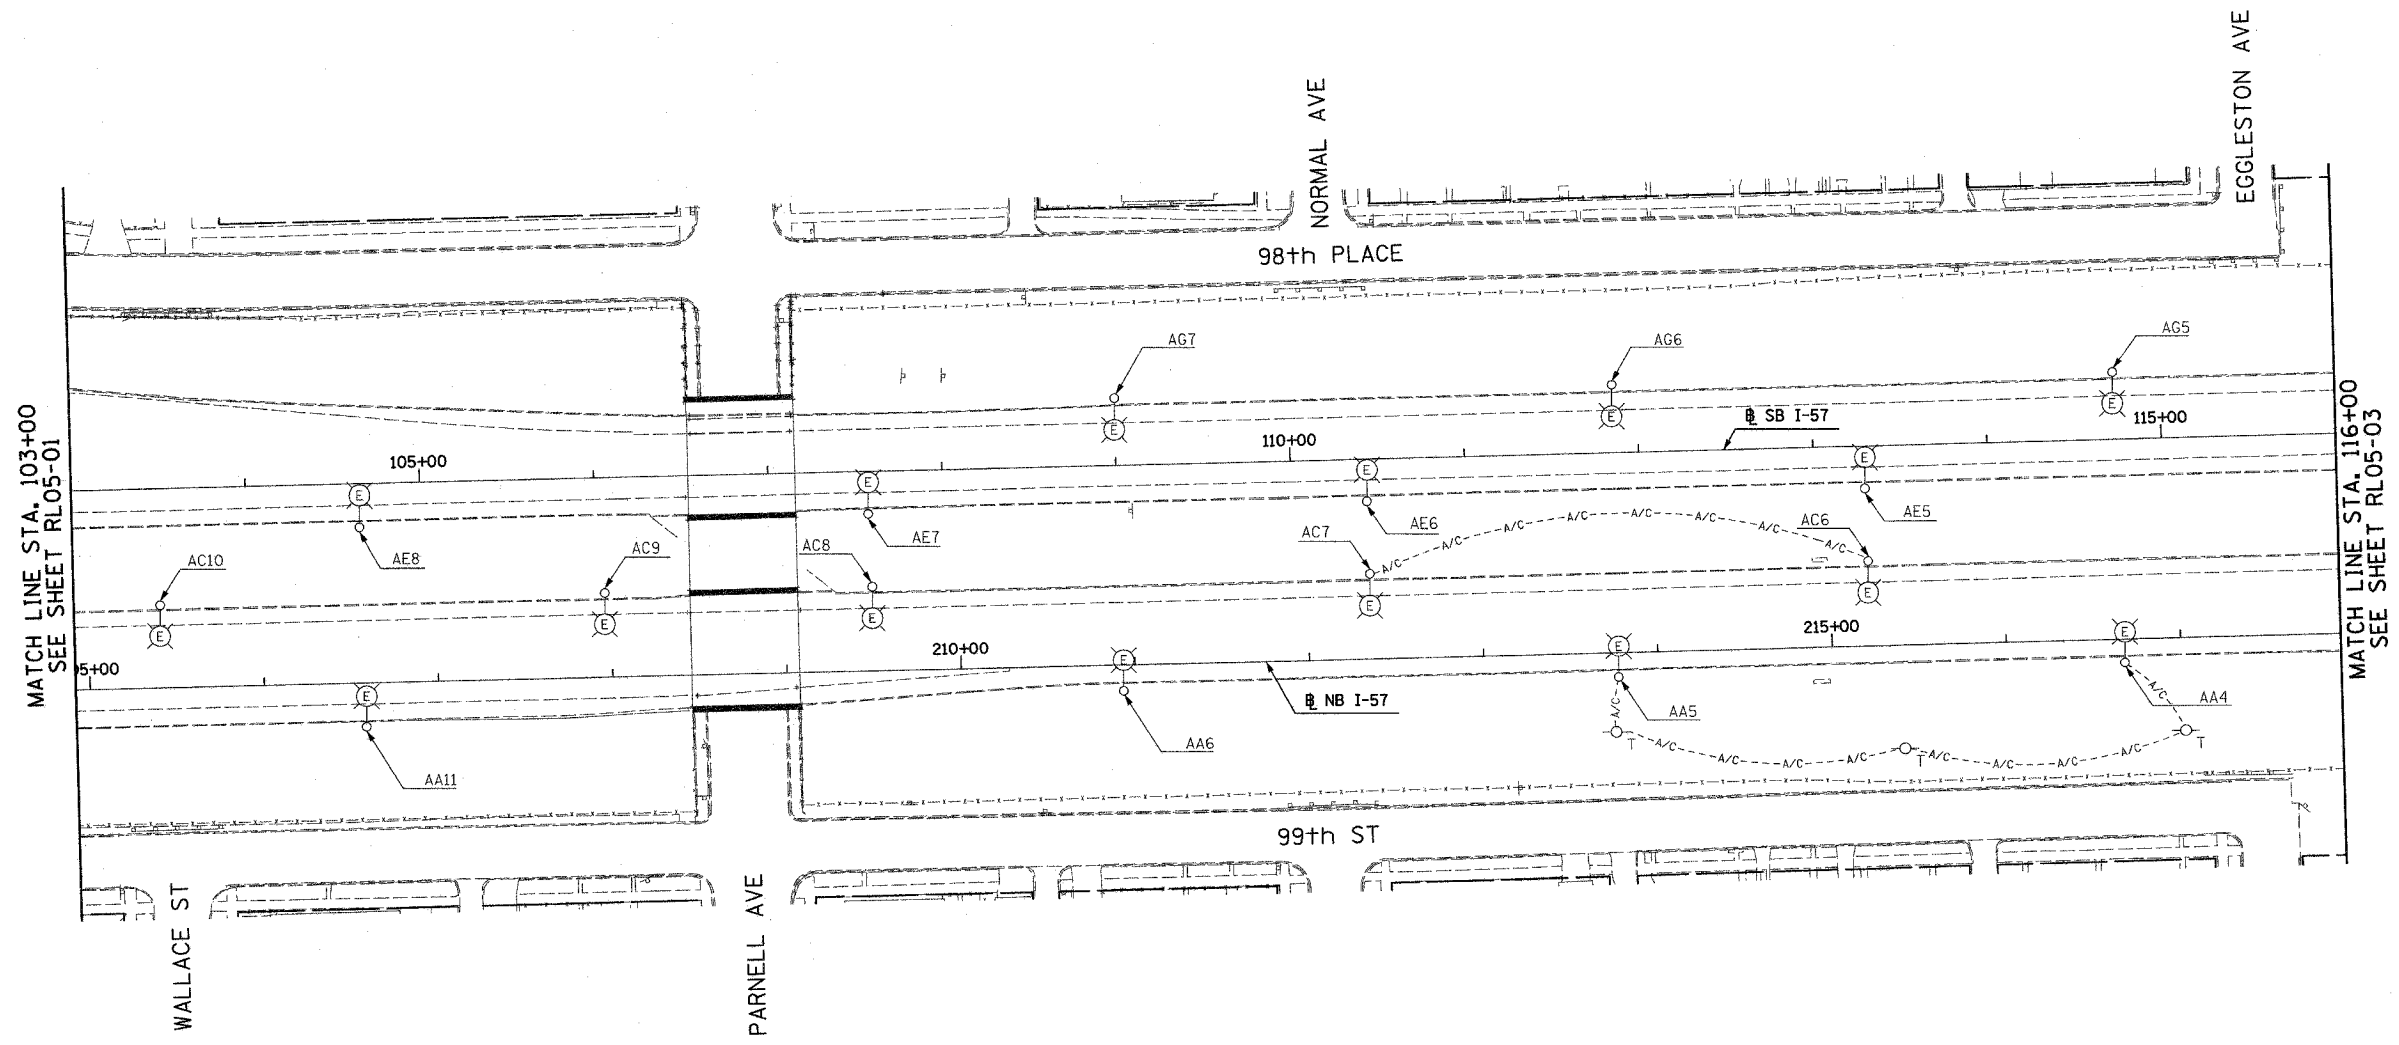

MATCH LINE STA. 103+00  
SEE SHEET RL05-01

MATCH LINE STA. 116+00  
SEE SHEET RL05-03

NO ELECTRICAL WORK THIS SHEET  
FOR REFERENCE ONLY



RL05-02

REVISIONS	
NAME	DATE

ILLINOIS DEPARTMENT OF TRANSPORTATION  
 F.A.I. 90/94 (DAN RYAN EXPRESSWAY)  
 31st STREET TO I-57  
 ROADWAY LIGHTING PLANS  
 PROPOSED IMPROVEMENTS 2005

SCALE: 1"=50'  
 DATE: OCTOBER 29, 2004

DRAWN BY: VRK  
 CHECKED BY: TM

**SINGH** 300 W. ADAMS ST.  
 CHICAGO, IL 60606  
 SINGH & ASSOCIATES, INC. TEL: (312) 629-0240  
 CONSULTING ENGINEERS FAX: (312) 629-8449

10/14/2004 9:40:29 AM