

 

F.A.I. RTE.	SECTION	COUNTY	TOTAL SHEETS	SHEET NO.
90/94	2003-0311	COOK	976	142
STA. 1360+00		TO STA. 1366+00		
FED. ROAD DIST. NO.	ILLINOIS	FED. AID PROJECT		

62583



**NOTES:**

1. SEE DRAWINGS ME-01 AND ME-02 FOR ELECTRICAL SYMBOLS AND ABBREVIATIONS.
2. UNLESS NOTED OTHERWISE, ALL ITEMS AND WORK SHOWN IN HEAVY LINE WEIGHT ON THIS DRAWING ARE PROPOSED NEW ITEMS OF WORK.
3. SEE SHEET ES-03 FOR HIGH MAST LIGHT TOWER SCHEDULE.
4. THE EXISTING ROADWAY LIGHTING SYSTEM SHALL REMAIN IN OPERATION UNTIL THE PROPOSED ROADWAY LIGHTING SYSTEM HAS BEEN INSTALLED, ENERGIZED, TESTED, AND ACCEPTED BY THE ENGINEER, UNLESS OTHERWISE DIRECTED BY THE ENGINEER.
5. AERIAL CABLE AND TEMPORARY WOOD POLES SHALL BE REMOVED AFTER HIGH MAST LIGHT TOWERS ARE PERMANENTLY WIRED AND ACCEPTED BY THE ENGINEER.
6. TEMPORARY WOOD POLES SHALL BE INSERTED IN GROUND TO ACCOMMODATE PROPOSED GRADING.
7. REFER TO SHEET ME-25 FOR TEMPORARY WIRING TO TOWER DETAIL.
8. CONTRACTOR TO COORDINATE RELOCATION OF LIGHTING CONTROLLER "R" WITH CIVIL CONTRACT 62694 OR AS DIRECTED BY THE ENGINEER. CONTRACTOR TO PROVIDE TEMPORARY CONCRETE FOUNDATION FOR LIGHTING CONTROLLER.
9. REFER DETAIL ME-25B.
10. CONTRACTOR TO COORDINATE WITH COMED TO PROVIDE TEMPORARY ELECTRICAL SERVICE TO LIGHTING CONTROLLER "R". COORDINATE INSTALLATION WITH CIVIL CONTRACT 62694 OR AS DIRECTED BY THE ENGINEER.

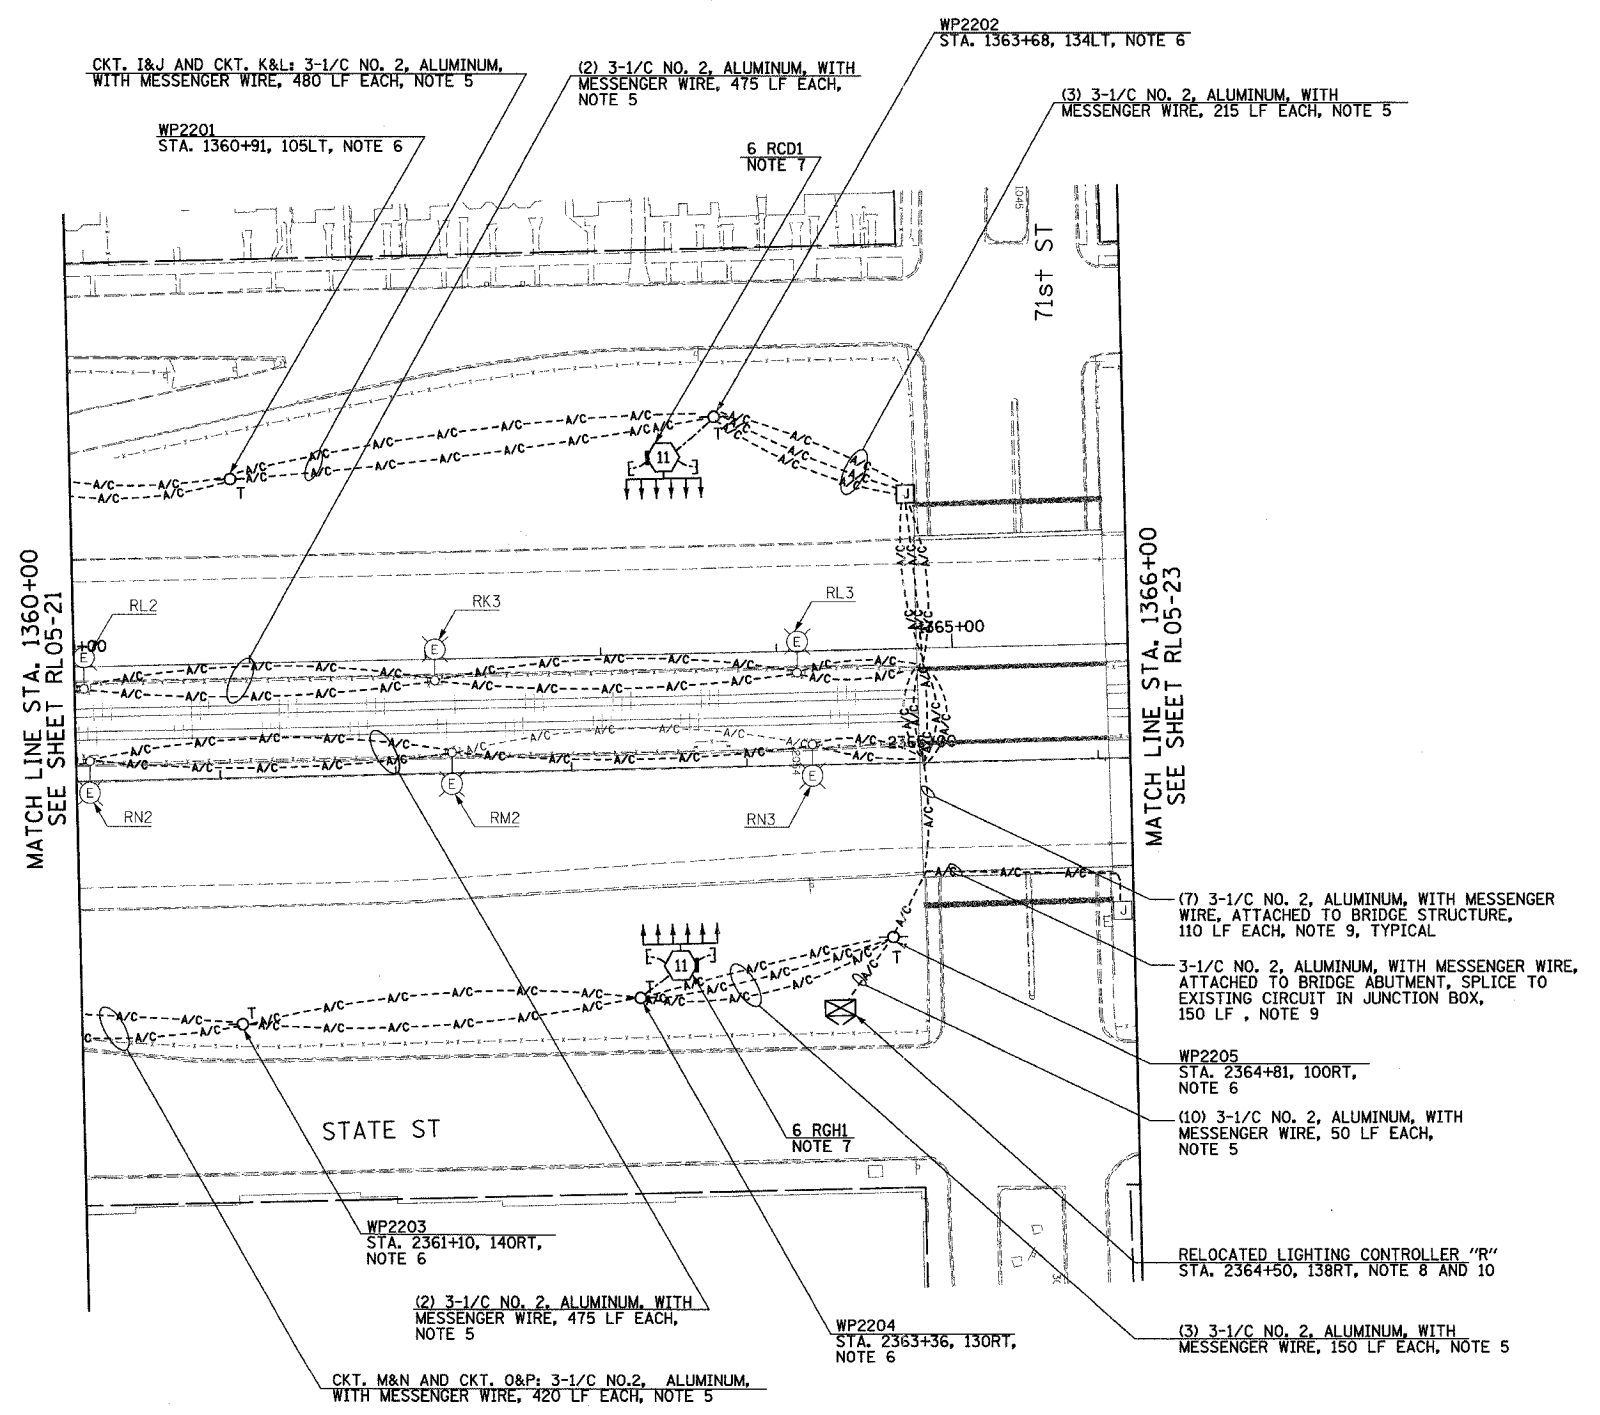

RL05-22

REVISIONS		ILLINOIS DEPARTMENT OF TRANSPORTATION	
NAME	DATE	F.A.I. 90/94 (DAN RYAN EXPRESSWAY)	
		31st STREET TO I-57	
		ROADWAY LIGHTING PLANS	
		PROPOSED IMPROVEMENTS 2005	
		SCALE: 1"=50'	DRAWN BY: VRK
		DATE: OCTOBER 29, 2004	CHECKED BY: TM
REVISED	01/21/05		

**SINGH** 300 W. ADAMS ST.  
CHICAGO, IL 60606  
SINGH & ASSOCIATES, INC. TEL: (312) 629-0240  
CONSULTING ENGINEERS FAX: (312) 629-8449

1/25/2005 12:23:51 PM