


|                     |                 |                  |              |           |
|---------------------|-----------------|------------------|--------------|-----------|
| F.A.I. RTE.         | SECTION         | COUNTY           | TOTAL SHEETS | SHEET NO. |
| 94/90               | 2003-0311       | COOK             | 976          | 250       |
| STA. 1572+00        | TO STA. 1584+00 |                  |              |           |
| FED. ROAD DIST. NO. | ILLINOIS        | FED. AID PROJECT |              |           |
| 62583               |                 |                  |              |           |

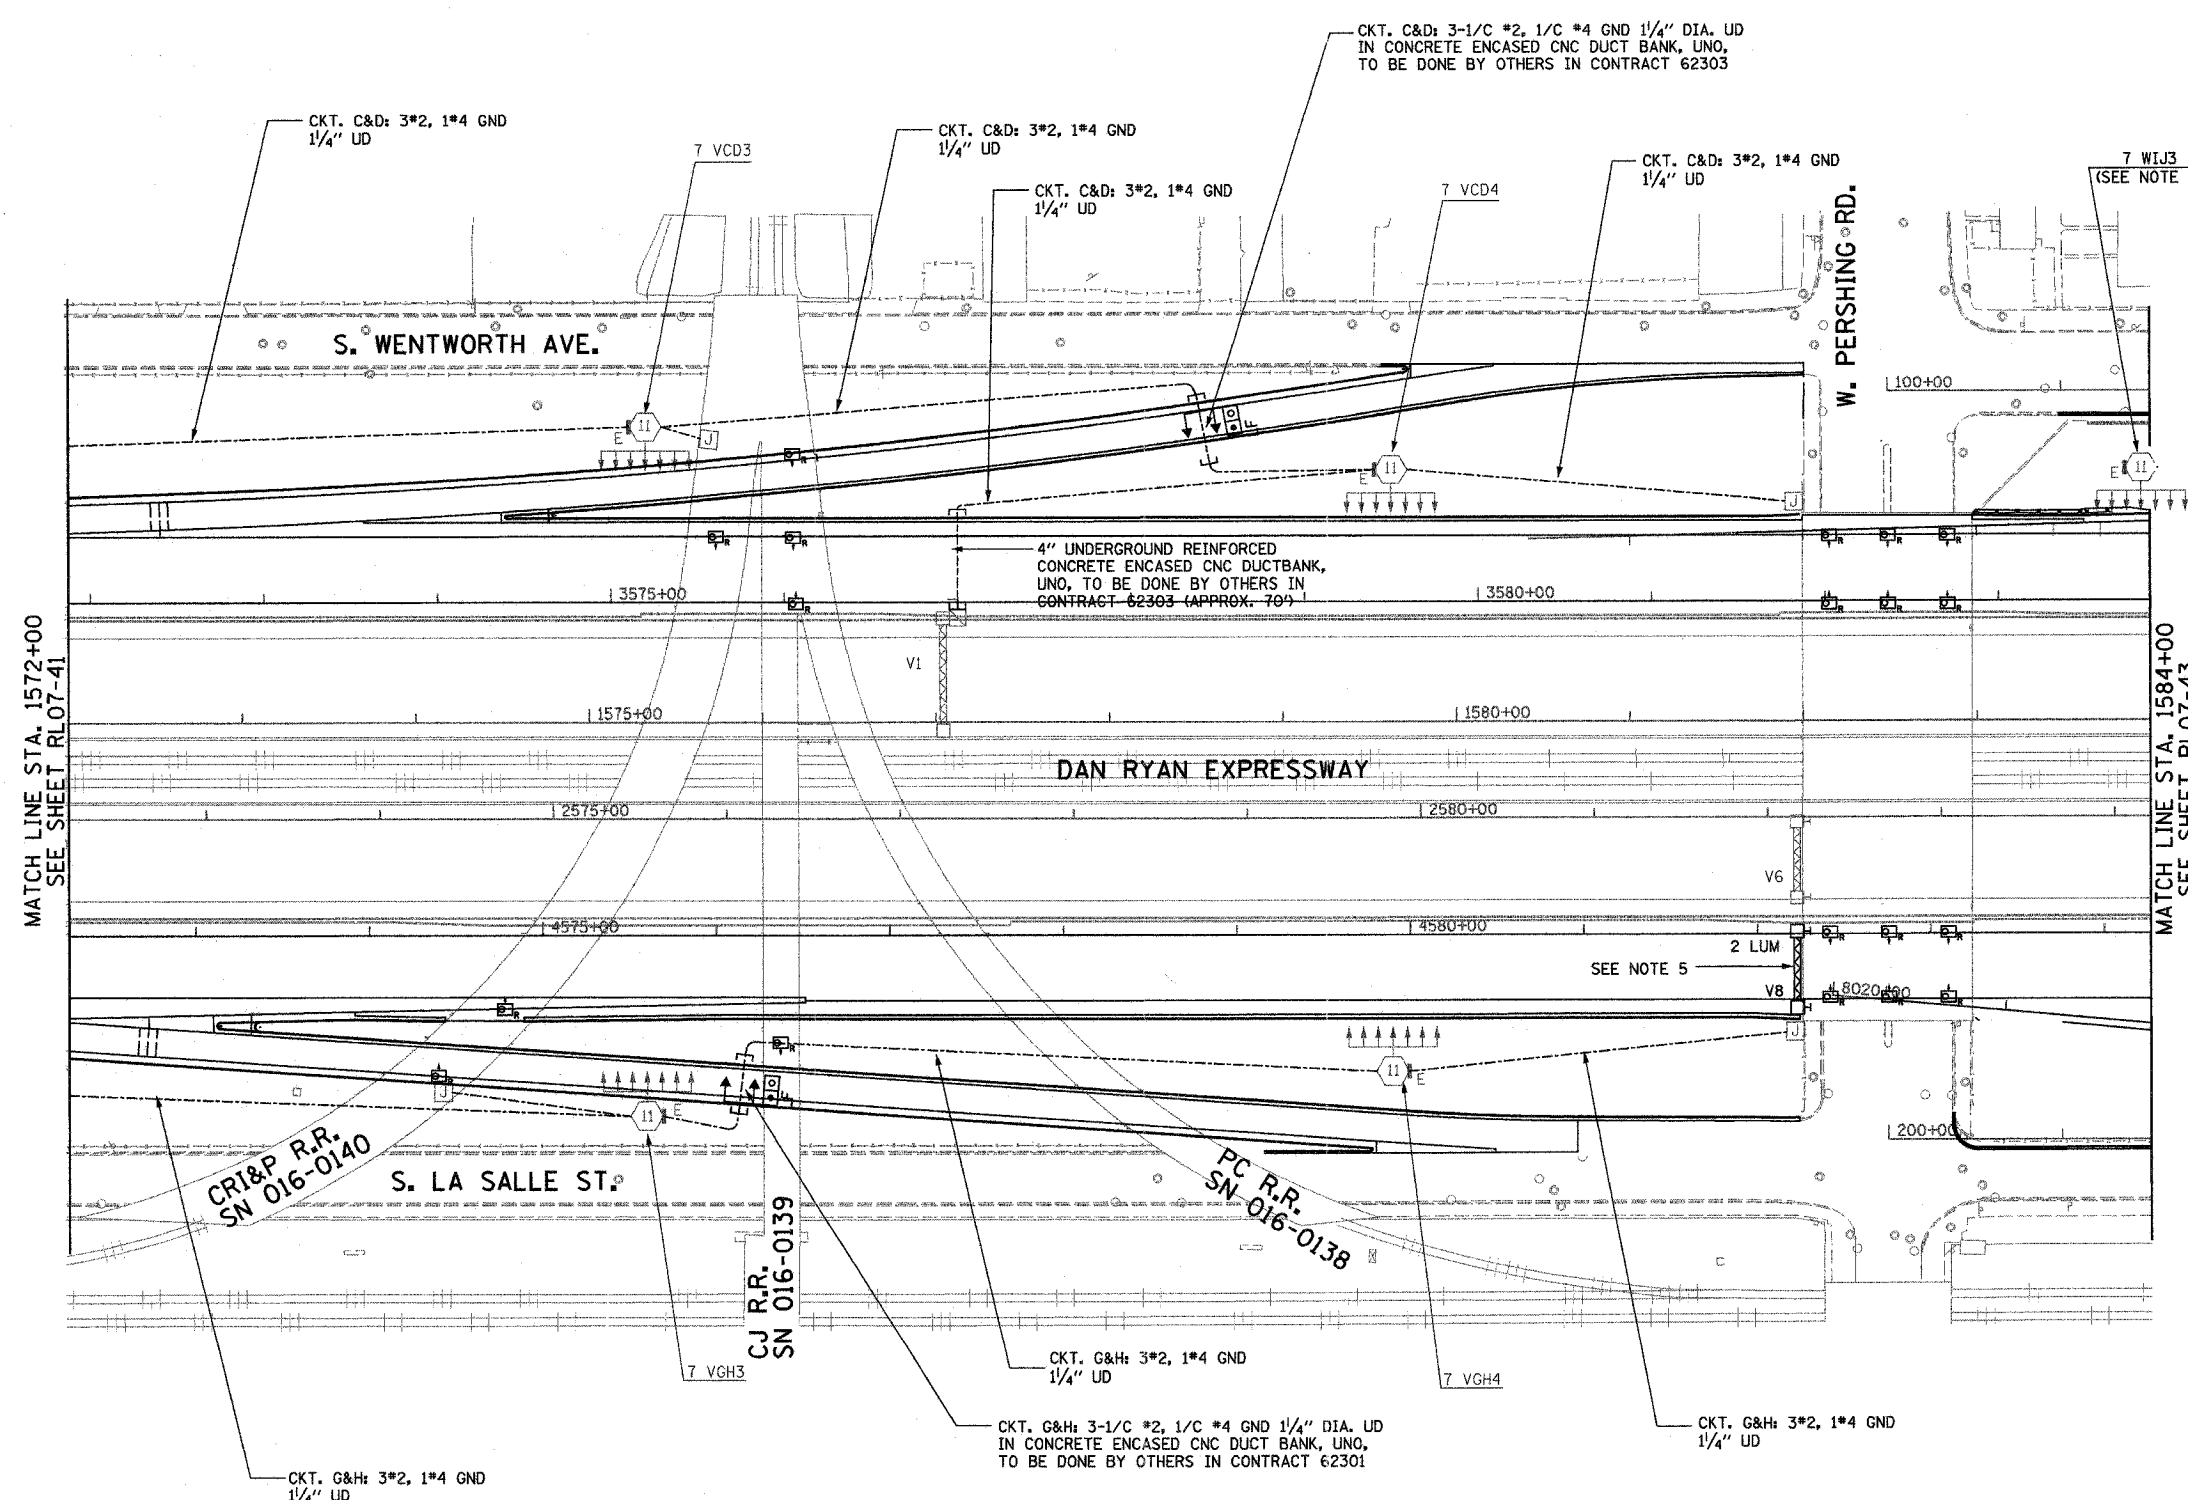

- NOTES:**
- SEE DRAWINGS ME-01 AND ME-02 FOR ELECTRICAL SYMBOLS AND ABBREVIATIONS.
  - UNLESS NOTED OTHERWISE, ALL ITEMS AND WORK SHOWN IN HEAVY LINE WEIGHT ON THIS DRAWING ARE PROPOSED NEW ITEMS AND WORK.
  - THE TEMPORARY TOWER DESIGNATIONS SHALL BE REPLACED WITH THE PERMANENT DESIGNATIONS AS INDICATED ON THIS DRAWING.
  - SEE SHEET UL-03 AND UL-04 FOR UNDERPASS LIGHTING PLANS.
  - EXISTING SIGN SHALL BE REMOVED PRIOR TO INSTALLATION OF PROPOSED SIGN.

MATCH LINE STA. 1572+00  
SEE SHEET RL07-41

MATCH LINE STA. 1584+00  
SEE SHEET RL07-43

CRI&P R.R.  
SN 016-0140

CJ R.R.  
SN 016-0139

PC R.R.  
SN 016-0138

RL07-42

**KAM ENGINEERING, INC.**  
CONSULTING ENGINEERS  
707A Davis Road, Suite 205  
Elgin, Illinois 60123-1369



| REVISIONS |      |
|-----------|------|
| NAME      | DATE |
|           |      |
|           |      |
ILLINOIS DEPARTMENT OF TRANSPORTATION  
F.A.I. 94/90 (DAN RYAN EXPRESSWAY)  
31st STREET TO I-57

**ROADWAY LIGHTING PLANS  
PROPOSED IMPROVEMENTS 2007**

SCALE: 1"=50'  
DATE: OCTOBER 29, 2004  
DRAWN BY: BL  
CHECKED BY: SM

10/15/2004 02:40:35 PM