 



F.A.I. RTE.	SECTION	COUNTY	TOTAL SHEETS	SHEET NO.
94/90	2003-0311	COOK	976	297
STA. 1560+00	TO STA. 1572+00			
FED. ROAD DIST. NO.	ILLINOIS	FED. AID PROJECT		
62583				



MATCH LINE STA. 1560+00  
SEE SHEET RL08-40

MATCH LINE STA. 1572+00  
SEE SHEET RL08-42

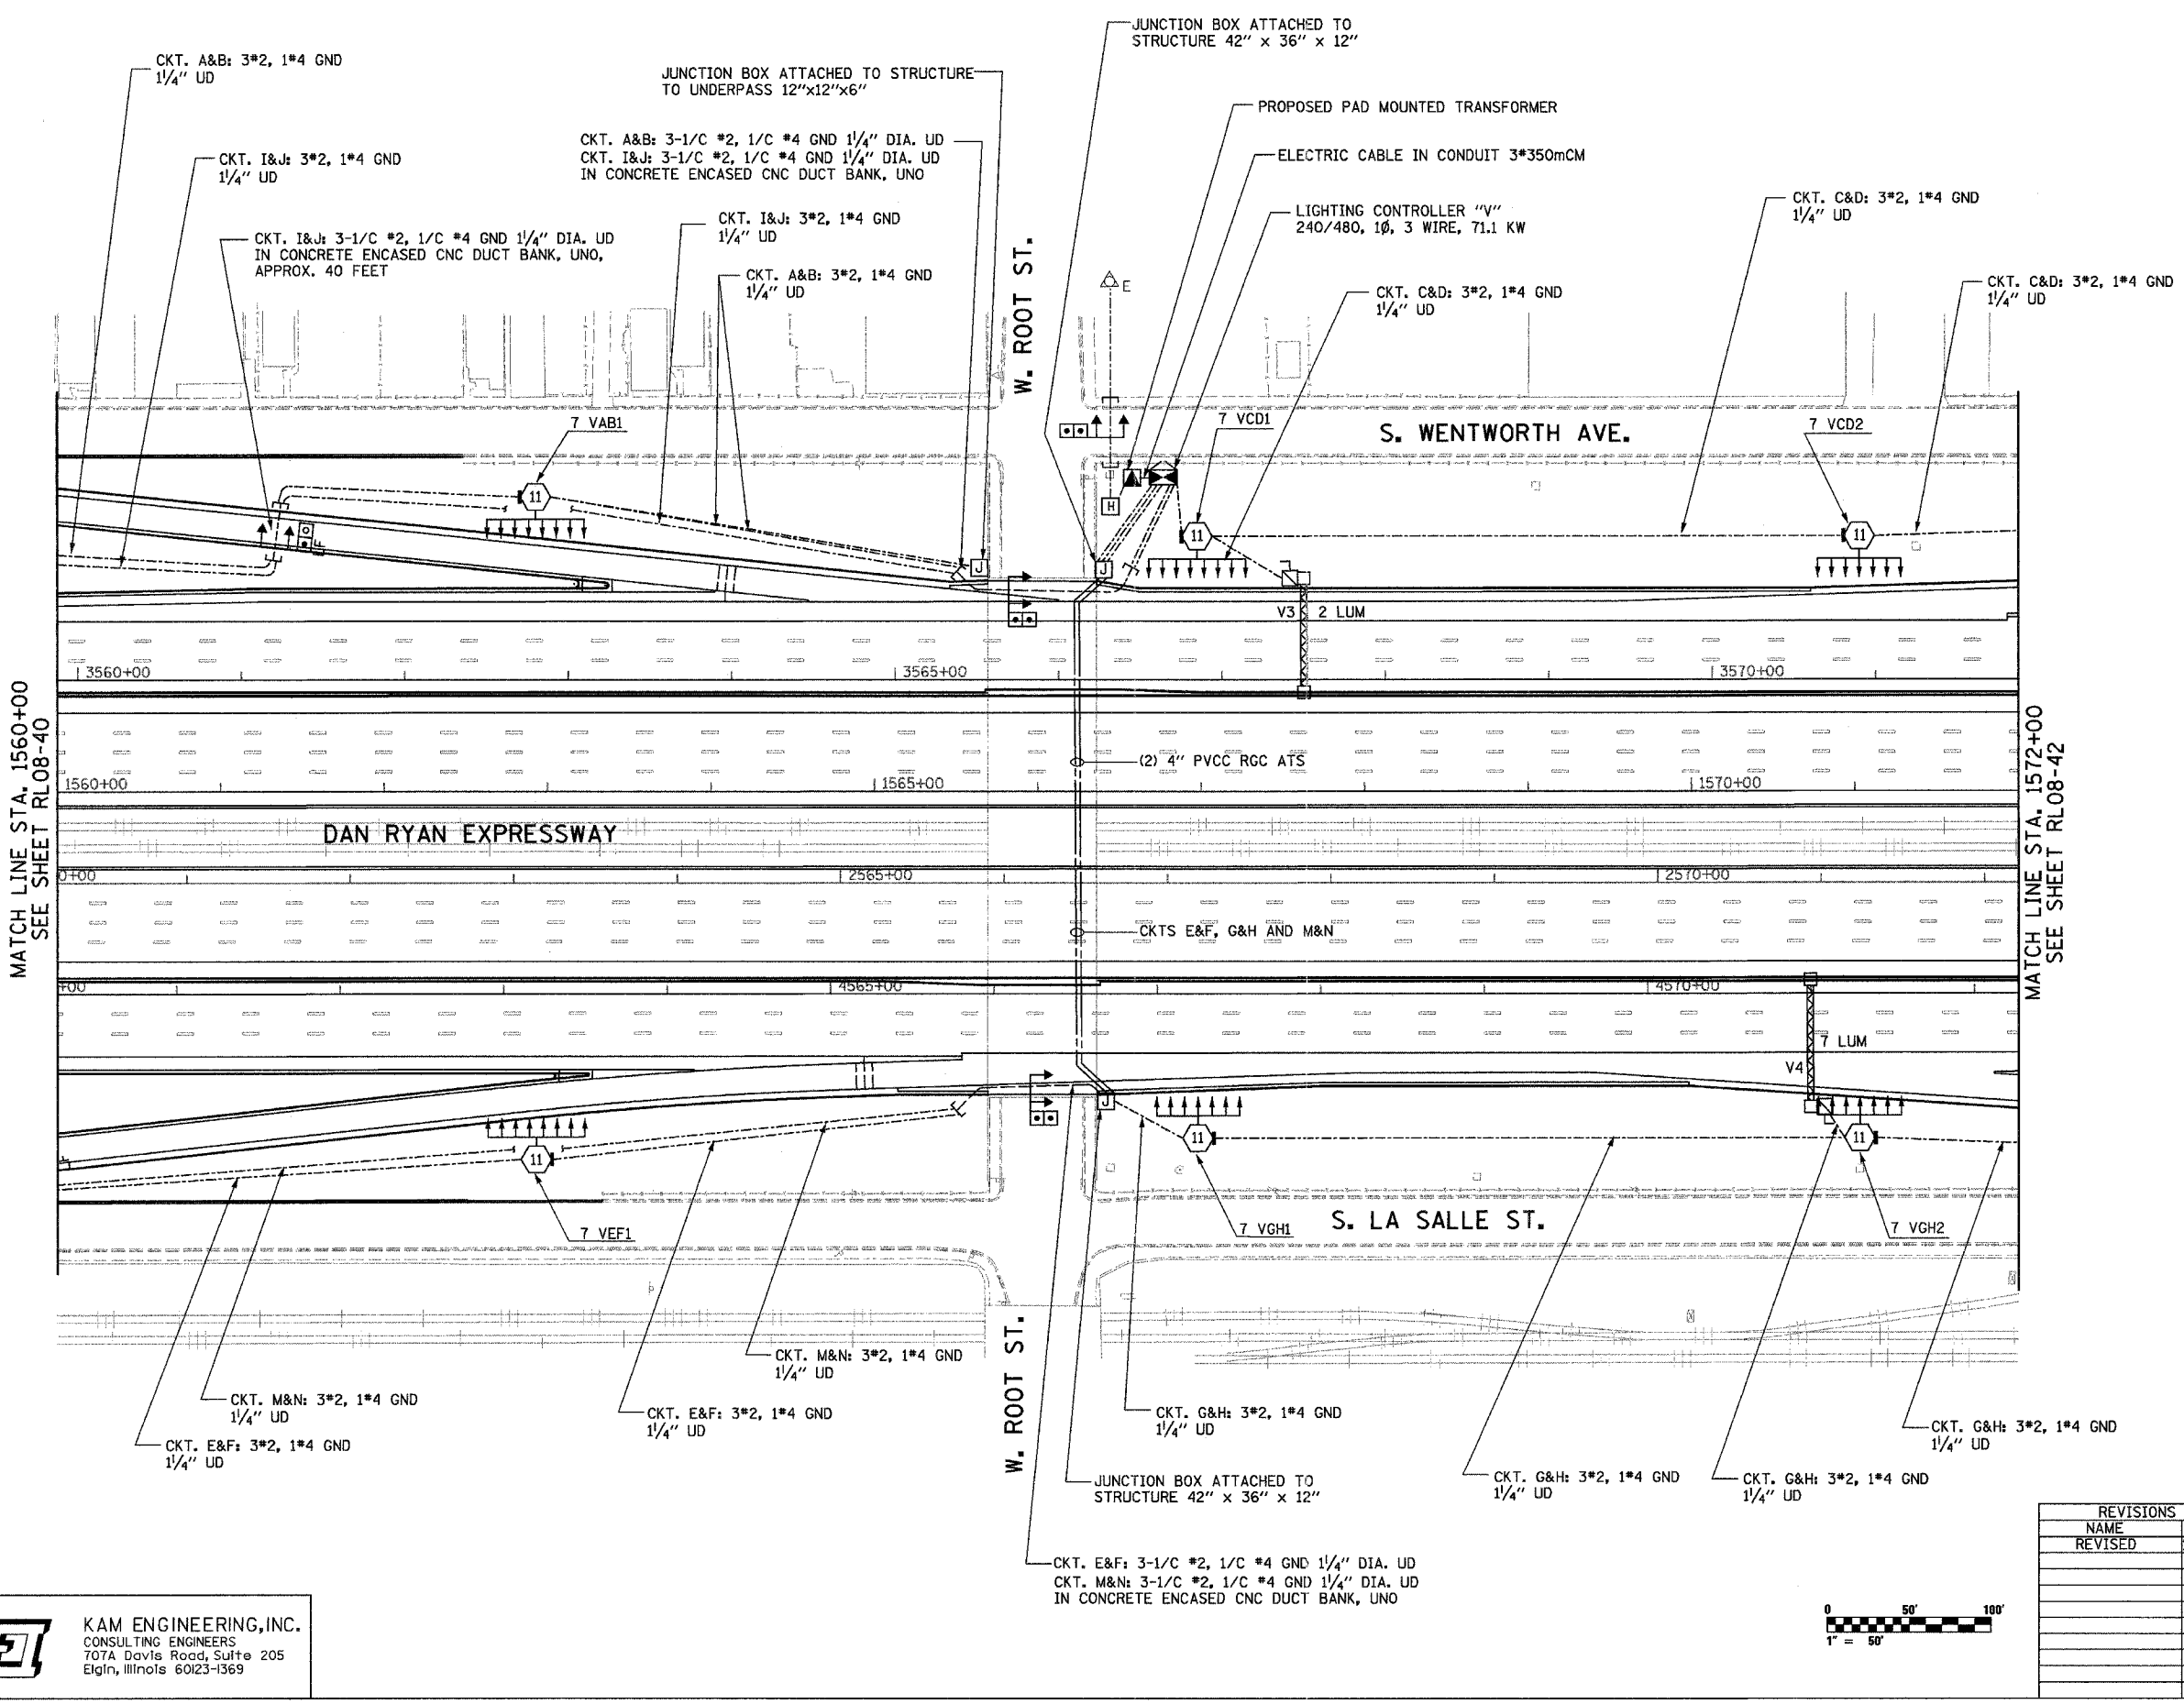

**NOTES:**  
1. SEE SHEET ME-01 FOR ELECTRICAL SYMBOLS, ABBREVIATIONS, AND NOTES.

RL08-41

**KAM ENGINEERING, INC.**  
CONSULTING ENGINEERS  
707A Davis Road, Suite 205  
Elgin, Illinois 60123-1369



REVISIONS	
NAME	DATE
REVISOR	1/21/05

ILLINOIS DEPARTMENT OF TRANSPORTATION  
F.A.I. 94/90 (DAN RYAN EXPRESSWAY)  
31st STREET TO I-57

**ROADWAY LIGHTING PLANS  
FINAL IMPROVEMENTS**

SCALE: 1"=50'  
DATE: OCTOBER 29, 2004  
DRAWN BY: BL  
CHECKED BY: SM

01/25/2005 08:35:42 AM