


F.A.I. RTE.	SECTION	COUNTY	TOTAL SHEETS	SHEET NO.
90/94	2003-0311	COOK	976	323
STA.	TO STA.			
FED. ROAD DIST. NO. 1 ILLINOIS FED. AID PROJECT				

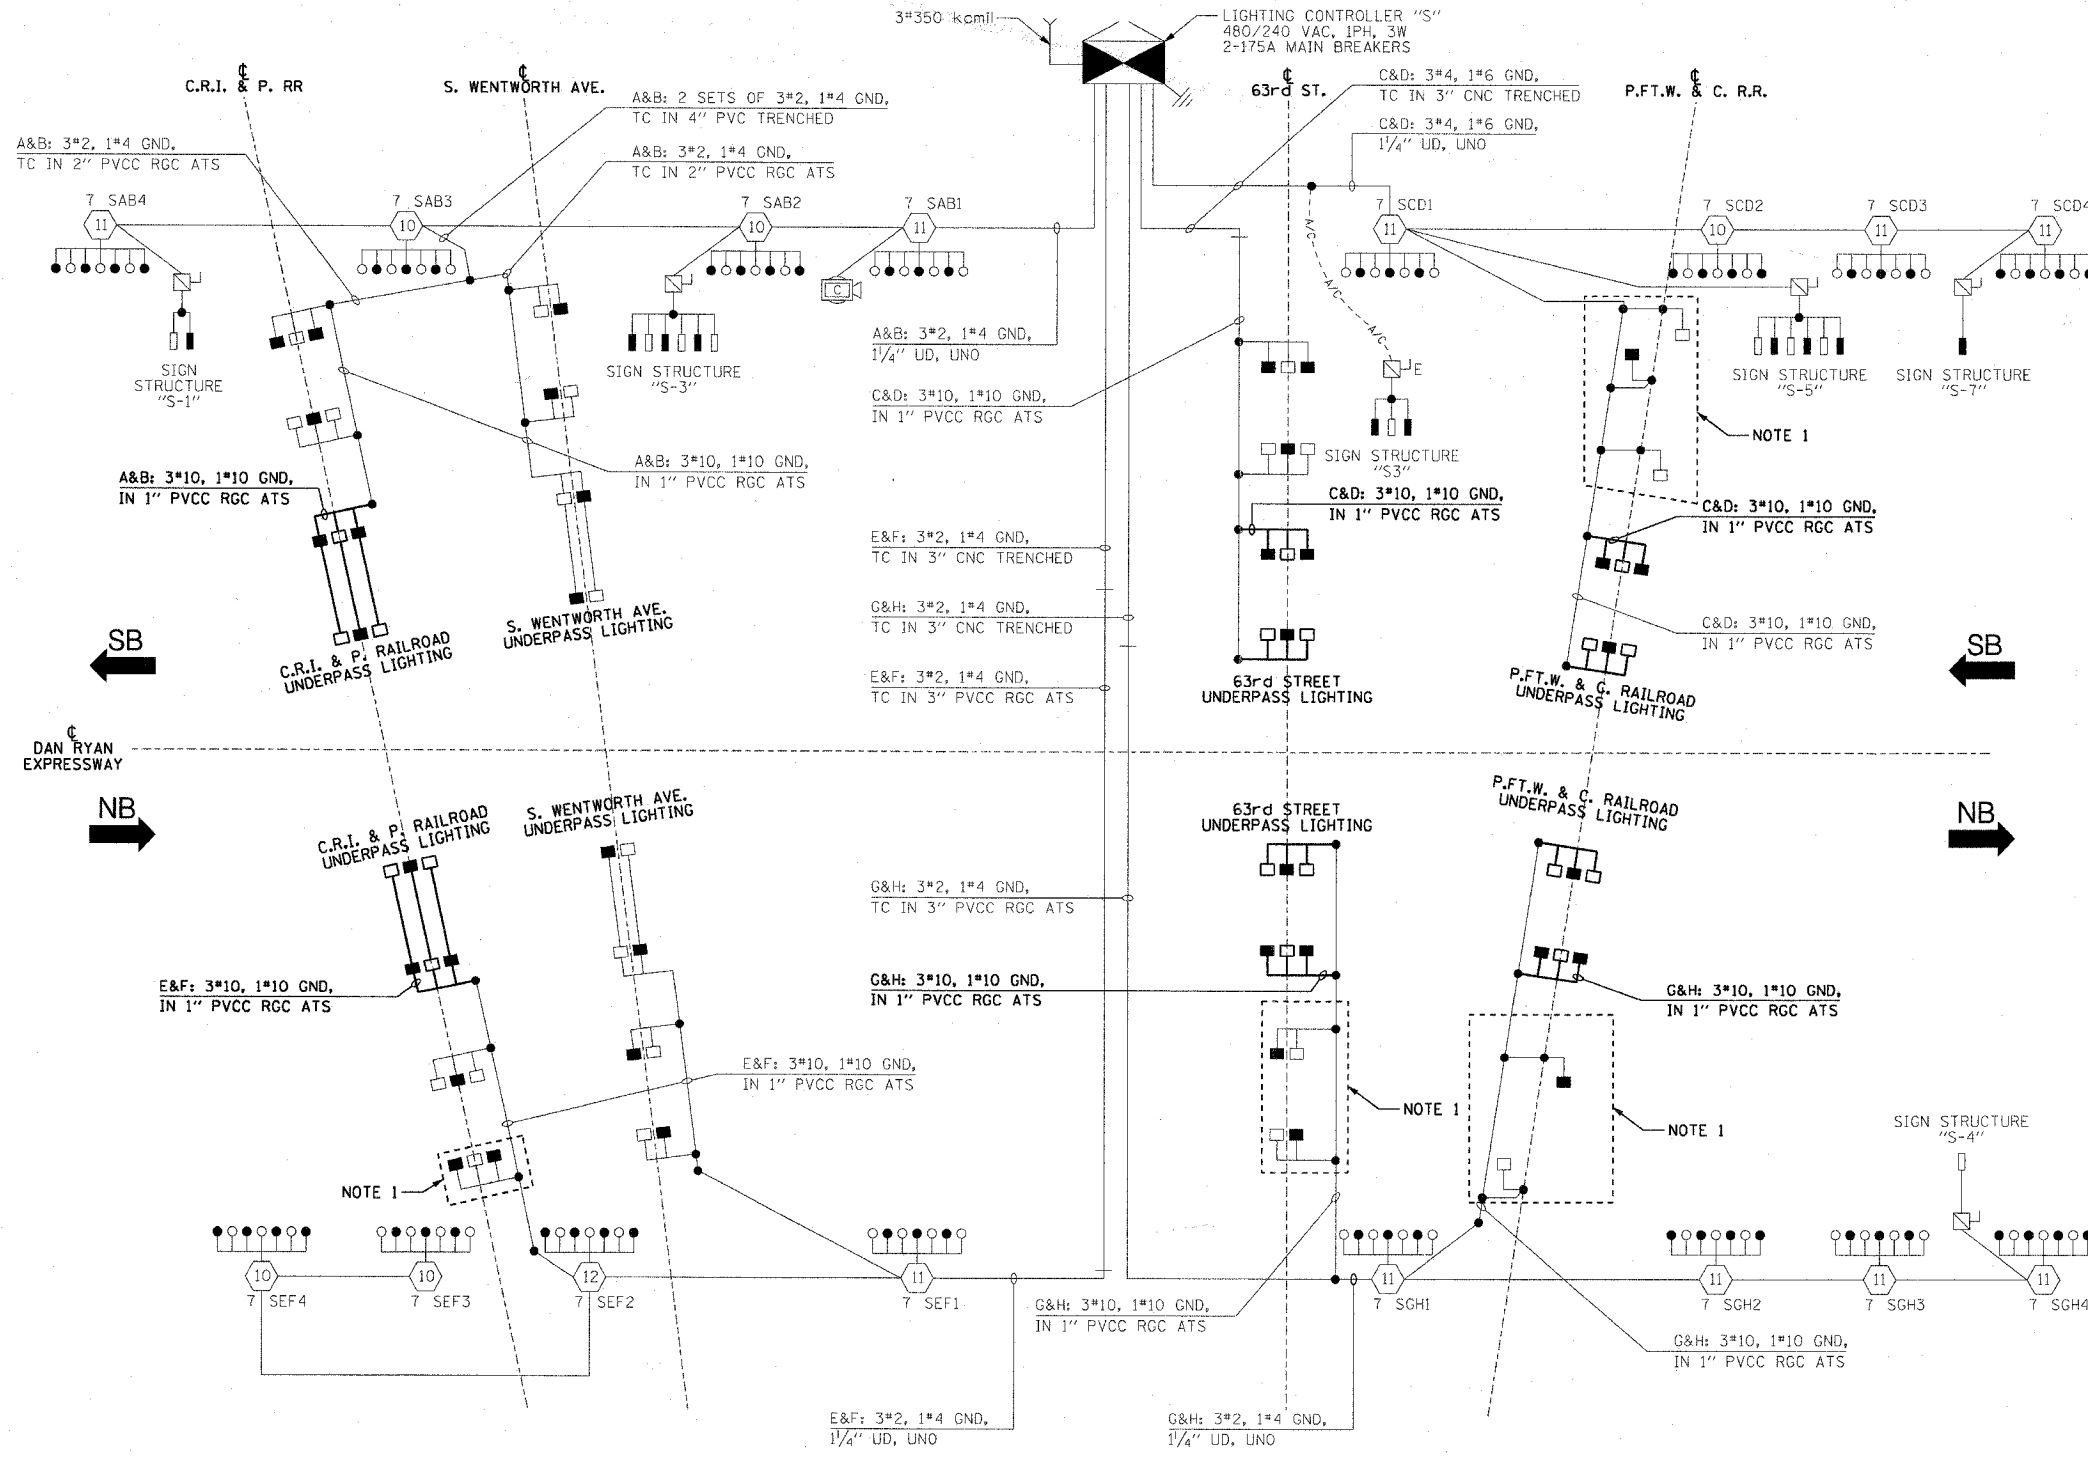

62583

**LEGEND**

- HIGH MAST LIGHT TOWER
- 400 WATT HPS LUMINAIRE (BLACK PHASE-SOLID SYMBOL, RED PHASE-OPEN SYMBOL)
- HIGH MAST TOWER DESIGNATION.
- EXISTING LIGHTED SIGN STRUCTURE WITH 170 WATT FLUORESCENT LUMINAIRE. QUANTITY OF LUMINAIRE AS REQUIRED. (BLACK PHASE- SOLID SYMBOL, RED PHASE-OPEN SYMBOL)
- 3 POLE SAFETY SWITCH
- LIGHTED SIGN STRUCTURE WITH 170 WATT FLUORESCENT LUMINAIRE. QUANTITY OF LUMINAIRE AS REQUIRED. (BLACK PHASE-SOLID SYMBOL, RED PHASE-OPEN SYMBOL)
- UNDERPASS LIGHTING UNIT, 70 WATT HPS LUMINAIRE, UNLESS NOTED OTHERWISE. (BLACK PHASE- SOLID SYMBOL, RED PHASE-OPEN SYMBOL)
- LIGHTING CONTROLLER
- GROUND FIELD
- ELECTRIC UTILITY SERVICE
- CLOSED CIRCUIT TELEVISION CAMERA
- EXISTING AERIAL CABLE

**LOAD TABLE**  
LIGHTING CONTROLLER "S"

CIRCUIT	RED PHASE		BLACK PHASE		
	AMPS	WATTS	AMPS	WATTS	
A	34.3	8,232	B	34.3	8,232
C	34.6	8,304	D	35.9	8,616
E	30.9	7,416	F	30.8	7,392
G	31.2	7,488	H	30.4	7,296
I	-	-	J	-	-
K	-	-	L	-	-
M	-	-	N	-	-
O	-	-	P	-	-
TOTAL	131.0	31,440	TOTAL	131.4	31,536

**SINGLE LINE DIAGRAM**  
LIGHTING CONTROLLER "S"  
NOT TO SCALE

- NOTES:**
- EXISTING UNDERPASS LIGHTING UNITS, 55 WATT LPS LUMINAIRE. (BLACK PHASE-SOLID SYMBOL, RED PHASE-OPEN SYMBOL)
  - UNLESS NOTED OTHERWISE, ALL ITEMS AND WORK SHOWN IN HEAVY LINE WEIGHT ON THIS DRAWING ARE PROPOSED ITEMS AND WORK.

 
**REVISIONS**

NAME	DATE

ILLINOIS DEPARTMENT OF TRANSPORTATION  
F.A.I. 90/94 (DAN RYAN EXPRESSWAY)  
31st STREET TO I-57

**SINGLE LINE DIAGRAM**  
LIGHTING CONTROLLER "S"  
PROPOSED IMPROVEMENTS 2006

SCALE: NOT TO SCALE      DRAWN BY: CUM  
DATE: October 29, 2004      CHECKED BY: WDS



04/17/05 PW