

F.A.I. RTE.	SECTION	COUNTY	TOTAL SHEETS	SHEET NO.
90/94	2003-0311	COOK	976	334
STA.	TO STA.			
FED. ROAD DIST. NO. 1	ILLINOIS FED. AID PROJECT			

62583

LEGEND

- HIGH MAST LIGHT TOWER.
- 400 W. HPS LUMINAIRE (BLACK PHASE-SOLID SYMBOL, RED PHASE-OPEN SYMBOL)
- HIGH MAST TOWER DESIGNATION.
- LIGHTED SIGN STRUCTURE WITH 170 W. FLUORESCENT LUMINAIRES, QUANTITY OF LUMINAIRES AS REQUIRED. (BLACK PHASE-SOLID SYMBOL, RED PHASE, OPEN SYMBOL)
- 3 POLE SAFETY SWITCH
- UNDERPASS LIGHTING UNIT, 70 WATT HPS LUMINAIRE. (BLACK PHASE-SOLID SYMBOL, RED PHASE-OPEN SYMBOL)
- LIGHTING CONTROLLER
- GROUND FIELD
- ELECTRIC UTILITY SERVICE
- CLOSED CIRCUIT TELEVISION CAMERA


CIRCUIT	RED PHASE		BLACK PHASE		
	AMPS	WATTS	AMPS	WATTS	
A	16.1	3,864	B	17.0	4,080
C	19.2	4,608	D	21.1	5,064
E	31.3	7,512	F	31.3	7,512
G	26.9	6,456	H	27.7	6,648
I	30.5	7,320	J	30.5	7,320
K	15.3	3,672	L	15.3	3,672
M	12.6	3,024	N	10.7	2,568
O			P		
TOTAL	151.9	36,456	TOTAL	153.6	36,864

REVISIONS	
NAME	DATE

ILLINOIS DEPARTMENT OF TRANSPORTATION
F.A.I. 90/94 (DAN RYAN EXPRESSWAY)
31st STREET TO I-57

**SINGLE LINE DIAGRAM
LIGHTING CONTROLLER "U"
PROPOSED IMPROVEMENTS 2007**

SCALE: NOT TO SCALE DRAWN BY: CUM
DATE: October 29, 2004 CHECKED BY: WDS

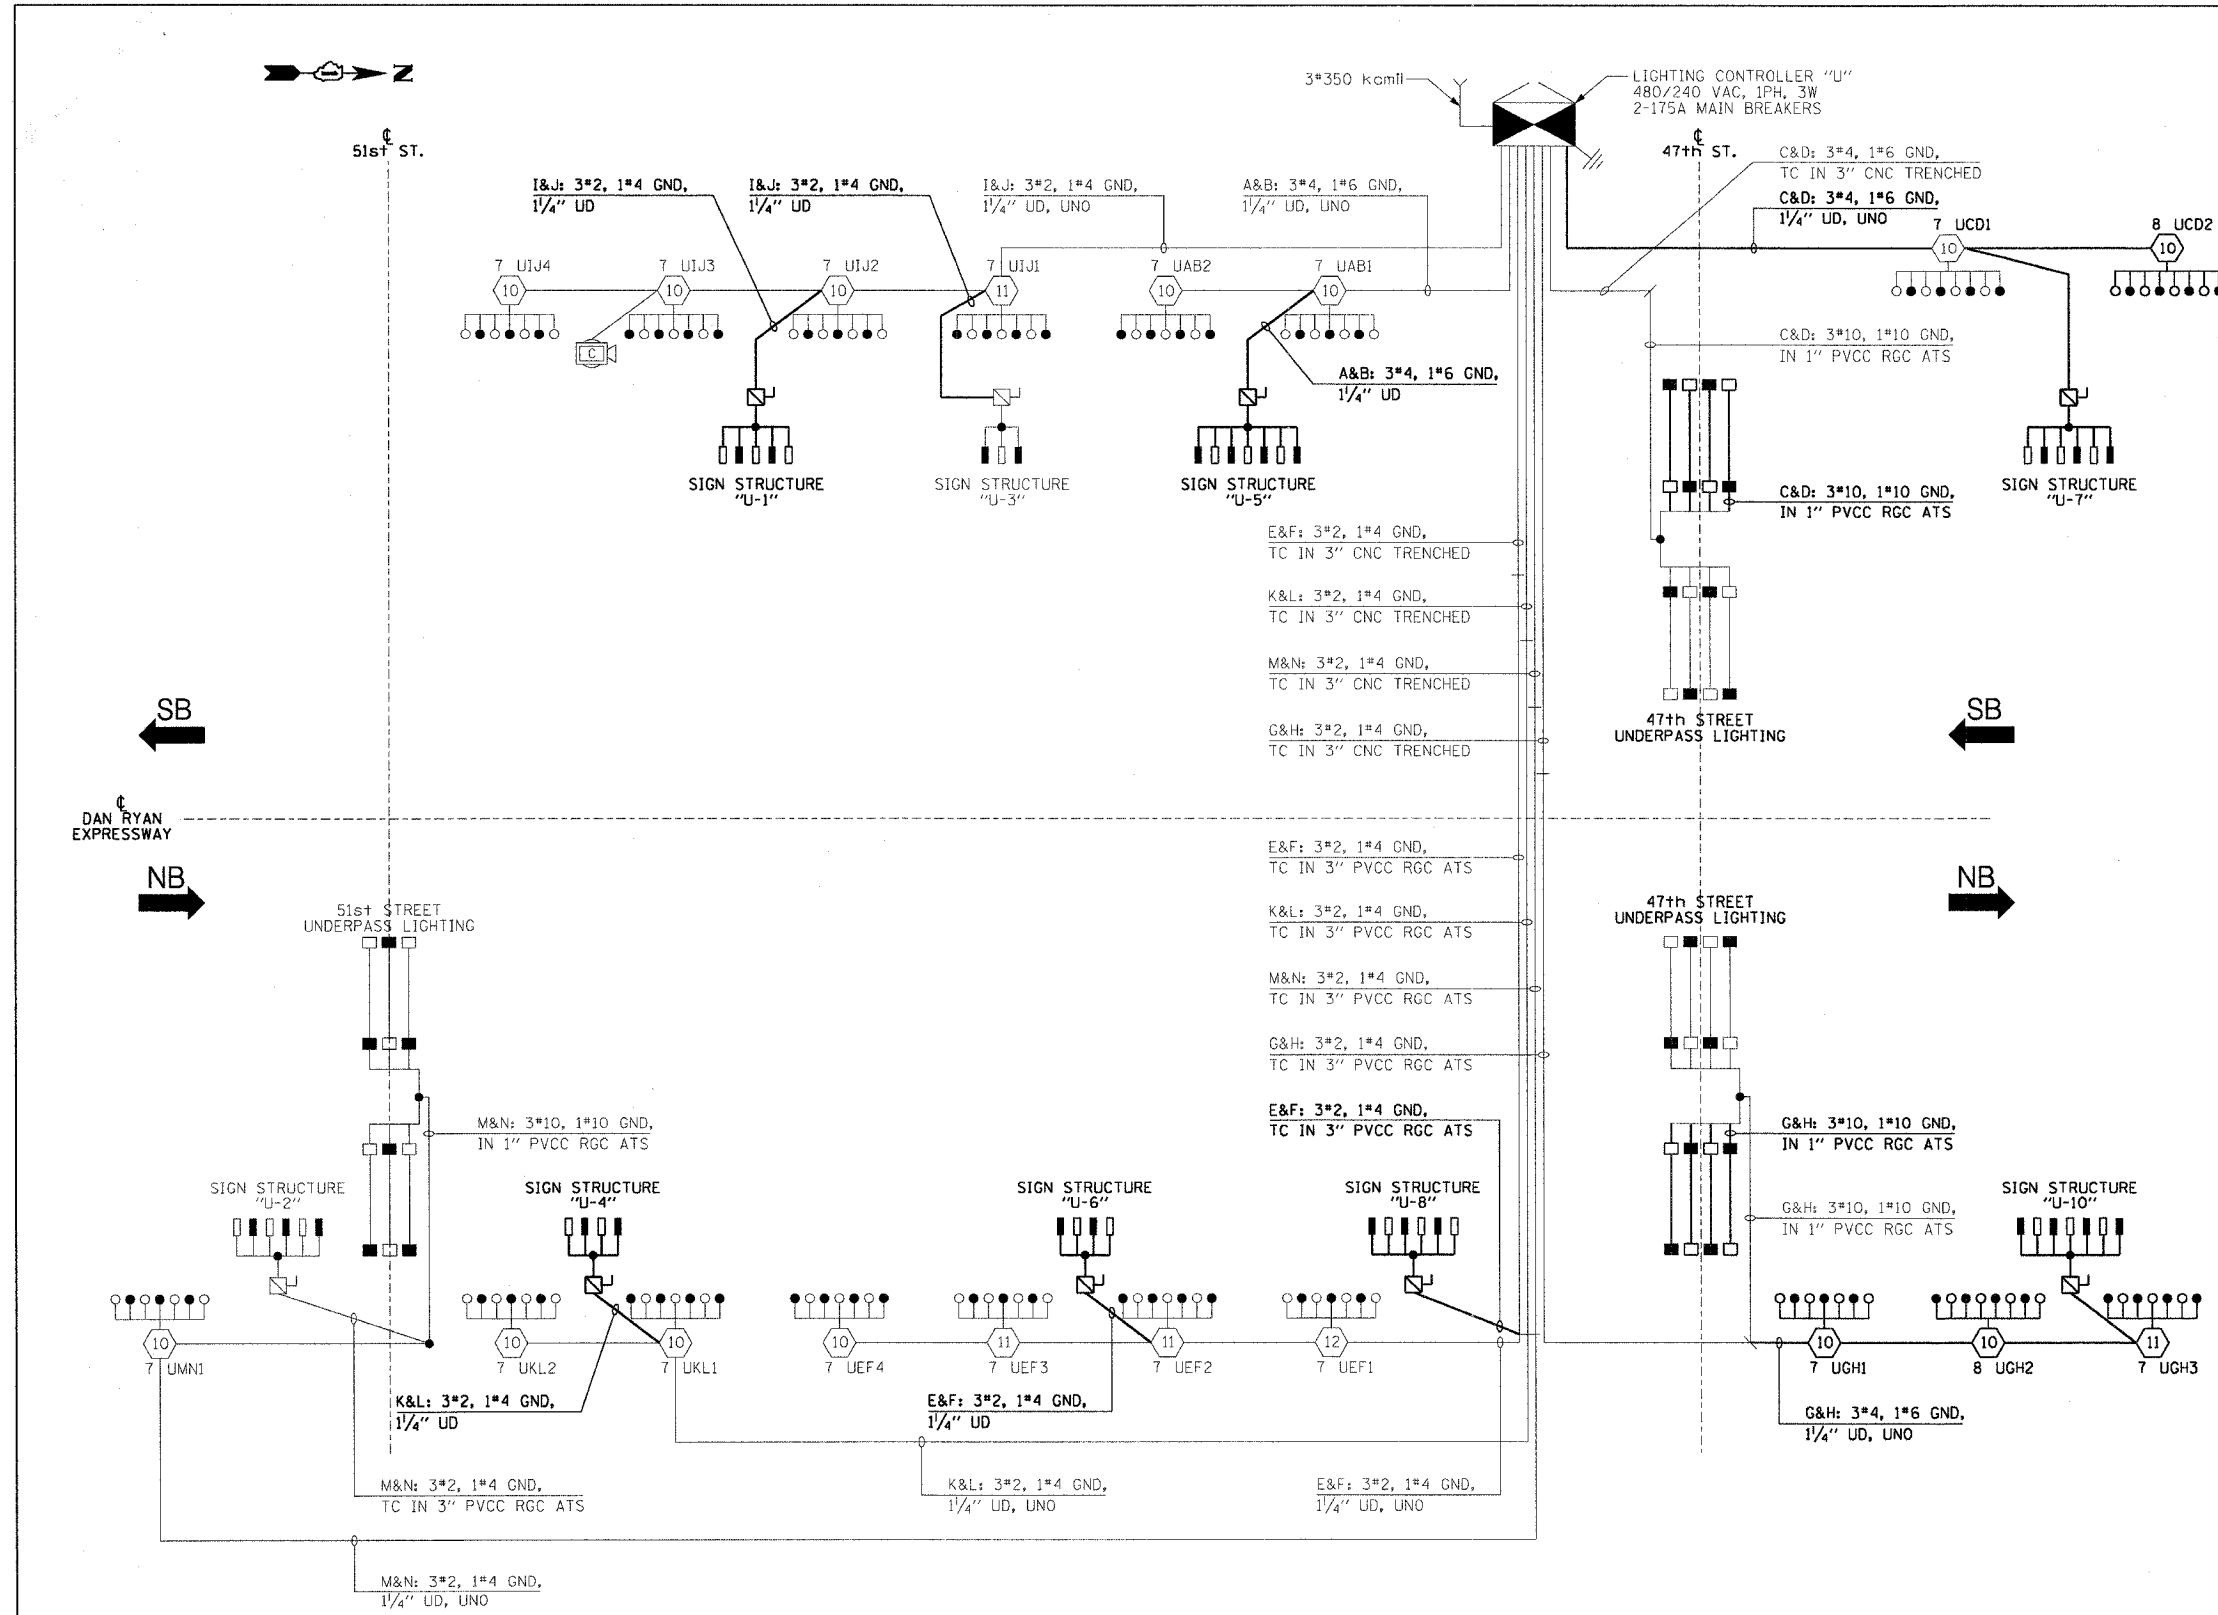

**SINGLE LINE DIAGRAM
LIGHTING CONTROLLER "U"
NOT TO SCALE**

NOTES:
1. UNLESS NOTED OTHERWISE, ALL ITEMS AND WORK SHOWN IN HEAVY LINE WEIGHT ON THIS DRAWING ARE PROPOSED ITEMS AND WORK.



10/15/2004 07:28:29 PM m:\040465\elec\9-cnr\212\slr\contract\2\2007\91020102a.ctb