


SECTION	COUNTY	TOTAL SHEETS	SHEET NO.
2003-0311	COOK	976	681
STA. 1230+00 TO STA. 1243+00			
FED. ROAD DIST. NO.	ILLINOIS	FED. AID PROJECT	
62583			

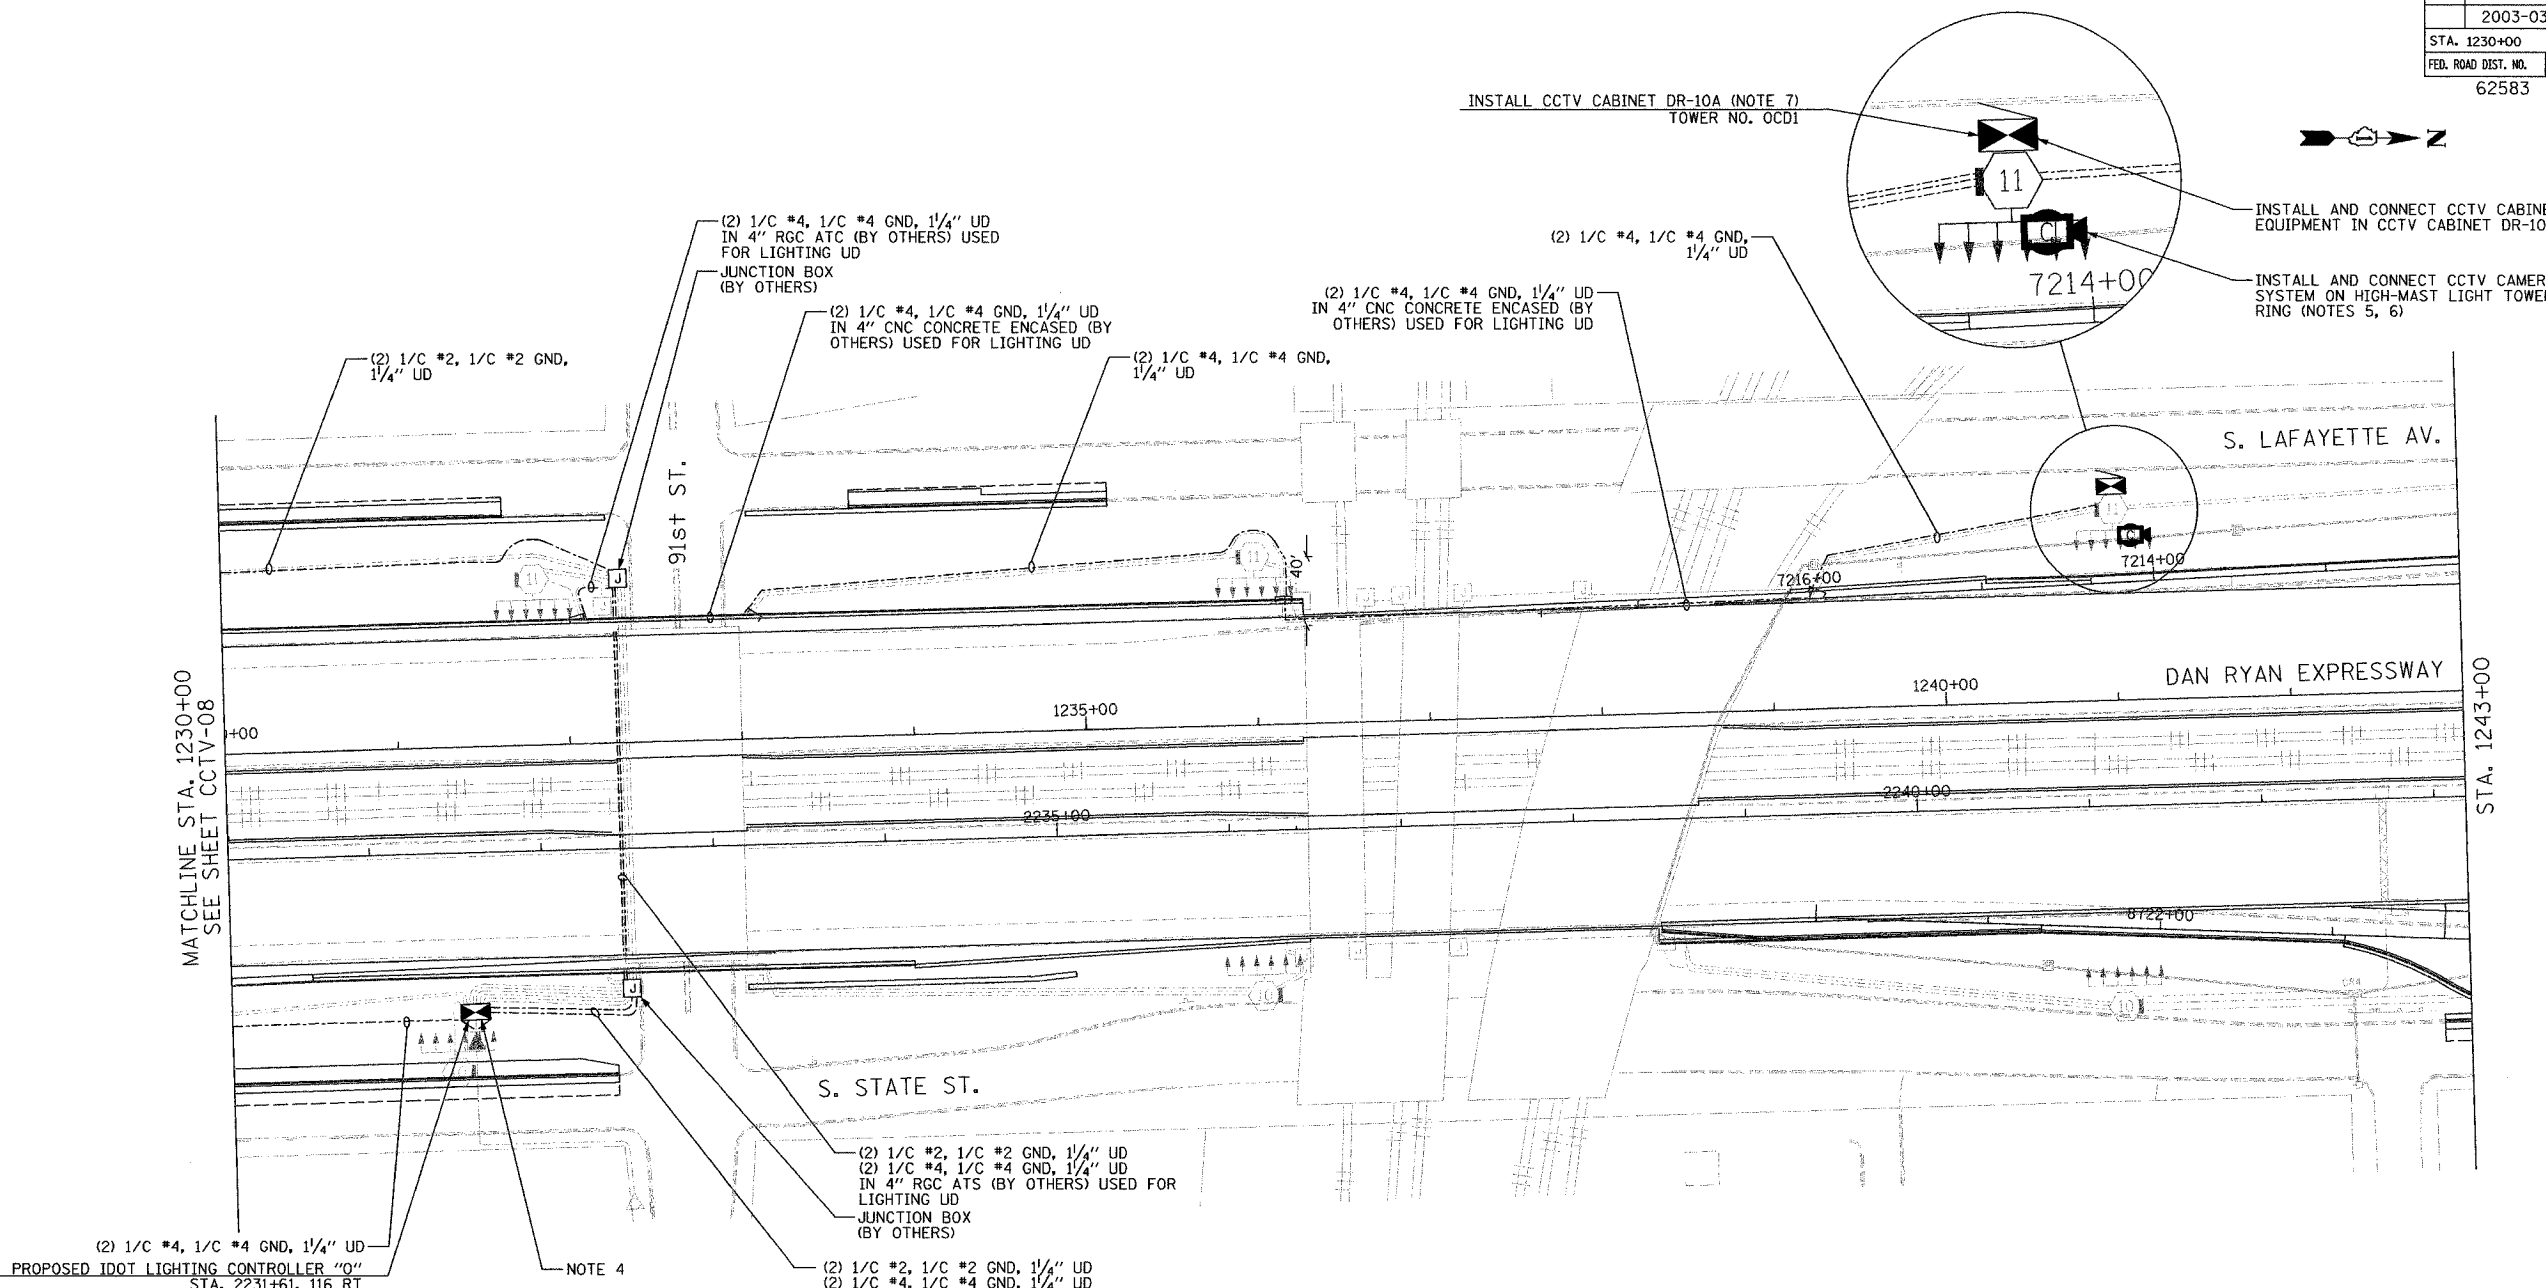

(2) 1/C #4, 1/C #4 GND, 1/4" UD
 PROPOSED IDOT LIGHTING CONTROLLER "Q"
 STA. 2231+61, 116 RT

NOTE 4

(2) 1/C #2, 1/C #2 GND, 1/4" UD
 (2) 1/C #4, 1/C #4 GND, 1/4" UD
 IN 4" RGC ATCS (BY OTHERS) USED FOR
 LIGHTING UD
 JUNCTION BOX
 (BY OTHERS)

(2) 1/C #2, 1/C #2 GND, 1/4" UD
 (2) 1/C #4, 1/C #4 GND, 1/4" UD

(2) 1/C #4, 1/C #4 GND, 1/4" UD
 IN 4" CNC CONCRETE ENCASED (BY
 OTHERS) USED FOR LIGHTING UD

 
(2) 1/C #4, 1/C #4 GND, 1/4" UD

INSTALL CCTV CABINET DR-10A (NOTE 7)
 TOWER NO. OCD1

INSTALL AND CONNECT CCTV CABINET
 EQUIPMENT IN CCTV CABINET DR-10A

INSTALL AND CONNECT CCTV CAMERA
 SYSTEM ON HIGH-MAST LIGHT TOWER
 RING (NOTES 5, 6)

- NOTES:
- SEE DRAWINGS ME-01 AND ME-02 FOR ELECTRICAL SYMBOLS AND ABBREVIATIONS.
 - UNLESS OTHERWISE STATED, ALL NOTED CABLE AND CONDUIT TO BE FURNISHED AND INSTALLED UNDER THIS CONTRACT.
 - THIS SHEET ONLY DEPICTS INSTALLATION OF CLOSED CIRCUIT TELEVISION ELEMENTS. SEE LIGHTING PLANS FOR LIGHTING ELEMENT INSTALLATION.
 - CONTRACTOR SHALL CONNECT CAMERA POWER FEED TO THE AUXILIARY BREAKER IN THE LIGHTING CONTROLLER CABINET AS SHOWN ON DRAWING ME-19.
 - SUPPORT ARM OF THE CCTV DOME CAMERA SHALL BE INSTALLED ON THE EXPRESSWAY SIDE OF THE HIGH-MAST LIGHT TOWER RING AS SHOWN ON DETAIL DRAWING DT-17. THE ARM SHALL BE PERPENDICULAR TO BOTH THE HIGH-MAST LIGHTING RING AND THE CENTERLINE OF THE EXPRESSWAY OR AS DIRECTED BY THE ENGINEER.
 - SEE DRAWING COMM-12 FOR CCTV COMMUNICATIONS SYSTEM CONDUIT AND CABLE LAYOUT.
 - SEE DRAWING DT-17 FOR CCTV CABINET MOUNTING DETAILS ON A HIGH-MAST LIGHT TOWER.



CCTV-09

Edwards AND Kelcey
 ONE NORTH FRANKLIN
 CHICAGO, IL 60606
 PHONE: (312) 251-3000
 FAX: (312) 251-3015
 WEB: WWW.EKCORP.COM

REVISIONS	
NAME	DATE

ILLINOIS DEPARTMENT OF TRANSPORTATION
 F.A.I. 94/90 (DAN RYAN EXPRESSWAY)
 31st STREET to I-57
 CLOSED CIRCUIT TELEVISION
 SITE LAYOUT
 CAMERA DR-10A, DR-11 (SHEET 4 OF 4)
 CAMERA DR-10C (SHEET 3 OF 3)
 CAMERA DR-10B (SHEET 2 OF 2)
 SCALE: 1"=50'
 DATE: October 29, 2004
 DRAWN BY: DHI
 CHECKED BY: MJL

11/19/2004 04:40:44 PM