


SECTION	COUNTY	TOTAL SHEETS	SHEET NO.
2003-031I	COOK	976	702
STA. 1608+00 TO STA. 1620+00			
FED. ROAD DIST. NO.	ILLINOIS	FED. AID PROJECT	
62583			

P:\0300\91035\1608-1620\cctv\0303020302.dwg

 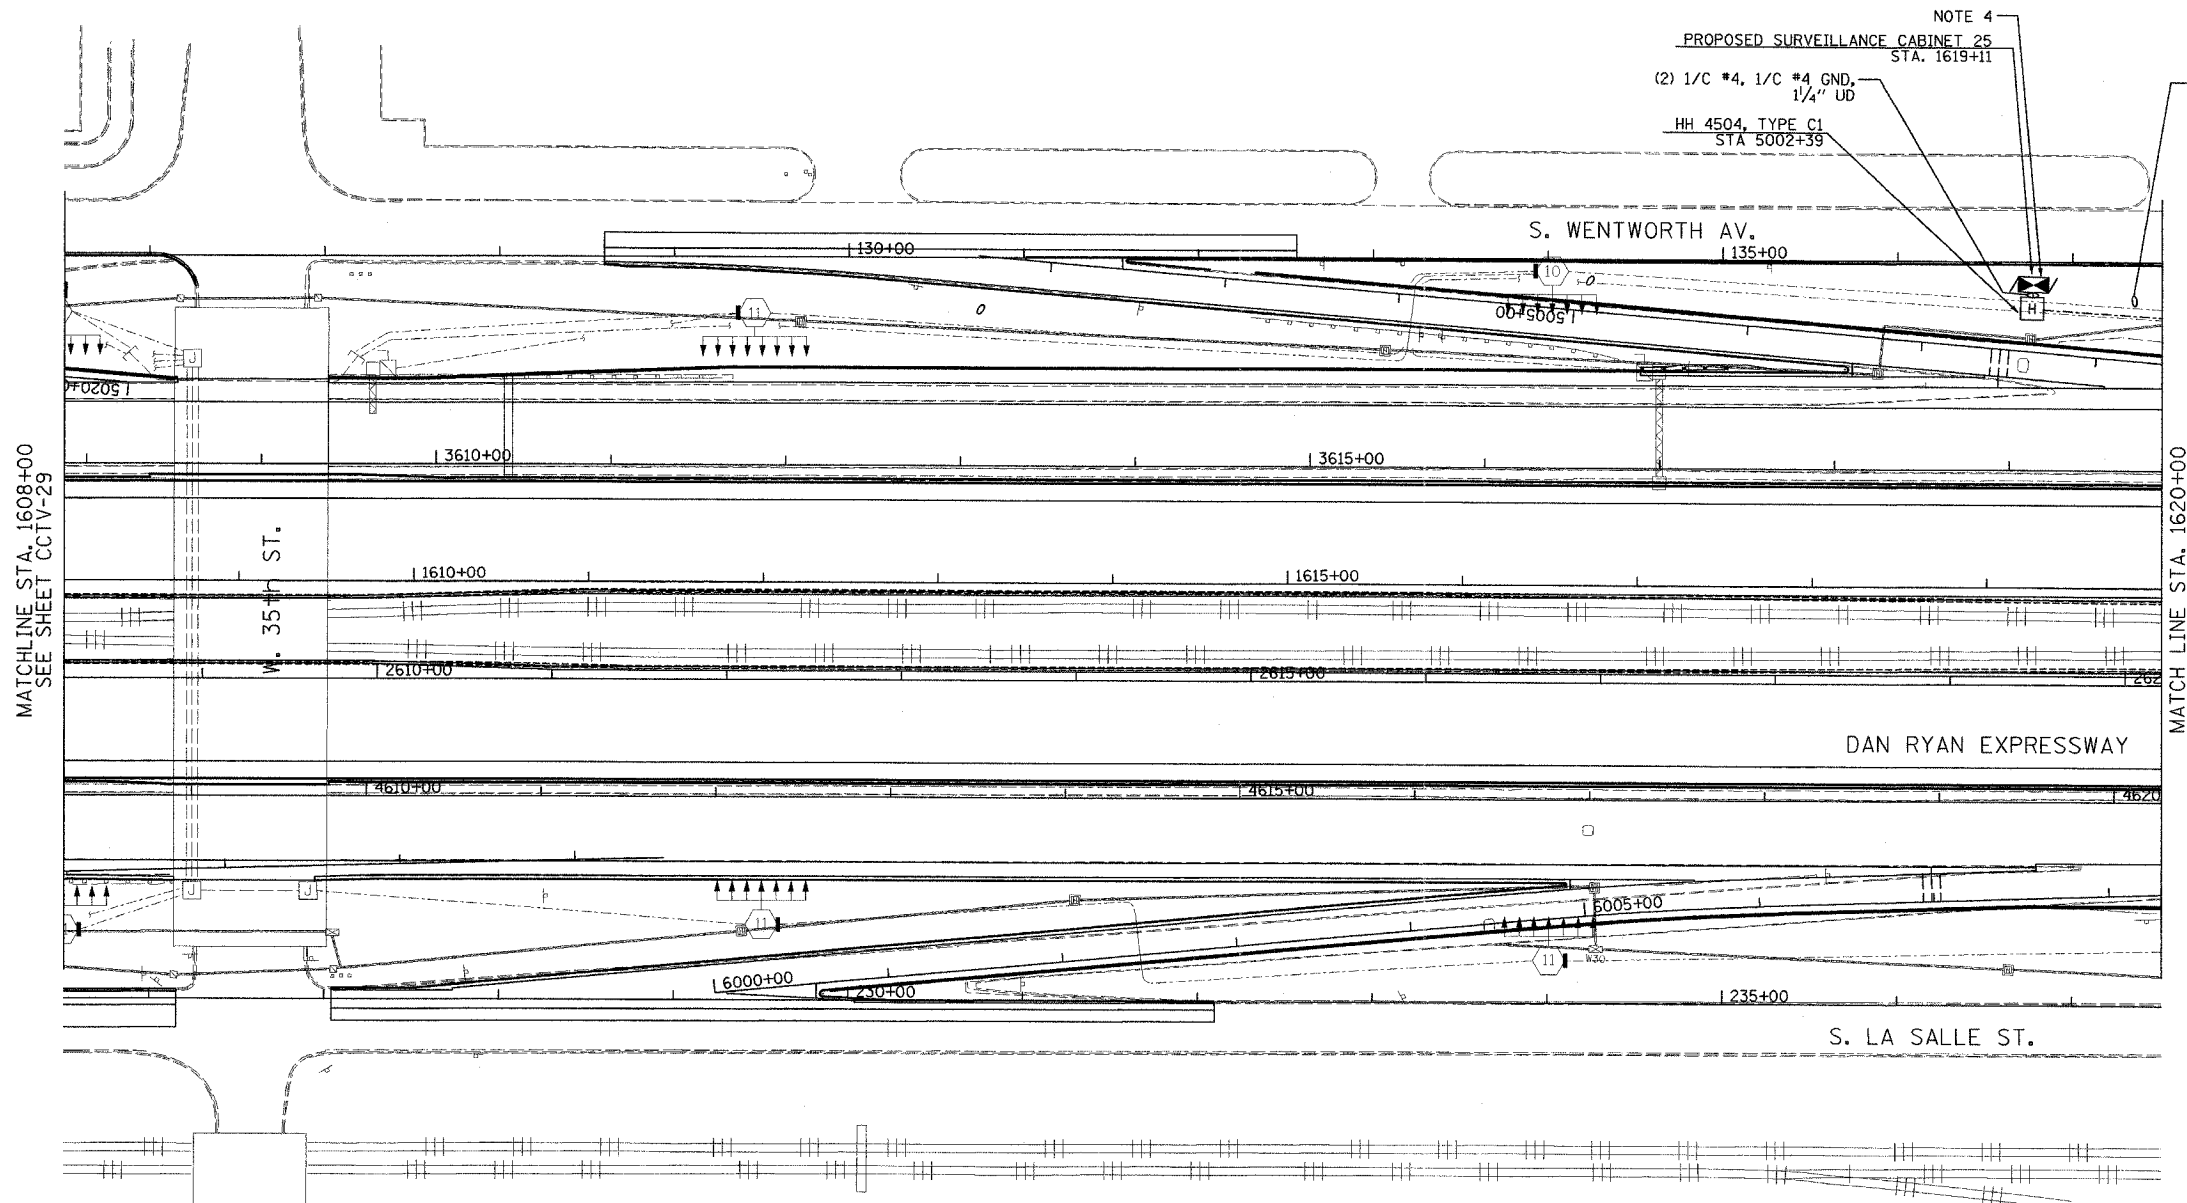


NOTE 4
 PROPOSED SURVEILLANCE CABINET 25
 STA. 1619+11
 (2) 1/C #4, 1/C #4 GND, 1/4" UD
 HH 4504, TYPE C1
 STA 5002+39
 (2) 1/C #4, 1/C #4 GND, 1/4" UD

- NOTES:
1. SEE DRAWINGS ME-01 AND ME-02 FOR ELECTRICAL SYMBOLS AND ABBREVIATIONS.
 2. UNLESS OTHERWISE STATED, ALL NOTED CABLE AND CONDUIT TO BE FURNISHED AND INSTALLED UNDER THIS CONTRACT.
 3. THIS SHEET ONLY DEPICTS INSTALLATION OF CLOSED CIRCUIT TELEVISION ELEMENTS. SEE LIGHTING PLANS FOR LIGHTING ELEMENT INSTALLATION.
 4. CONTRACTOR SHALL CONNECT CAMERA POWER FEED TO TERMINAL BLOCK TWO IN THE IDOT CONTROL CABINET 25 AS SHOWN ON DRAWING DT-36.
 5. SEE DRAWING COMM-46 FOR CCTV COMMUNICATIONS SYSTEM CONDUIT AND CABLE LAYOUT.

MATCHLINE STA. 1608+00
SEE SHEET CCTV-29

MATCH LINE STA. 1620+00
SEE SHEET CCTV-31



CCTV-30

**Edwards
AND Kelcey**
 ONE NORTH FRANKLIN
 CHICAGO, IL 60606
 PHONE: (312) 251-3000
 FAX: (312) 251-3015
 WEB: WWW.EKCORP.COM

REVISIONS	
NAME	DATE

ILLINOIS DEPARTMENT OF TRANSPORTATION
 F.A.I. 94/90 (DAN RYAN EXPRESSWAY)
 31st STREET TO I-57
 CLOSED CIRCUIT TELEVISION
 SITE LAYOUT
 CAMERA DR-3A (SHEET 1 OF 2)
 SCALE: 1"=50'
 DATE: October 29, 2004
 DRAWN BY: DHI
 CHECKED BY: MJL

0/1/1/2004 08:23:37 AM