


F.A.I. RTE.	SECTION	COUNTY	TOTAL SHEETS	SHEET NO.
94/90	2003-0311	COOK	976	861
STA.	TO STA.			
FED. ROAD DIST. NO.	ILLINOIS	FED. AID PROJECT		
62583				

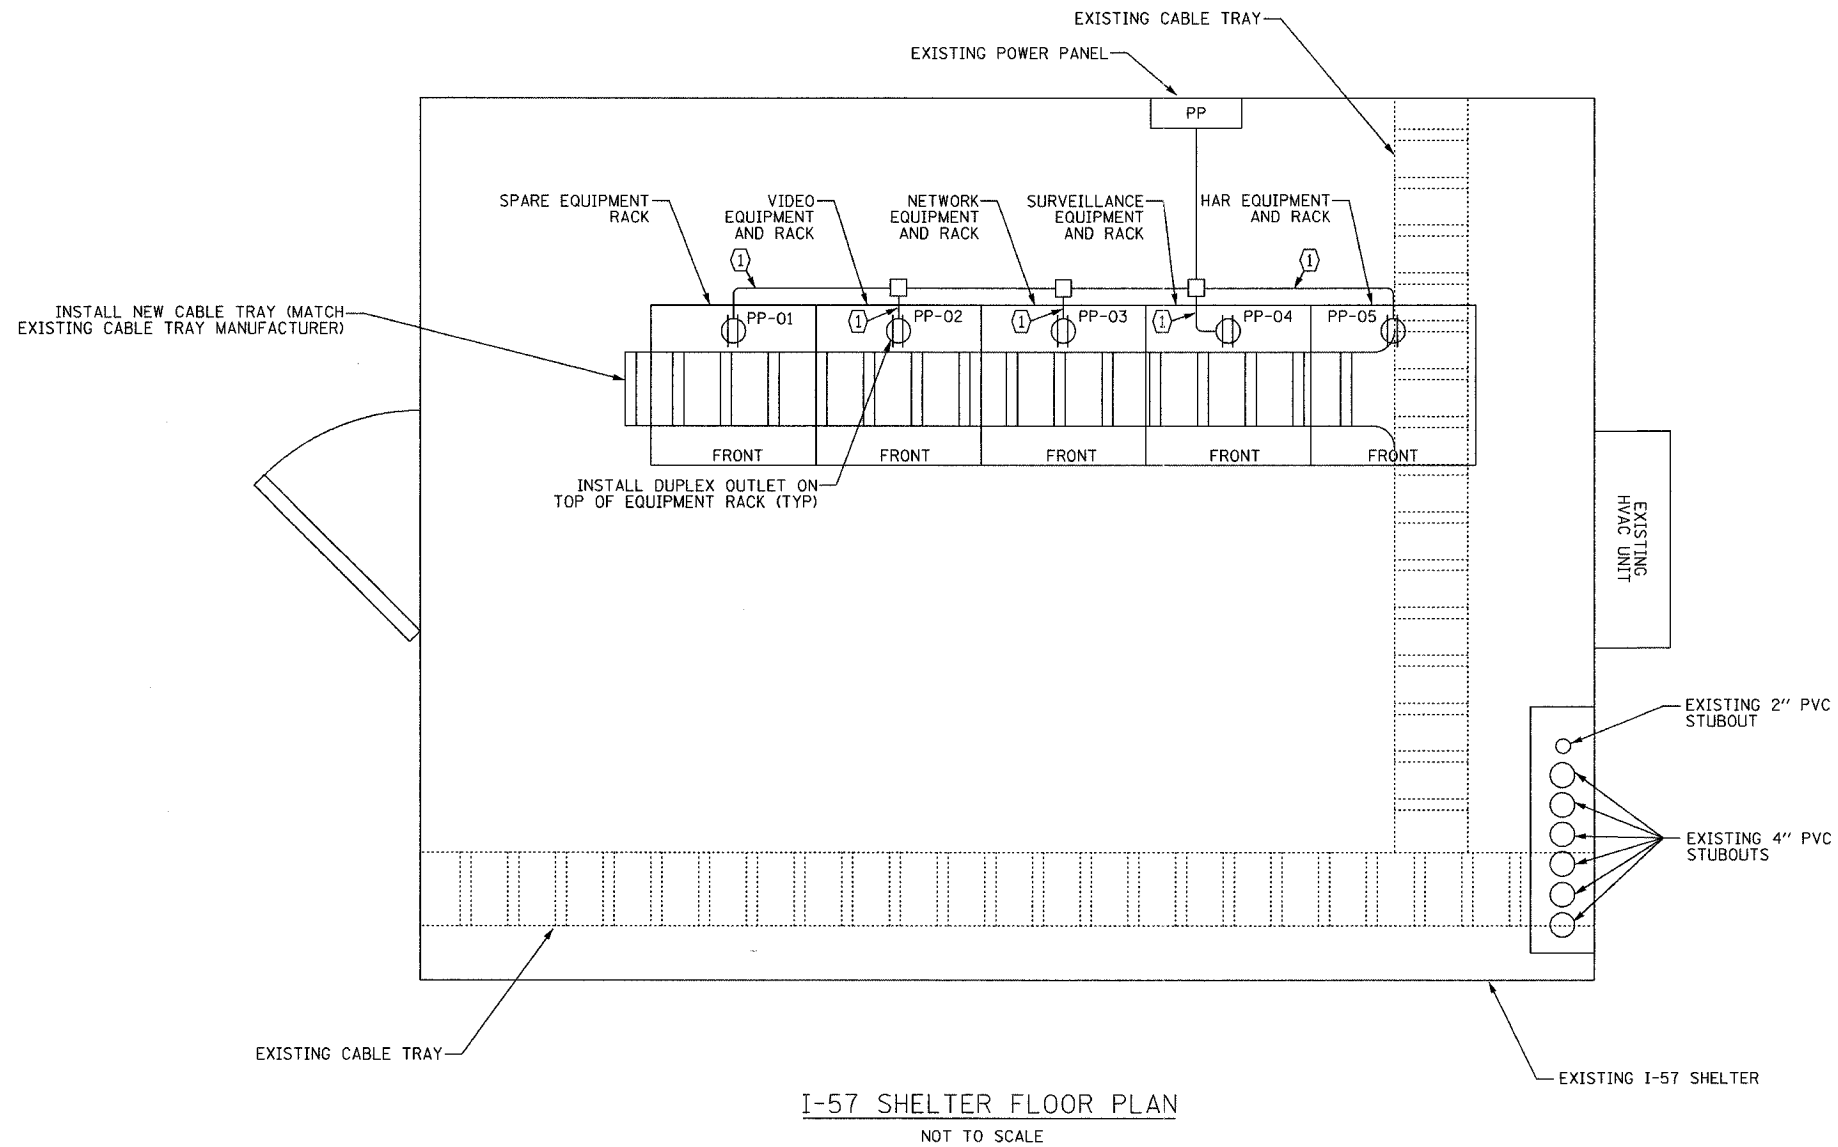

I-57 SHELTER FLOOR PLAN
NOT TO SCALE

- NOTES:**
- EQUIPMENT LAYOUT BASED ON PRELIMINARY SHELTER INSPECTION. CONTRACTOR MAY NEED TO FIELD LOCATE EQUIPMENT RACKS AND EQUIPMENT. COORDINATE WITH THE ENGINEER THE FINAL LOCATION OF ALL EQUIPMENT.
 - CONTRACTOR SHALL MAINTAIN A MINIMUM OF 36" CLEARANCE WHEN INSTALLING NEW RACKS AND EQUIPMENT.
- (1) (2) #12, (1) #12 GND, 3/4" EMT CONDUIT

REVISIONS	
NAME	DATE

ILLINOIS DEPARTMENT OF TRANSPORTATION
F.A.I. 94/90 (DAN RYAN EXPRESSWAY)
31st STREET to I-57

I-57 SHELTER (R04)
EQUIPMENT LAYOUT

SCALE: NOT TO SCALE
DATE: October 29, 2004

DRAWN BY: DHI
CHECKED BY: JEZ

Edwards AND Kelcey
ONE NORTH FRANKLIN
CHICAGO, IL 60606
PHONE: (312) 251-3000
FAX: (312) 251-3015
WEB: WWW.EKCORP.COM

P:\03009035\VTSC\ADD\01020342E.SHT 11/23/2004 12:45:06 PM