



SECTION	COUNTY	TOTAL SHEETS	SHEET NO.
2003-031I	COOK	976	870
STA.	TO STA.		
FED. ROAD DIST. NO.	ILLINOIS	FED. AID PROJECT	
62583			




NEW CCTV CONTROL WORKSTATION  
(SEE NOTE 3 FOR INSTALLATION DETAILS)

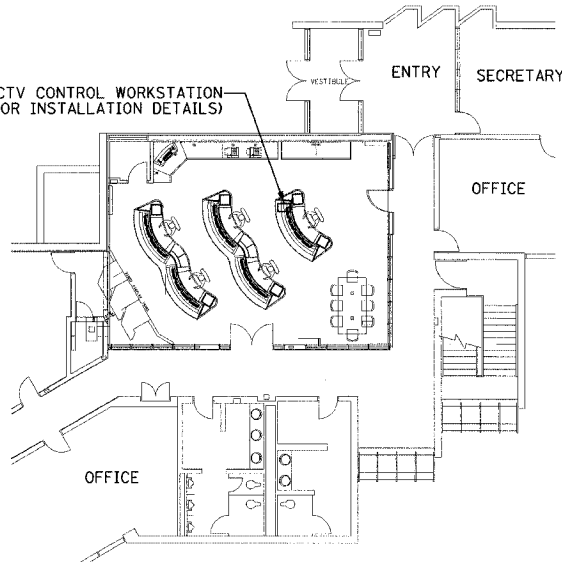

PARTIAL MAIN LEVEL FLOOR PLAN

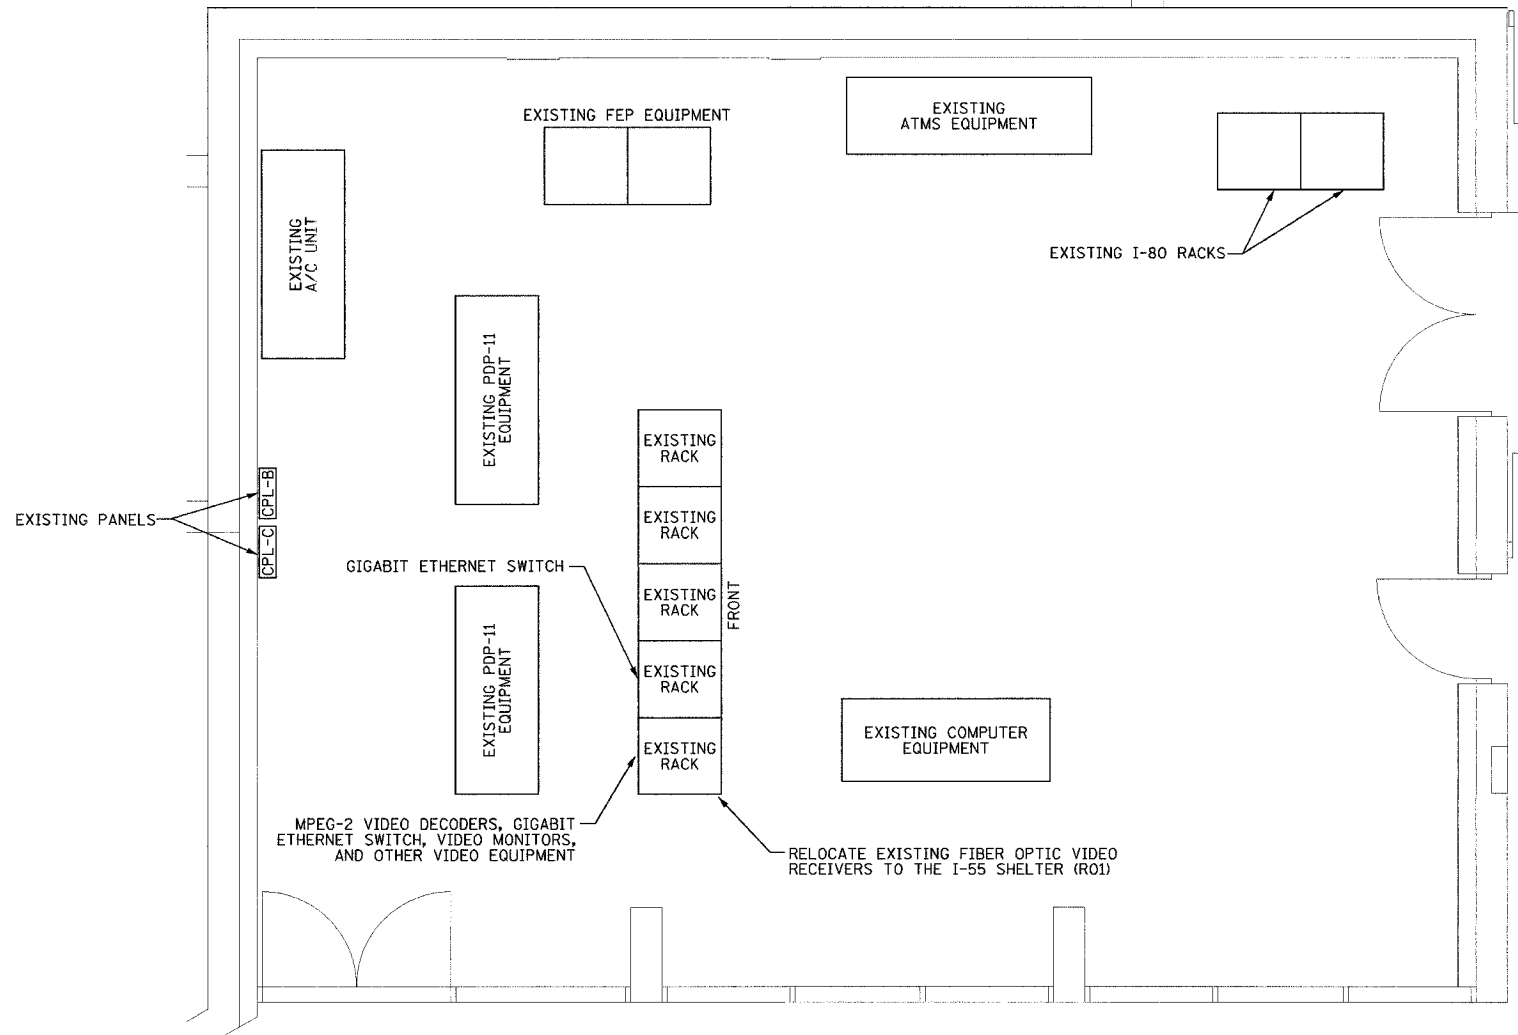

COMPUTER ROOM

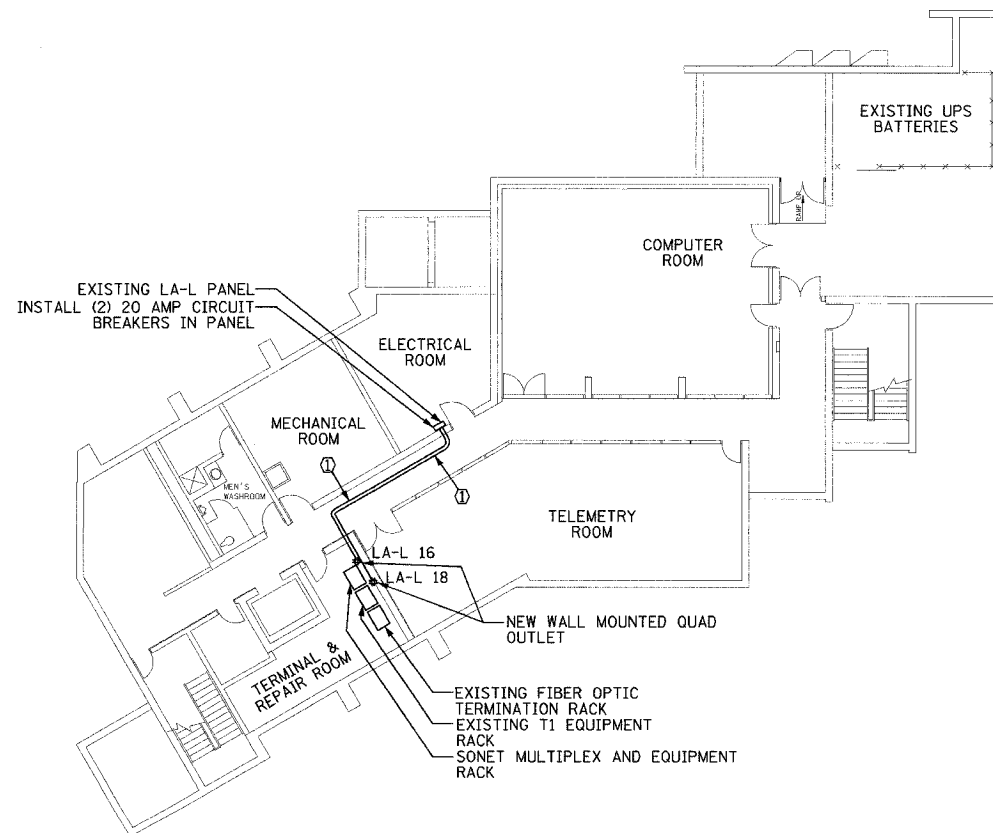

PARTIAL LOWER LEVEL FLOOR PLAN

① (2) #12 & (1) #12 GND, 3/4" C



- NOTES:**
- CONTRACTOR SHALL COORDINATE THE FINAL LOCATION OF ALL EQUIPMENT WITH THE ENGINEER.
  - UNLESS OTHERWISE NOTED, ALL EQUIPMENT IS TO BE INSTALLED UNDER THIS CONTRACT.
  - CCTV CONTROL WORKSTATION SHALL USE EXISTING POWER AND DATA PORTS LOCATED IN CONSOLE.

REVISIONS	
NAME	DATE

ILLINOIS DEPARTMENT OF TRANSPORTATION  
F.A.I. 94/90 (DAN RYAN EXPRESSWAY)  
31st STREET to I-57

TRAFFIC SYSTEMS CENTER (TSC)  
SITE PLAN

SCALE: NOT TO SCALE  
DATE: October 29, 2004

DRAWN BY: DHI  
CHECKED BY: JEZ

**Edwards AND Kelcey**  
ONE NORTH FRANKLIN  
CHICAGO, IL 60606  
PHONE: (312) 251-3000  
FAX: (312) 251-3015  
WEB: WWW.EDCORP.COM

COMM-104

11/23/2004 07:30:27 AM