


SECTION	COUNTY	TOTAL SHEETS	SHEET NO.
2003-0311	COOK	976	874
STA.	TO STA.		
FED. ROAD DIST. NO.	ILLINOIS	FED. AID PROJECT	
62583			

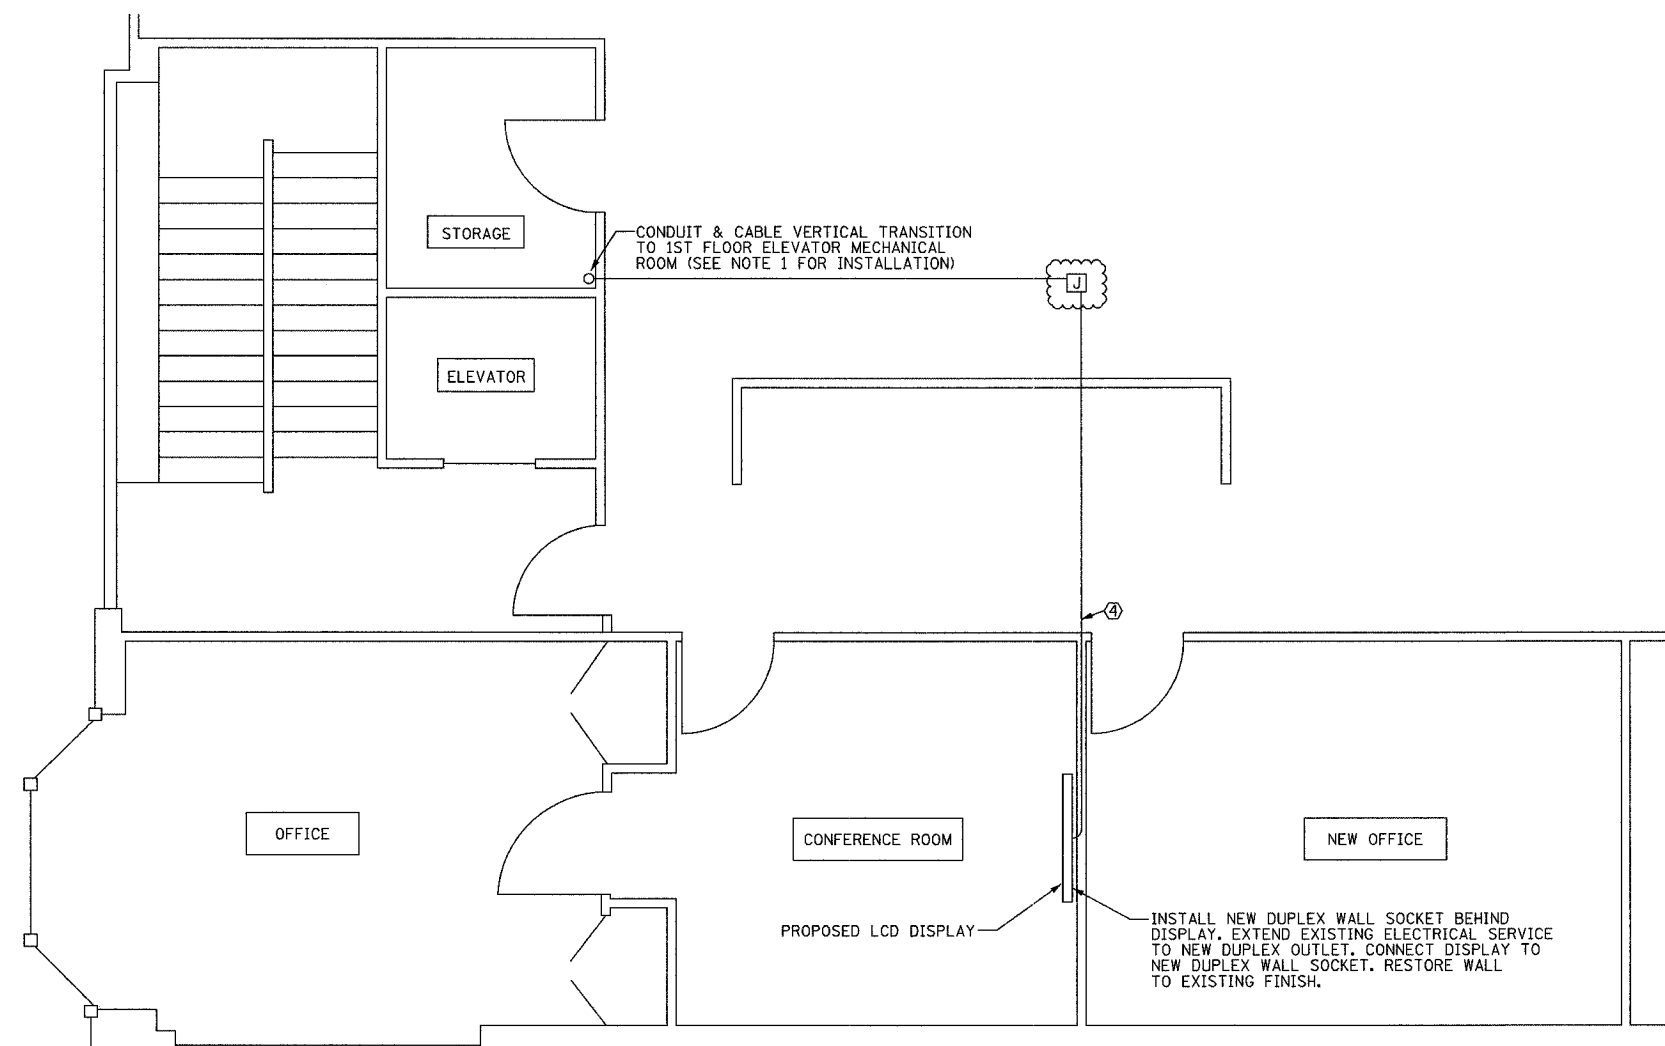

PARTIAL SECOND FLOOR PLAN



COMM-108

NOTES:

- CONTRACTOR SHALL COORDINATE WITH EMERGENCY TRAFFIC PATROL (ETP) BUILDING ENGINEER PRIOR TO PERFORMING ANY WORK. CONTRACTOR SHALL COORDINATE THE CONDUIT AND CABLE ROUTING WITHIN THE ETP BUILDING.
- WHEN POSSIBLE, CONTRACTOR SHALL CONCEAL CABLE AND CONDUIT INSTALLATION IN CEILING SPACE.

CABLE/CONDUIT IDENTIFIERS

- ① (2) #12 AND (1) #12 GND, 3/4" C
- ② 24-FIBER OPTIC CABLE, 2" C
- ③ SPARE, 2" C
- ④ RG-6 COAX CABLE, 3/4" C

REVISIONS	
NAME	DATE
REVISION 1	12/17/04

ILLINOIS DEPARTMENT OF TRANSPORTATION  
 F.A.I. 94/90 (DAN RYAN EXPRESSWAY)  
 31st STREET to I-57

EMERGENCY TRAFFIC PATROL (ETP)  
 SITE PLAN

SCALE: NOT TO SCALE  
 DATE: October 29, 2004

DRAWN BY: DHI  
 CHECKED BY: JEZ

**Edwards AND Kelcey**  
 ONE NORTH FRANKLIN  
 CHICAGO, IL 60606  
 PHONE: (312) 251-3000  
 FAX: (312) 251-3015  
 WEB: WWW.EKCORP.COM

12/15/2004 01:52:28 PM