



F.A.I. RTE.	SECTION	COUNTY	TOTAL SHEETS	SHEET NO.
90/94	2004-069RS	COOK	61	32
STA. 581+75		TO STA. 586+50		
FED. ROAD DIST. NO. 1		ILLINOIS FED. AID PROJECT		

62808

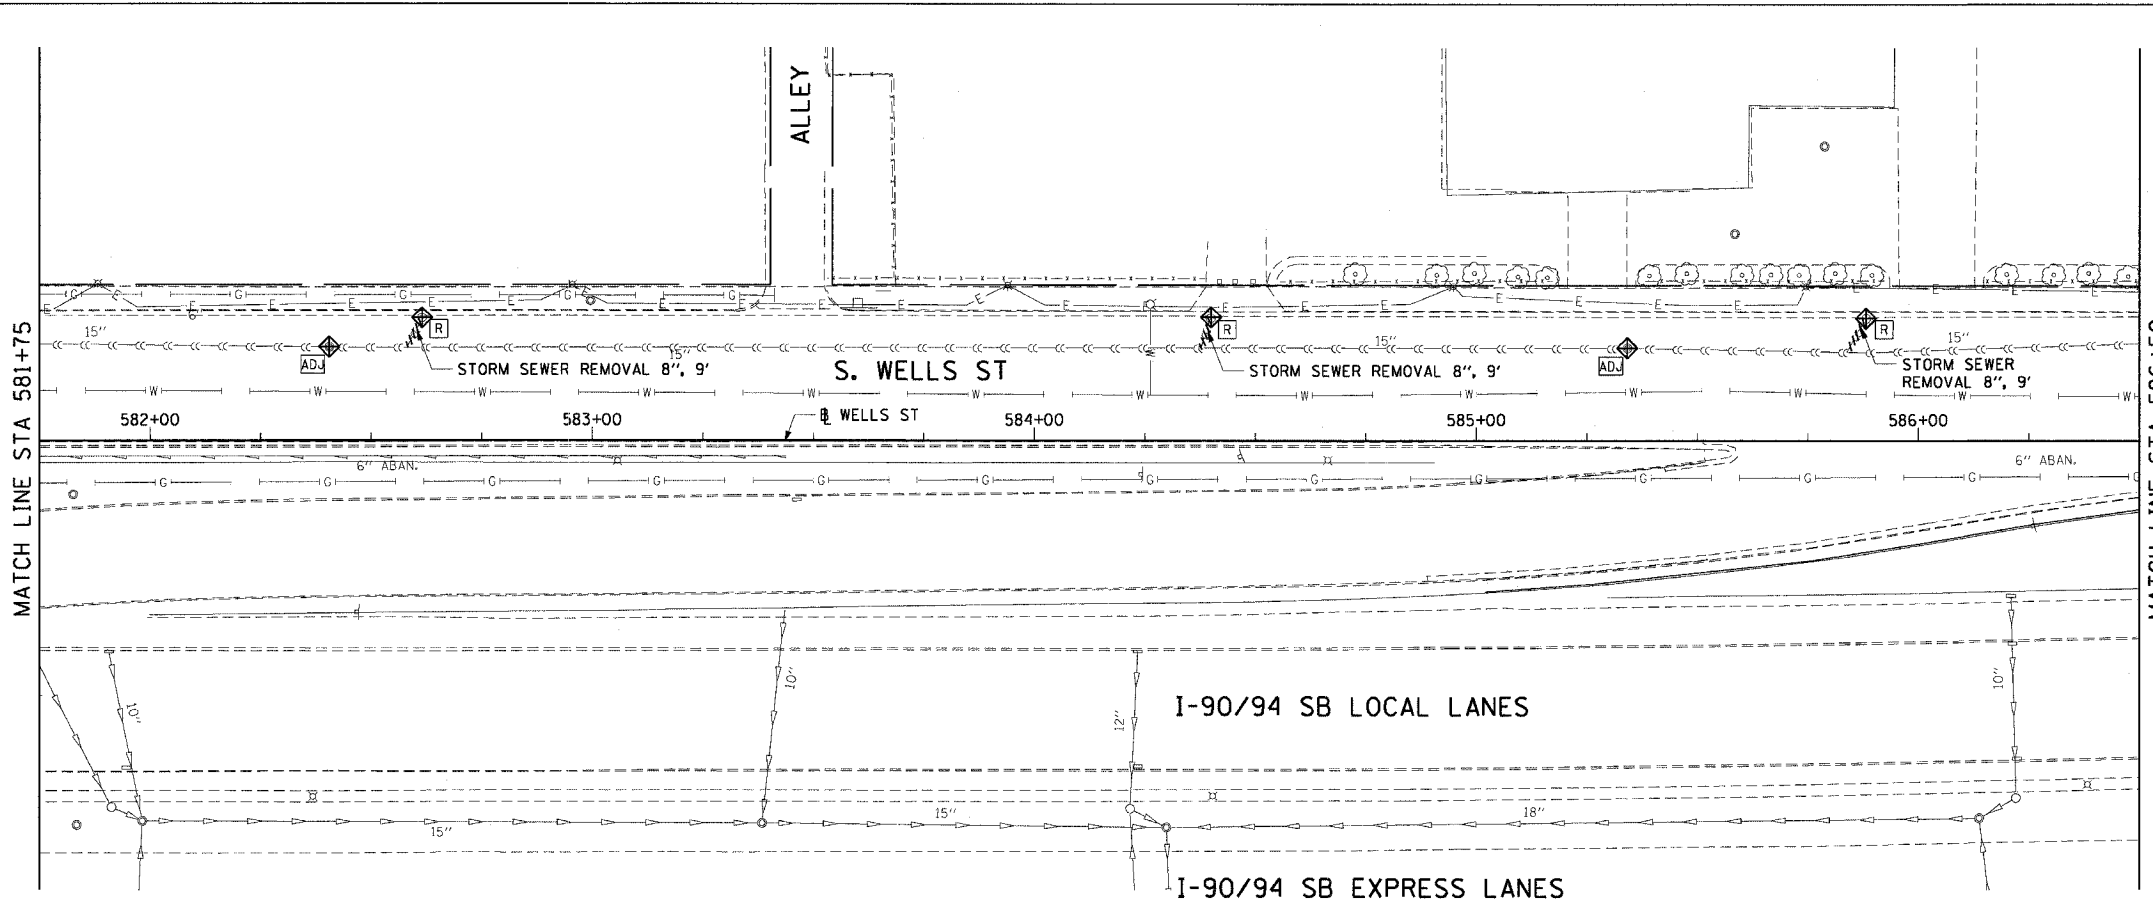

- LEGEND: EXISTING**
- INLET
  - CATCH BASIN
  - MANHOLE
  - STORM SEWER
  - COMBINED SEWER
  - PIPE UNDERDRAIN
  - Ⓜ STRUCTURE TO BE REMOVED
  - ⓂⓂ STRUCTURE TO BE ADJUSTED
  - //// STORM SEWER REMOVAL
  - //// COMBINED SEWER REMOVAL

**NOTE:**  
ALL EXISTING OPEN LID DRAINAGE STRUCTURES TO REMAIN THRU STAGE 2 OF CONTRACT 62586 SHALL HAVE INLET FILTERS INSTALLED.

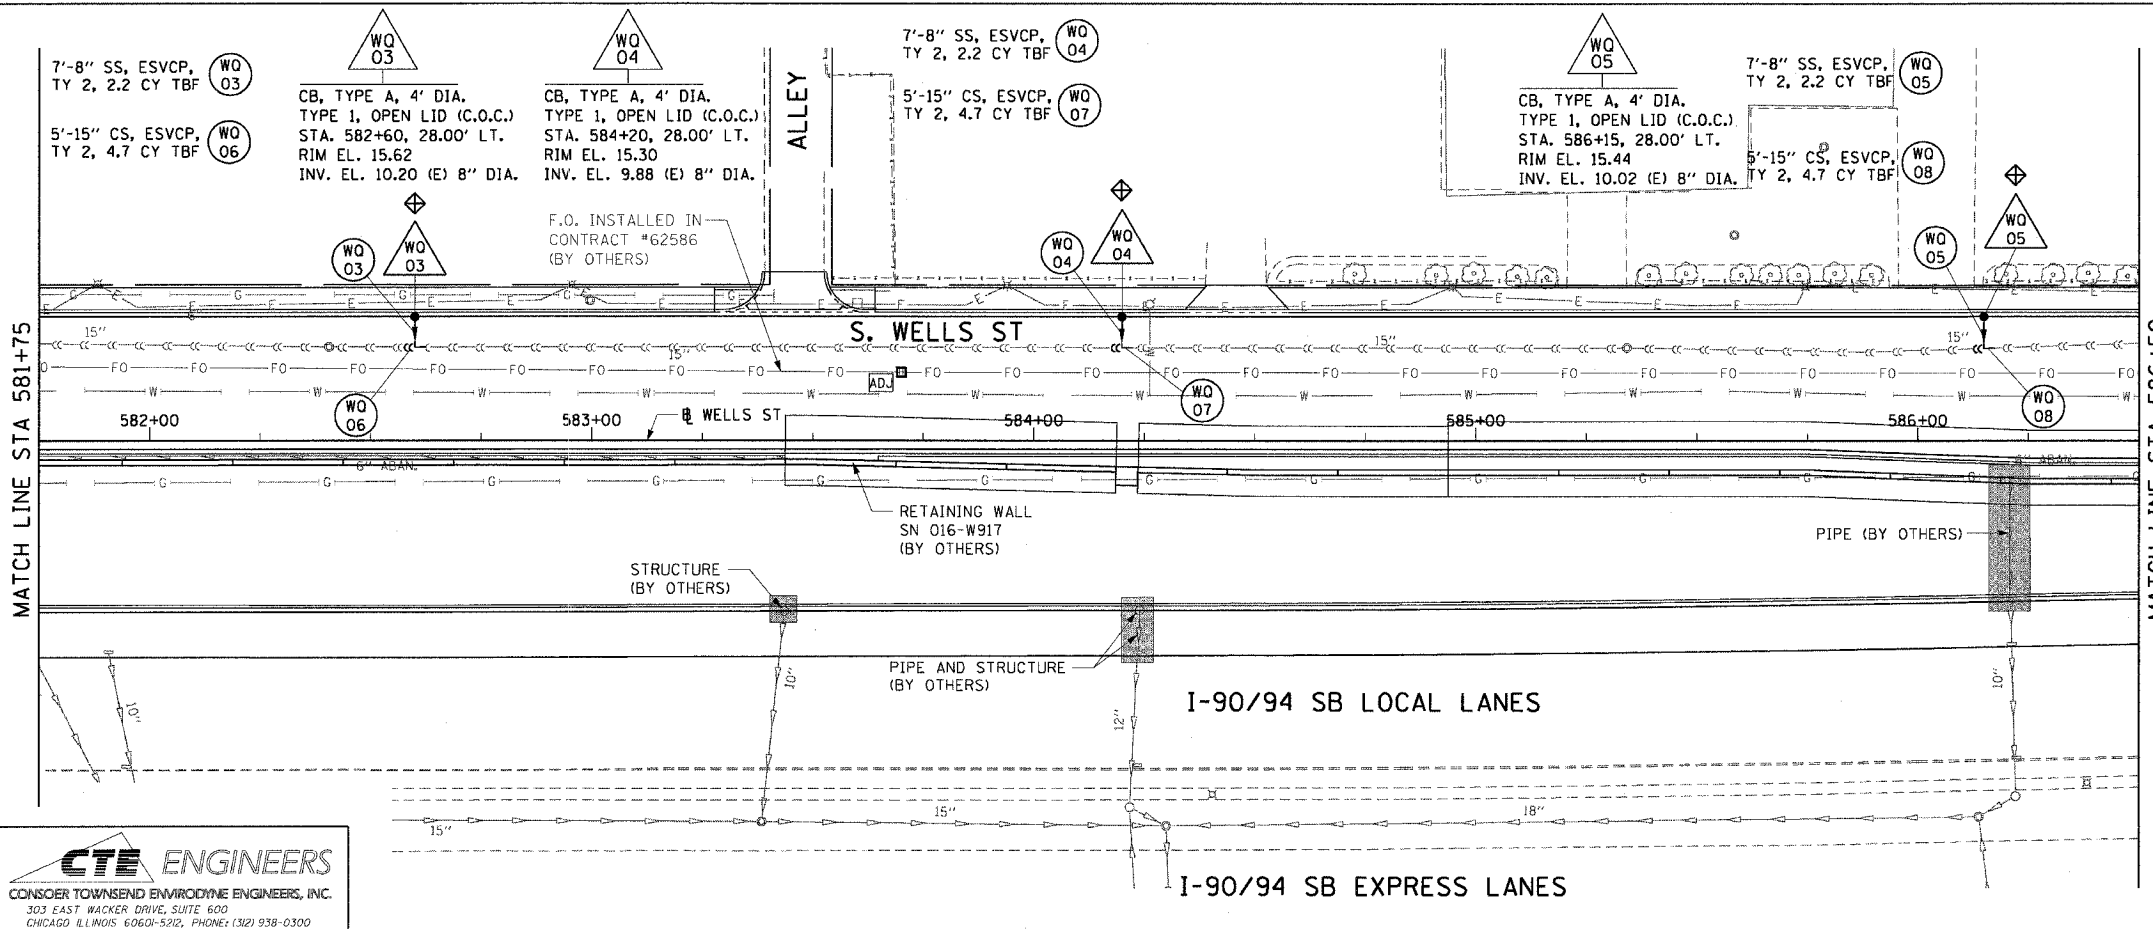

- EXISTING CONDITIONS AND REMOVAL**
- LEGEND: PROPOSED**
- INLET
  - CATCH BASIN
  - MANHOLE
  - STORM SEWER
  - COMBINED SEWER
  - PIPE UNDERDRAIN
  - PROPOSED SWALE
  - ⓂⓂ PROPOSED STORM SEWER PIPE
  - ⓂⓂ PROPOSED STRUCTURE
  - WORK TO BE DONE BY OTHERS

**NOTES:**  
1. SEE DRAINAGE SCHEDULES FOR STRUCTURE AND PIPE INFORMATION.  
2. INLET FILTERS TO BE INSTALLED ON ALL PROP. DRAINAGE STR.

REVISIONS	
NAME	DATE

ILLINOIS DEPARTMENT OF TRANSPORTATION  
F.A.I. 90/94 (DAN RYAN EXPRESSWAY)  
53rd ST TO 51st ST (WELLS STREET)

**DRAINAGE AND UTILITY PLANS  
WELLS STREET**

SCALE: 1"=20'  
DATE: December 17, 2004  
DRAWN BY: PHP  
CHECKED BY: JB

**CTE ENGINEERS**  
CONSER TOWNSEND ENVIRONMENTAL ENGINEERS, INC.  
303 EAST WACKER DRIVE, SUITE 600  
CHICAGO, ILLINOIS 60601-5202, PHONE: (312) 938-0300

12/15/2004 4:28:08 PM