


F.A.I. NO.	SECTION	COUNTY	TOTAL SHEETS	SHEET NO.
90/94	2004-070RS	COOK	60	30
STA. 171+33.51		TO STA. 173+00		
FED. ROAD DIST. NO. 1 ILLINOIS FED. AID PROJECT				

62809

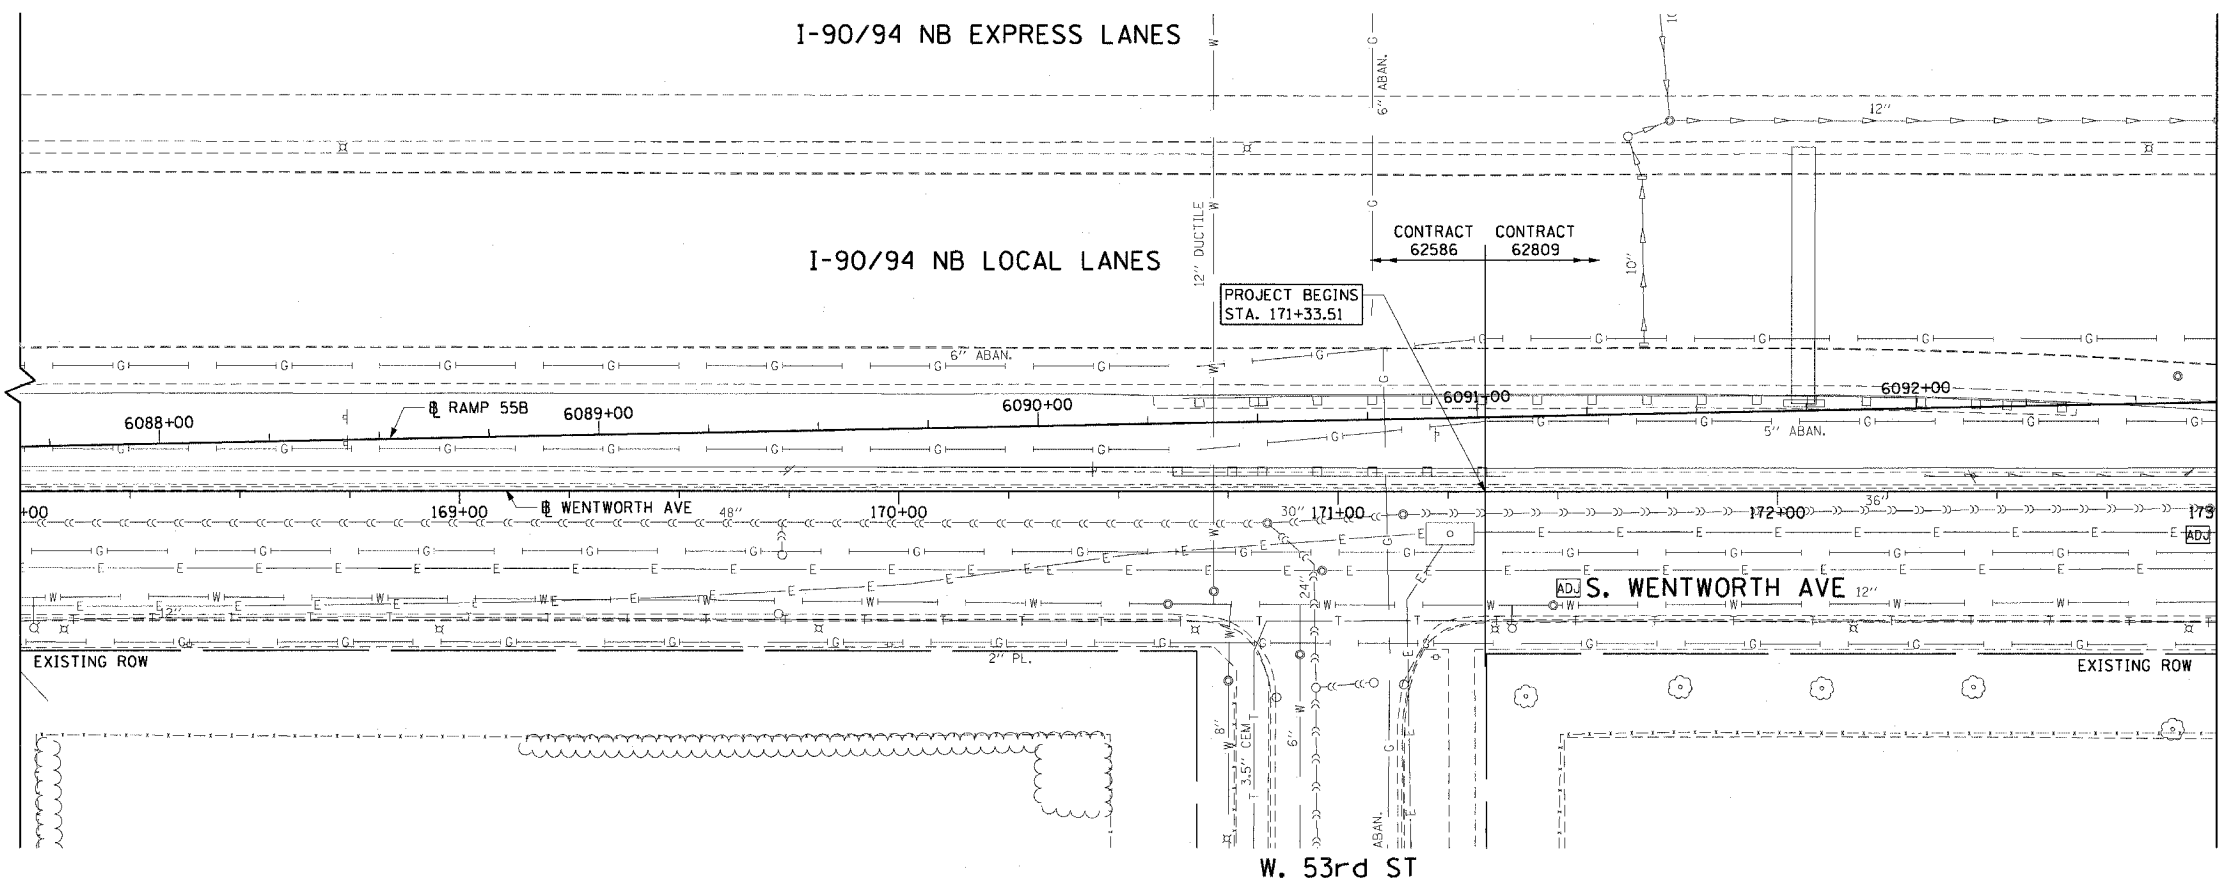


- LEGEND: EXISTING**
- INLET
 - CATCH BASIN
 - MANHOLE
 - STORM SEWER
 - COMBINED SEWER
 - PIPE UNDERDRAIN
 - [R] STRUCTURE TO BE REMOVED
 - [AD] STRUCTURE TO BE ADJUSTED
 - //// STORM SEWER REMOVAL
 - //// COMBINED SEWER REMOVAL

NOTE:
ALL EXISTING OPEN LID DRAINAGE STRUCTURES TO REMAIN THRU STAGE 2 OF CONTRACT 62586 SHALL HAVE INLET FILTERS INSTALLED.

MATCH LINE STA 173+00

EXISTING CONDITIONS AND REMOVAL
PROPOSED IMPROVEMENTS

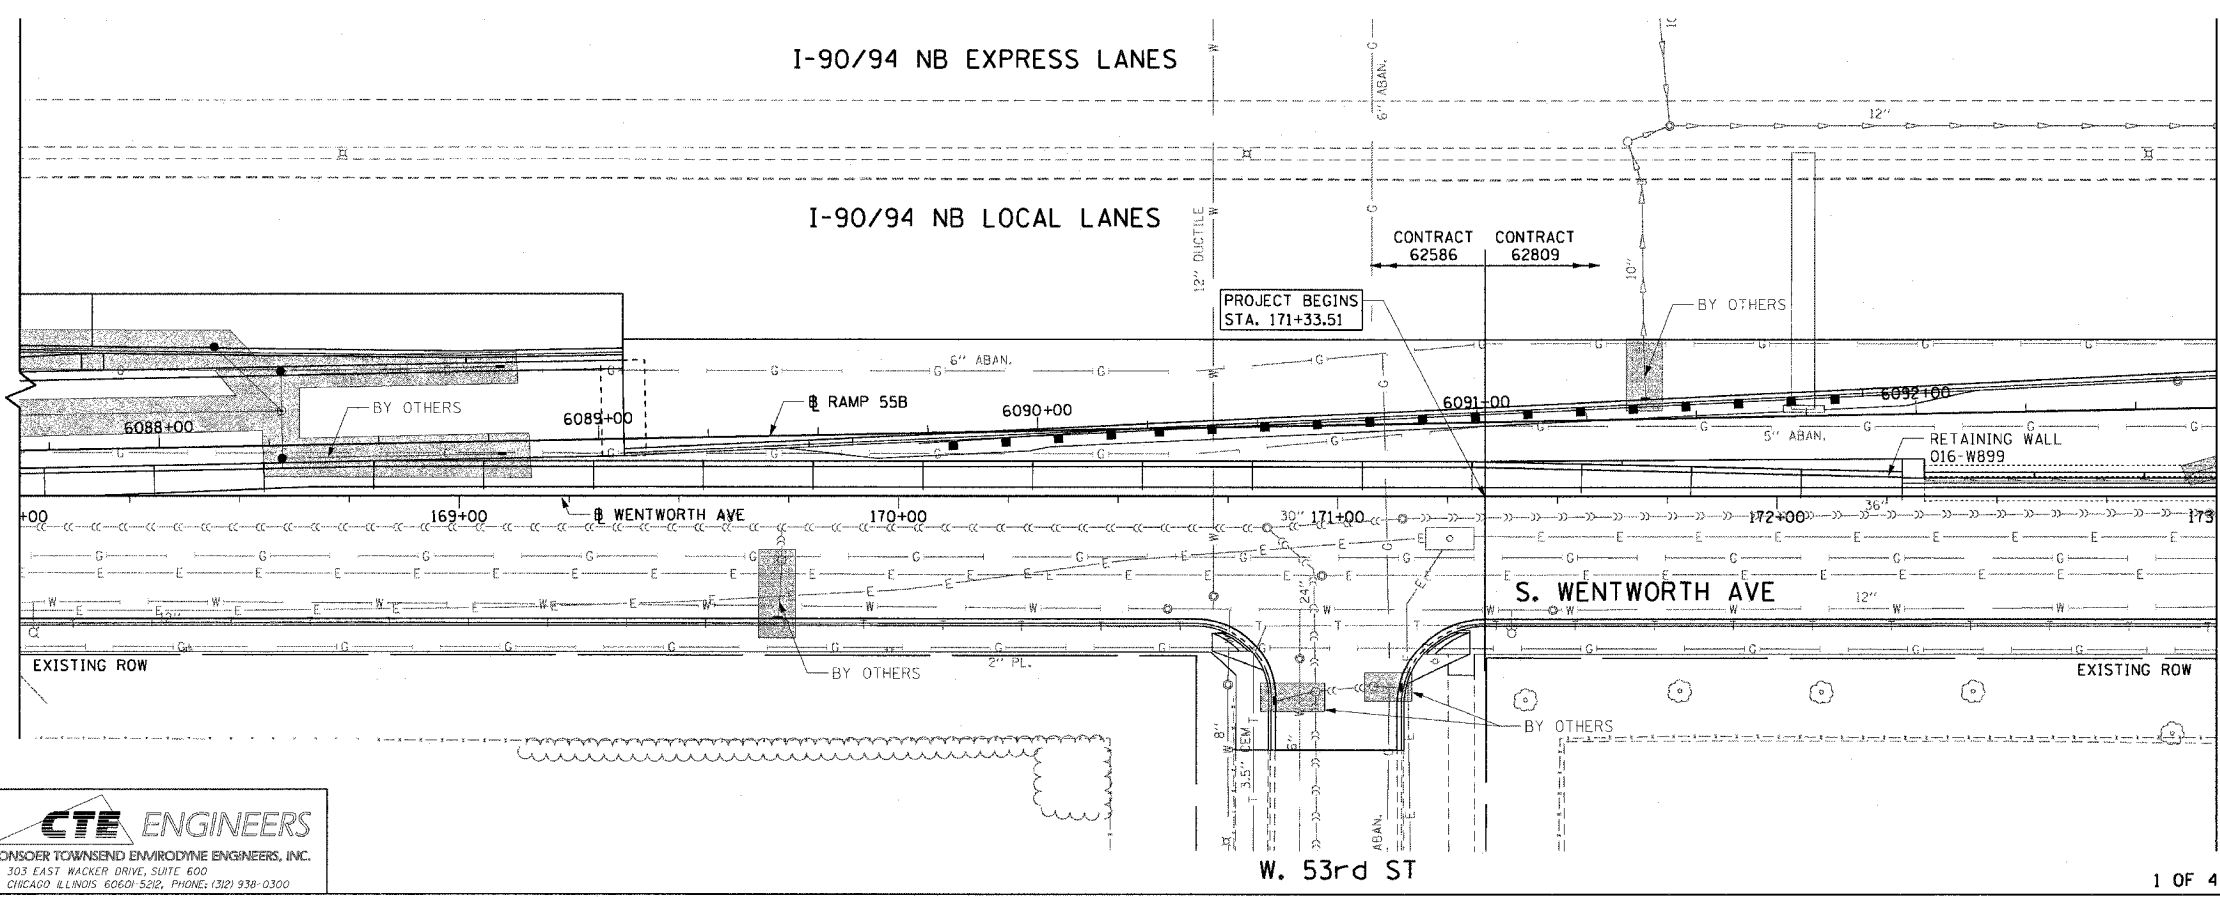

- LEGEND: PROPOSED**
- INLET
 - CATCH BASIN
 - MANHOLE
 - STORM SEWER
 - COMBINED SEWER
 - PIPE UNDERDRAIN
 - PROPOSED SWALE
 - (EA 01) PROPOSED STORM SEWER PIPE
 - (EA 01) PROPOSED STRUCTURE
 - WORK TO BE DONE BY OTHERS
 - ◊ INLET FILTER

- NOTES:**
- SEE DRAINAGE SCHEDULE FOR STRUCTURE AND PIPE INFORMATION.
 - INLET FILTERS TO BE INSTALLED ON ALL PROPOSED DRAINAGE STRUCTURES.

MATCH LINE STA 173+00

REVISIONS	
NAME	DATE

ILLINOIS DEPARTMENT OF TRANSPORTATION
F.A.I. 90/94 (DAN RYAN EXPRESSWAY)
53rd ST TO 51st ST (WENTWORTH AVENUE)

DRAINAGE AND UTILITY PLANS
WENTWORTH AVENUE

SCALE: 1"=20'
DATE: DECEMBER 17, 2004

DRAWN BY: JB
CHECKED BY: RMG

CTE ENGINEERS
CONSOER TOWNSEND ENVIRONMENTAL ENGINEERS, INC.
303 EAST WACKER DRIVE, SUITE 600
CHICAGO, ILLINOIS 60601-5202, PHONE: (312) 938-0300

12/09/2004 10:44:43 AM