


F.A.I. RTE.	SECTION	COUNTY	TOTAL SHEETS	SHEET NO.
90/94	2004-070RS	COOK	60	31
STA. 173+00		TO STA. 178+00		
FED. ROAD DIST. NO. 1 ILLINOIS FED. AID PROJECT				


62809

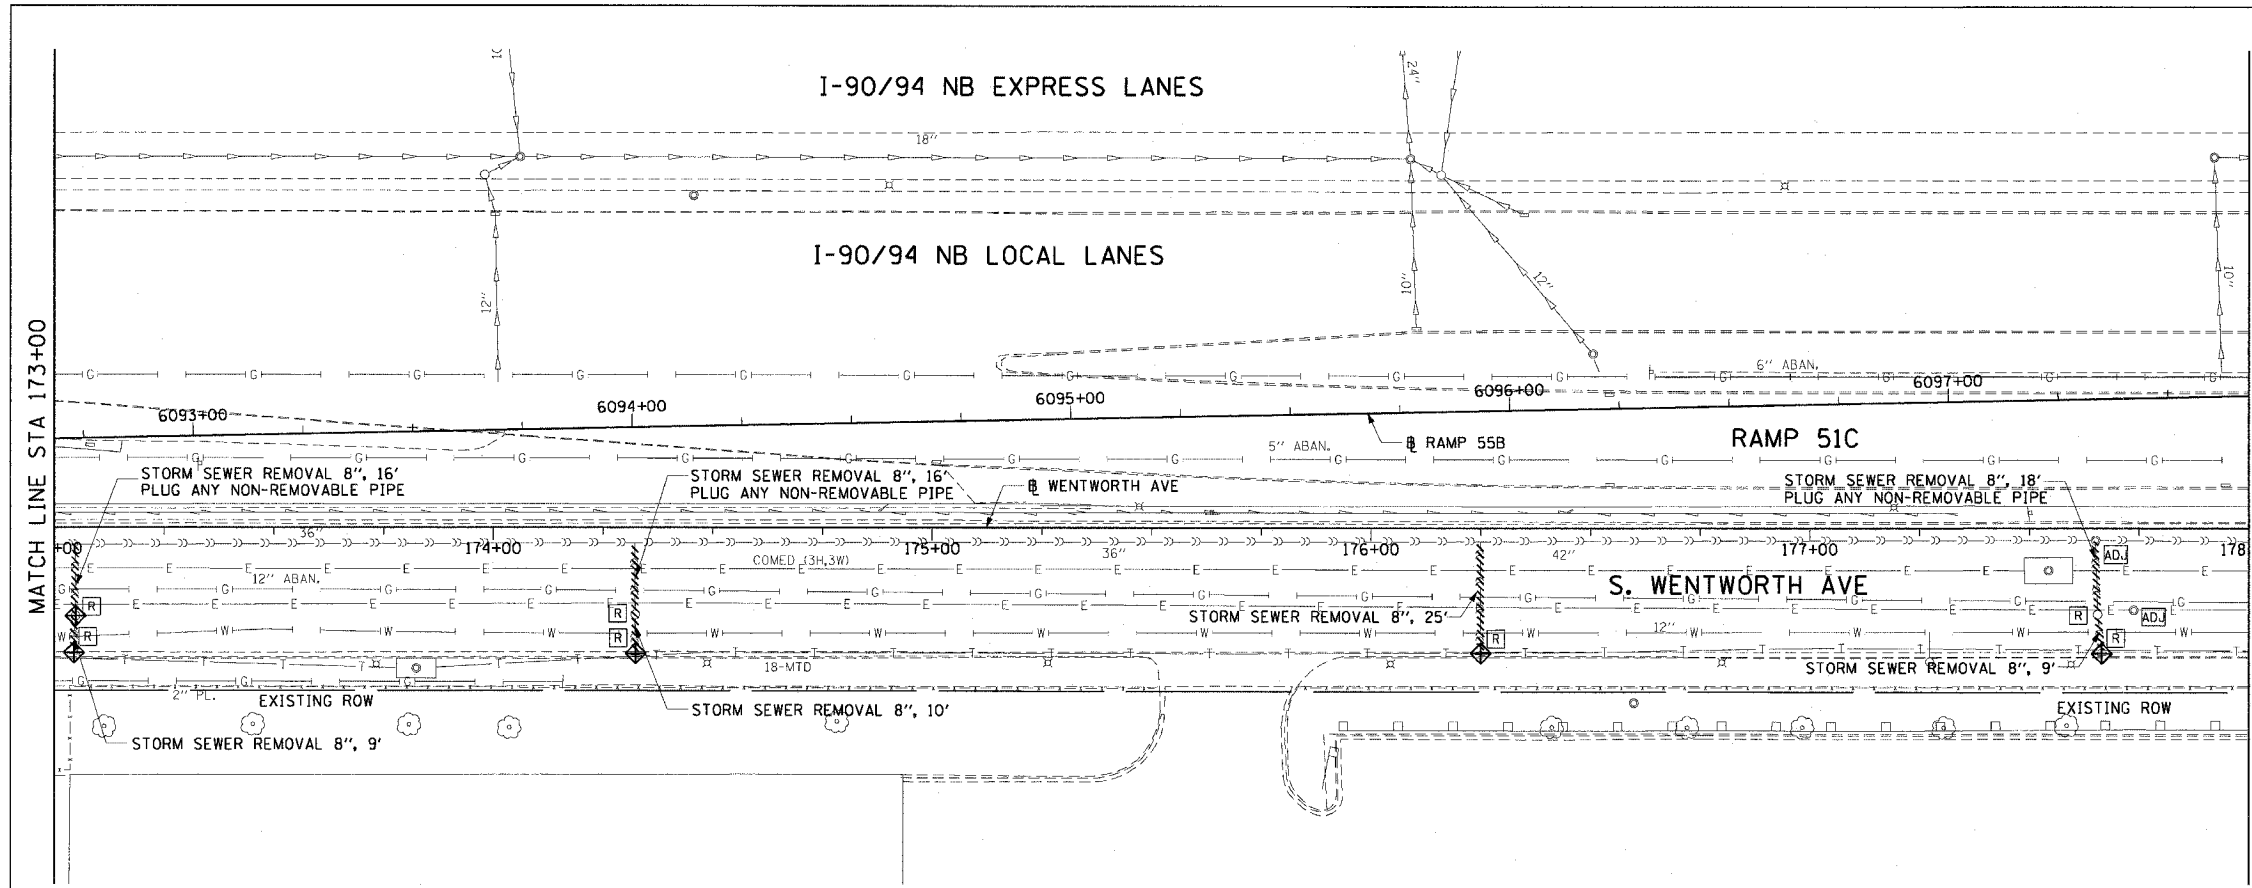

**LEGEND: EXISTING**

- INLET
- CATCH BASIN
- MANHOLE
- STORM SEWER
- COMBINED SEWER
- PIPE UNDERDRAIN
- [R] STRUCTURE TO BE REMOVED
- [ADJ] STRUCTURE TO BE ADJUSTED
- ||||| STORM SEWER REMOVAL
- ||||| COMBINED SEWER REMOVAL

**NOTE:**  
ALL EXISTING OPEN LID DRAINAGE STRUCTURES TO REMAIN THRU STAGE 2 OF CONTRACT 62586 SHALL HAVE INLET FILTERS INSTALLED.

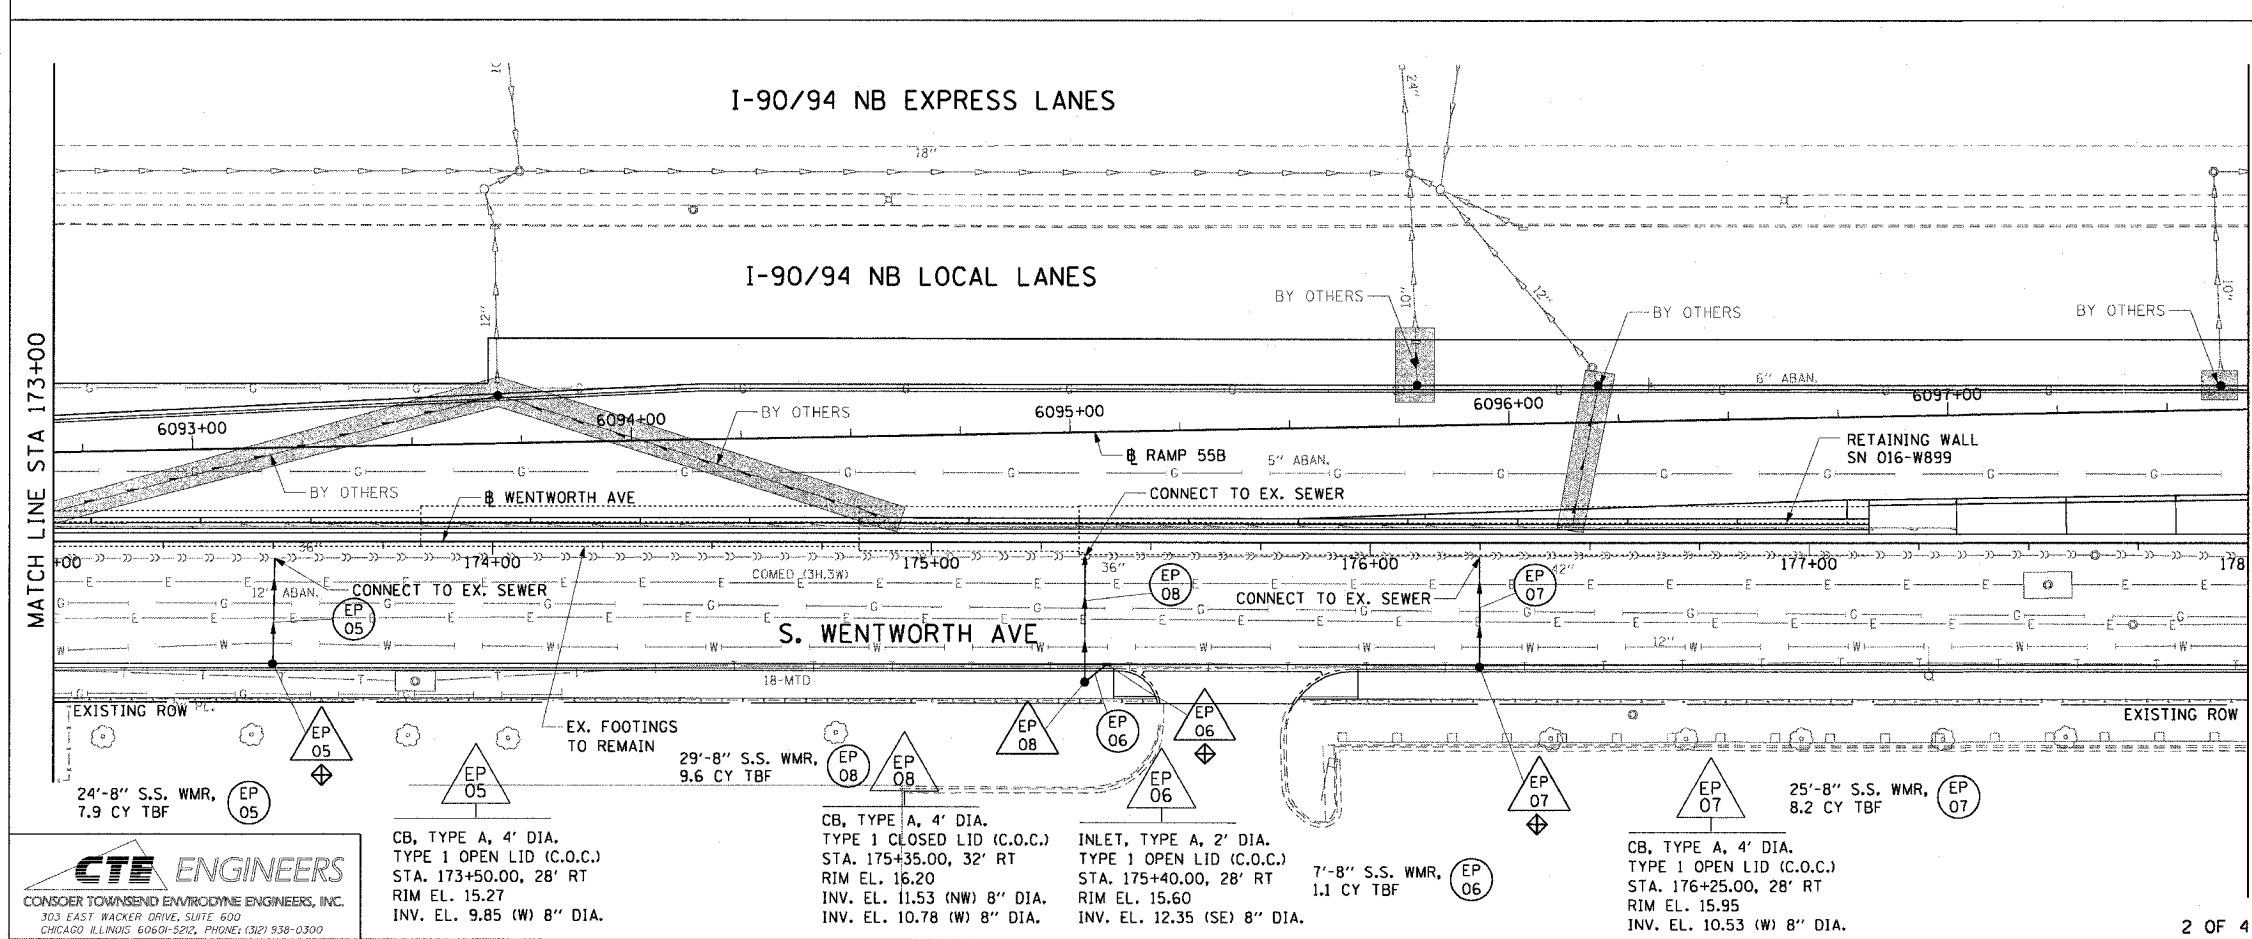

**EXISTING CONDITIONS AND REMOVAL PROPOSED IMPROVEMENTS**

**LEGEND: PROPOSED**

- INLET
- CATCH BASIN
- MANHOLE
- STORM SEWER
- COMBINED SEWER
- PIPE UNDERDRAIN
- PROPOSED SWALE
- ⊕ INLET FILTER
- ⊙ (EA 01) PROPOSED STORM SEWER PIPE
- ⊙ (EA 01) PROPOSED STRUCTURE
- WORK TO BE DONE BY OTHERS

**NOTES:**

- SEE DRAINAGE SCHEDULE FOR STRUCTURE AND PIPE INFORMATION.
- INLET FILTERS TO BE INSTALLED ON ALL PROPOSED DRAINAGE STRUCTURES.

REVISIONS	
NAME	DATE

ILLINOIS DEPARTMENT OF TRANSPORTATION  
F.A.I. 90/94 (DAN RYAN EXPRESSWAY)  
53rd ST TO 51st ST (WENTWORTH AVENUE)

**DRAINAGE AND UTILITY PLANS  
WENTWORTH AVENUE**

SCALE: 1"=20'  
DATE: DECEMBER 17, 2004

DRAWN BY: JB  
CHECKED BY: RMG

**CTE ENGINEERS**  
CONSOER TOWNSEND ENVIRONMENTAL ENGINEERS, INC.  
303 EAST WACKER DRIVE, SUITE 600  
CHICAGO, ILLINOIS 60601-5202, PHONE: (312) 538-0300

12/09/2004 10:44:47 AM