


F.A.I. SHEET NO.	SECTION	COUNTY	TOTAL SHEETS	SHEET NO.
90/94	2004-071RS	COOK	54	28
STA. 592+93.53 TO STA. 596+25		FED. ROAD DIST. NO. 1 ILLINOIS FED. AID PROJECT		


62810

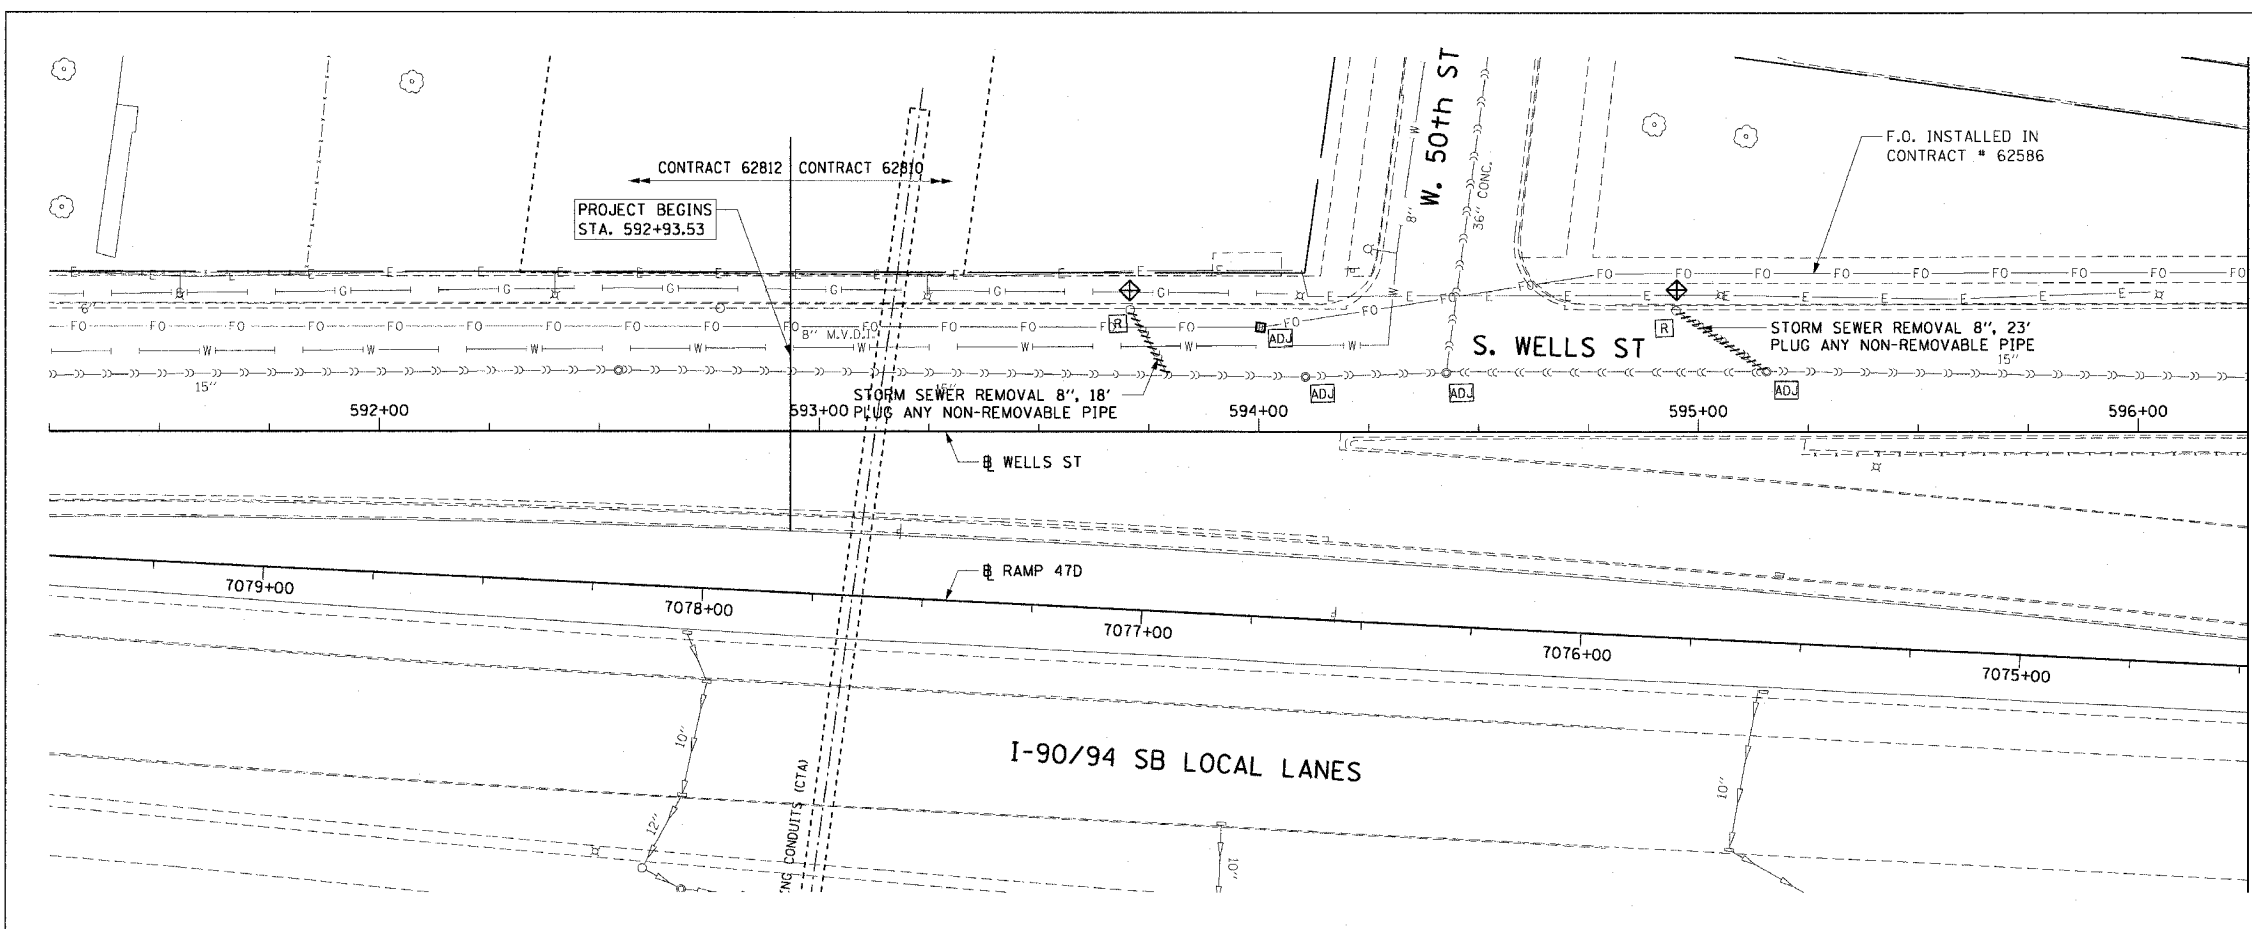

- LEGEND: EXISTING**
- INLET
  - CATCH BASIN
  - MANHOLE
  - STORM SEWER
  - COMBINED SEWER
  - PIPE UNDERDRAIN
  - [R] STRUCTURE TO BE REMOVED
  - [AD] STRUCTURE TO BE ADJUSTED
  - //// STORM SEWER REMOVAL
  - //// COMBINED SEWER REMOVAL
  - ⊕ INLET FILTER

**NOTE:**  
ALL EXISTING OPEN LID DRAINAGE STRUCTURES TO REMAIN THRU STAGE 2 OF CONTRACT 62586 SHALL HAVE INLET FILTERS INSTALLED.

**EXISTING CONDITIONS AND REMOVAL  
PROPOSED IMPROVEMENTS**

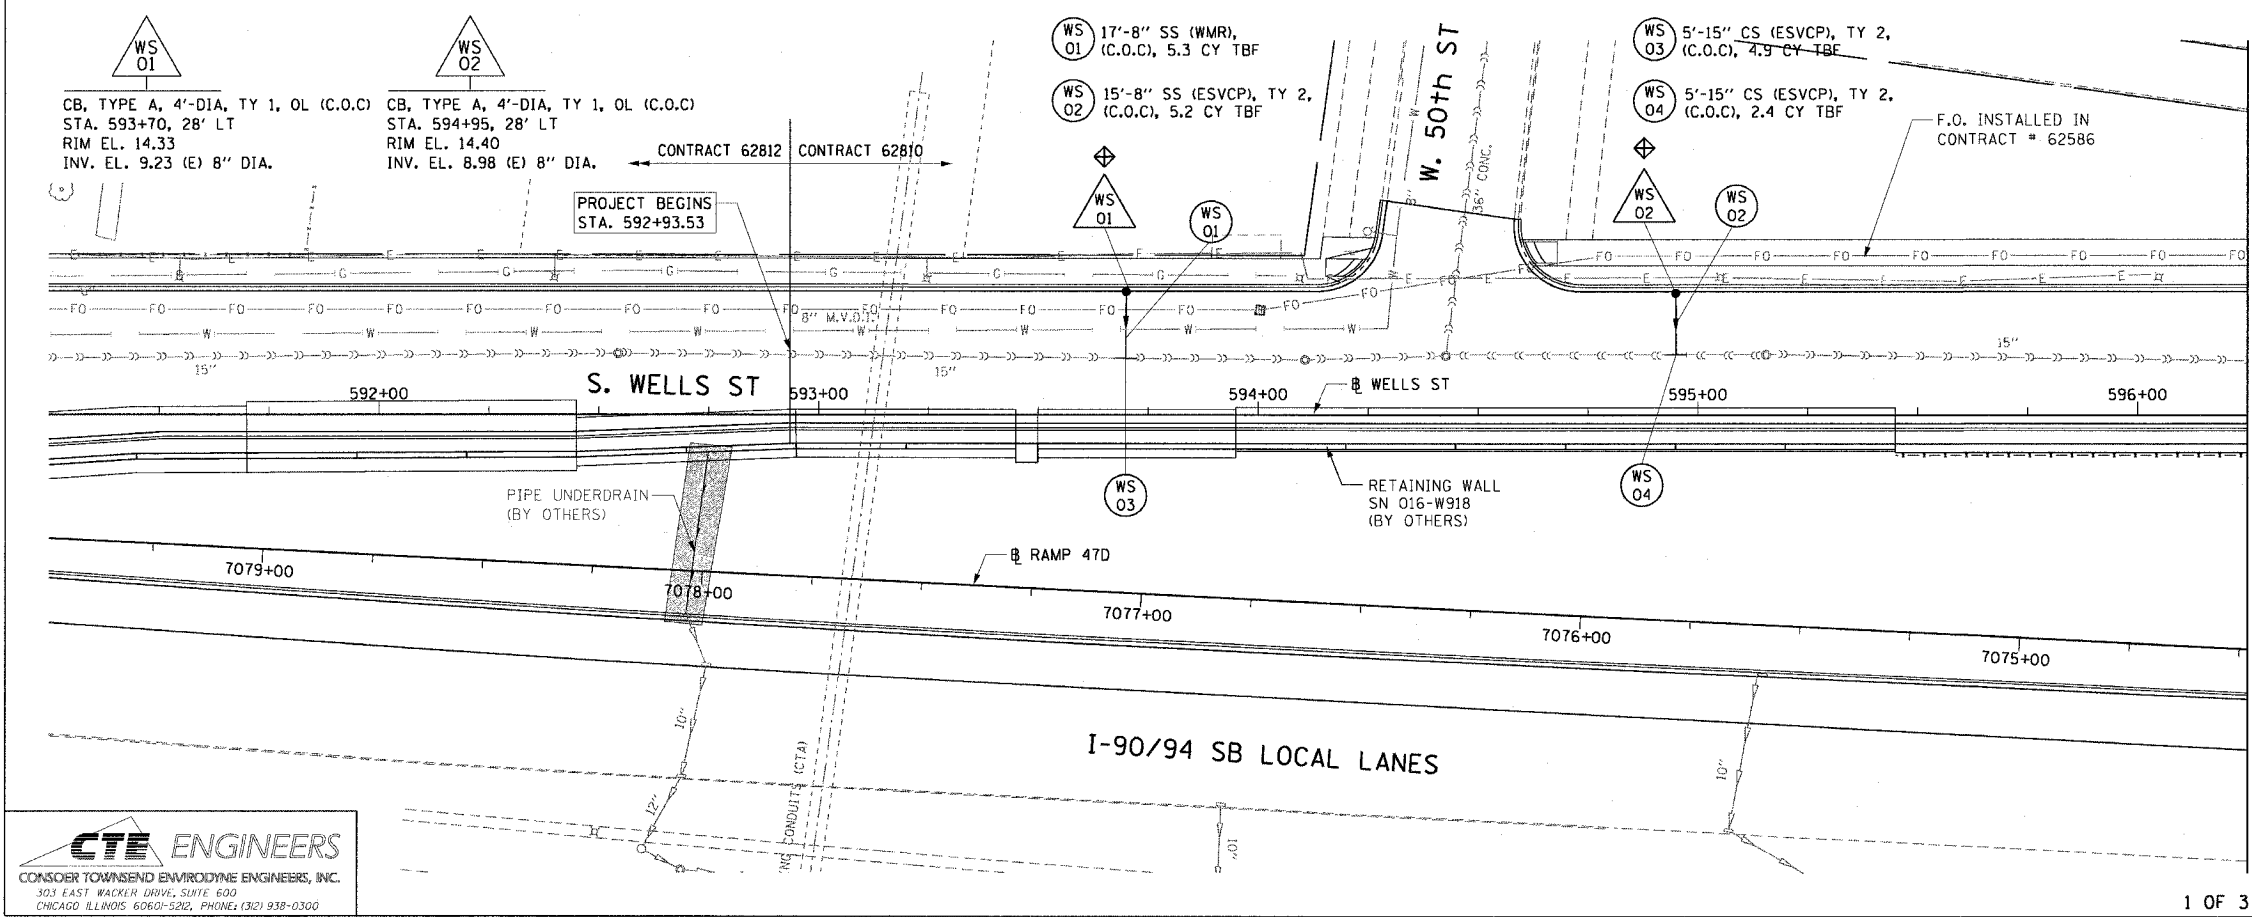

- LEGEND: PROPOSED**
- INLET
  - CATCH BASIN
  - MANHOLE
  - STORM SEWER
  - COMBINED SEWER
  - PIPE UNDERDRAIN
  - PROPOSED SWALE
  - (EA 01) PROPOSED STORM SEWER PIPE
  - △(EA 02) PROPOSED STRUCTURE
  - ⊕ INLET FILTER
  - WORK TO BE DONE BY OTHERS

- NOTES:**
1. INLET FILTERS TO BE INSTALLED ON ALL PROPOSED OPEN-LID DRAINAGE STRUCTURES AND EXISTING OPEN-LID DRAINAGE STRUCTURES THAT SHALL REMAIN IN PLACE DURING STAGE 2 CONSTRUCTION.
  2. CONTRACTOR SHALL COORDINATE WITH THE FIBER OPTIC INSTALLATION IN CONTRACT 62586

REVISIONS	
NAME	DATE

ILLINOIS DEPARTMENT OF TRANSPORTATION  
F.A.I. 90/94 (DAN RYAN EXPRESSWAY)  
51st ST TO 48th PL (WELLS STREET)

**DRAINAGE AND UTILITY PLANS  
WELLS STREET**

SCALE: 1"=20'  
DATE: December 17, 2004

DRAWN BY: JB  
CHECKED BY: N.J.H.

**CTE ENGINEERS**  
CONSIDER TOWNSEND ENVIRONMENTAL ENGINEERS, INC.  
303 EAST WACKER DRIVE, SUITE 600  
CHICAGO, ILLINOIS 60601-5202, PHONE: (312) 938-0300

12/19/2004 9:06:05 AM