
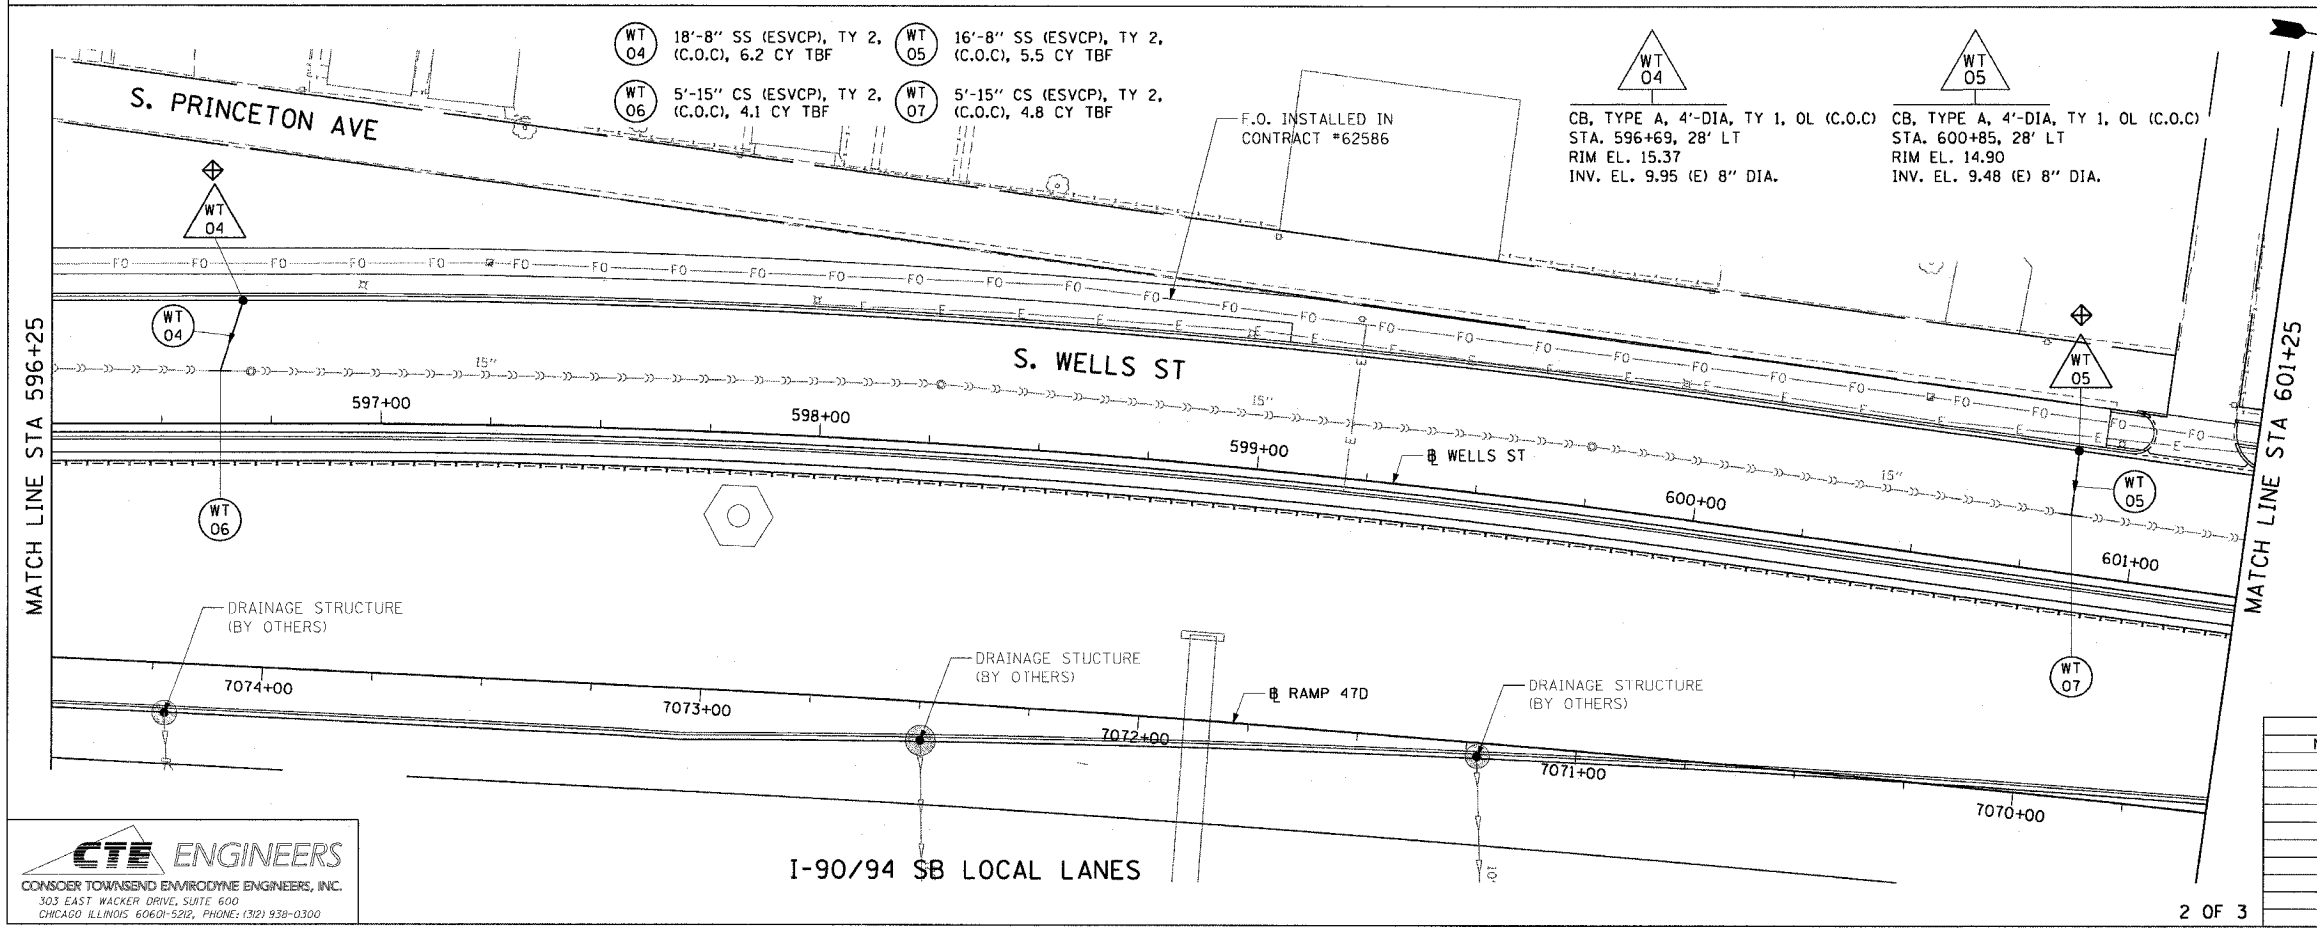


F.A.I. RTE.	SECTION	COUNTY	TOTAL SHEETS	SHEET NO.
90/94	2004-07/RS	COOK	54	29
STA. 596+25		TO STA. 601+25		
FED. ROAD DIST. NO. 1 ILLINOIS FED. AID PROJECT				

62810

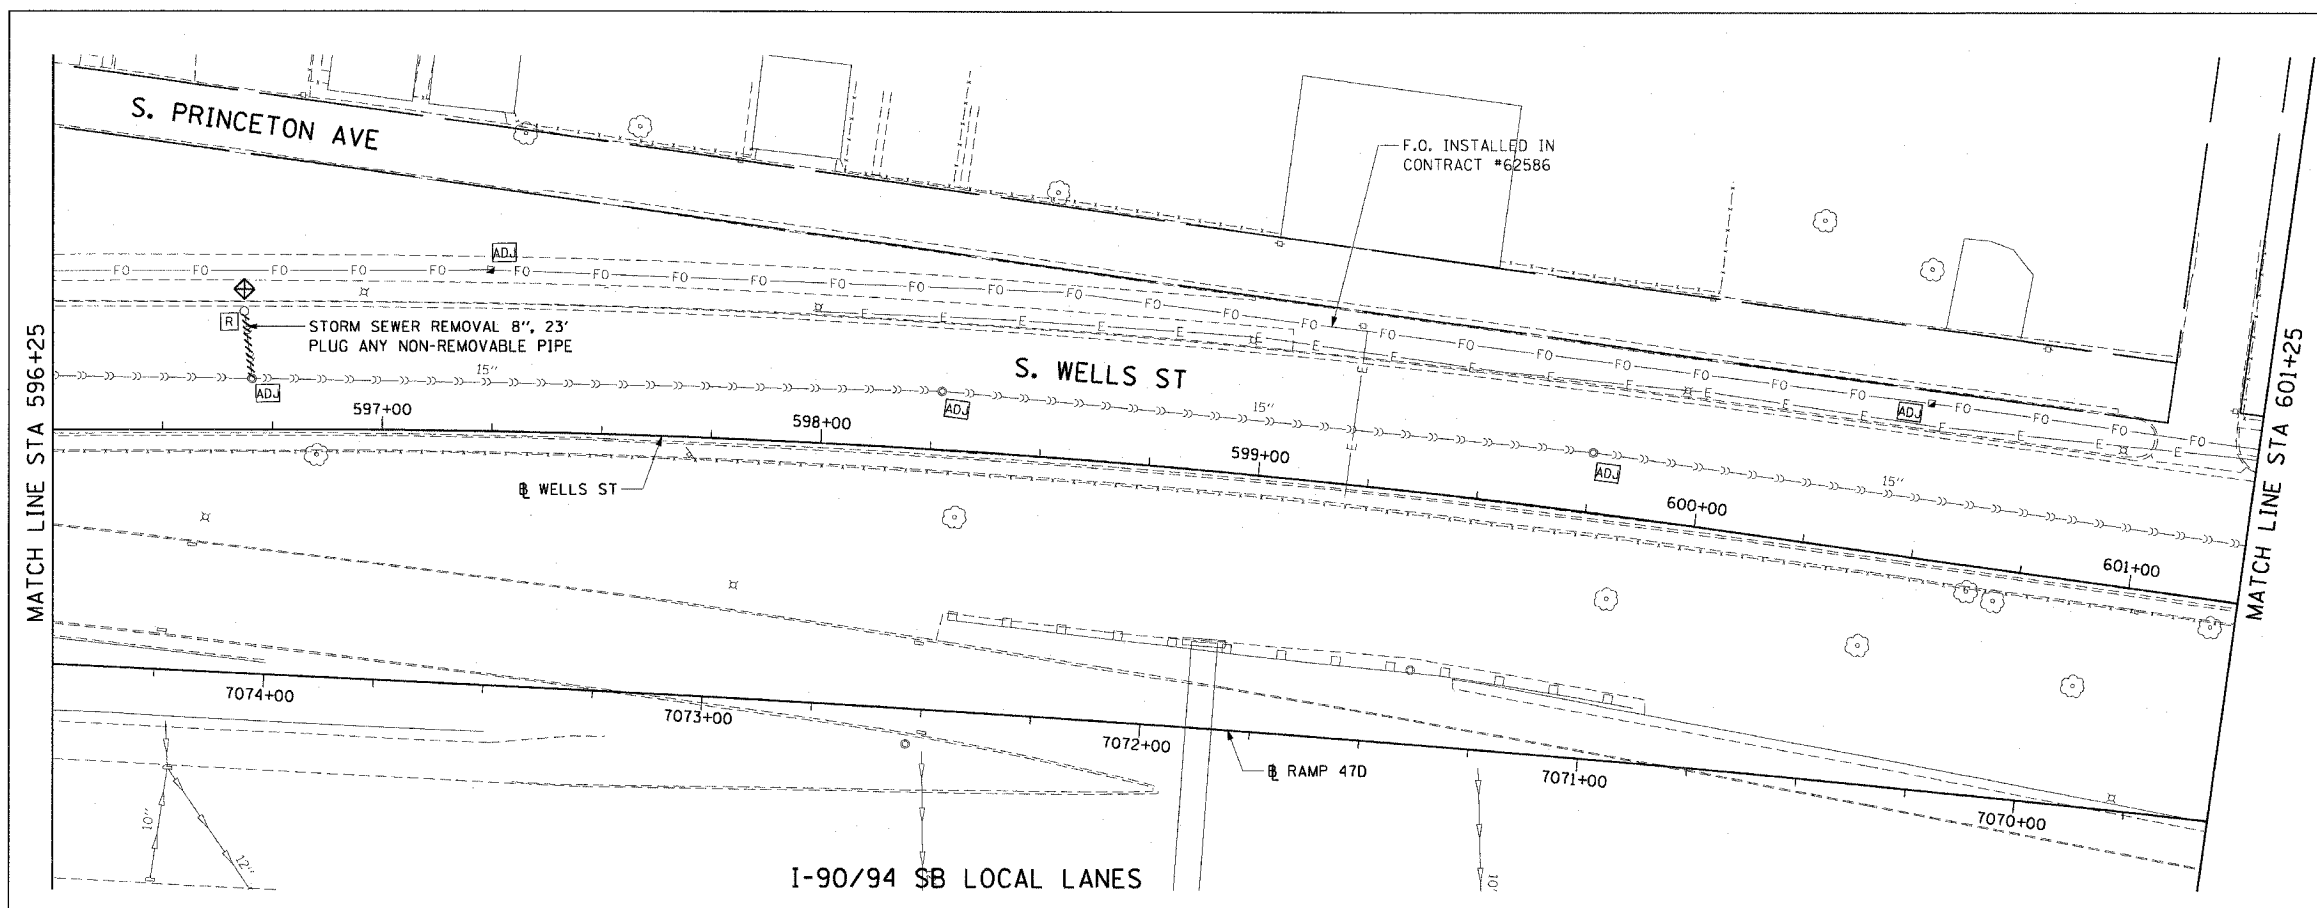

CTE ENGINEERS
CONSOER TOWNSEND ENVIRONMENTAL ENGINEERS, INC.
303 EAST WACKER DRIVE, SUITE 600
CHICAGO, ILLINOIS 60601-5261, PHONE: (312) 938-0300

REVISIONS	
NAME	DATE

ILLINOIS DEPARTMENT OF TRANSPORTATION
F.A.I. 90/94 (DAN RYAN EXPRESSWAY)
51st ST TO 48th PL (WELLS STREET)

**DRAINAGE AND UTILITY PLANS
WELLS STREET**

SCALE: 1"=20'
DATE: December 17, 2004

DRAWN BY: JB
CHECKED BY: NJH