


F.A.I. RTE.	SECTION	COUNTY	TOTAL SHEETS	SHEET NO.
90/94	2004-071RS	COOK	54	30
STA. 601+25		TO STA. 602+87.24		
FED. ROAD DIST. NO. 1		ILLINOIS	FED. AID PROJECT	


62810

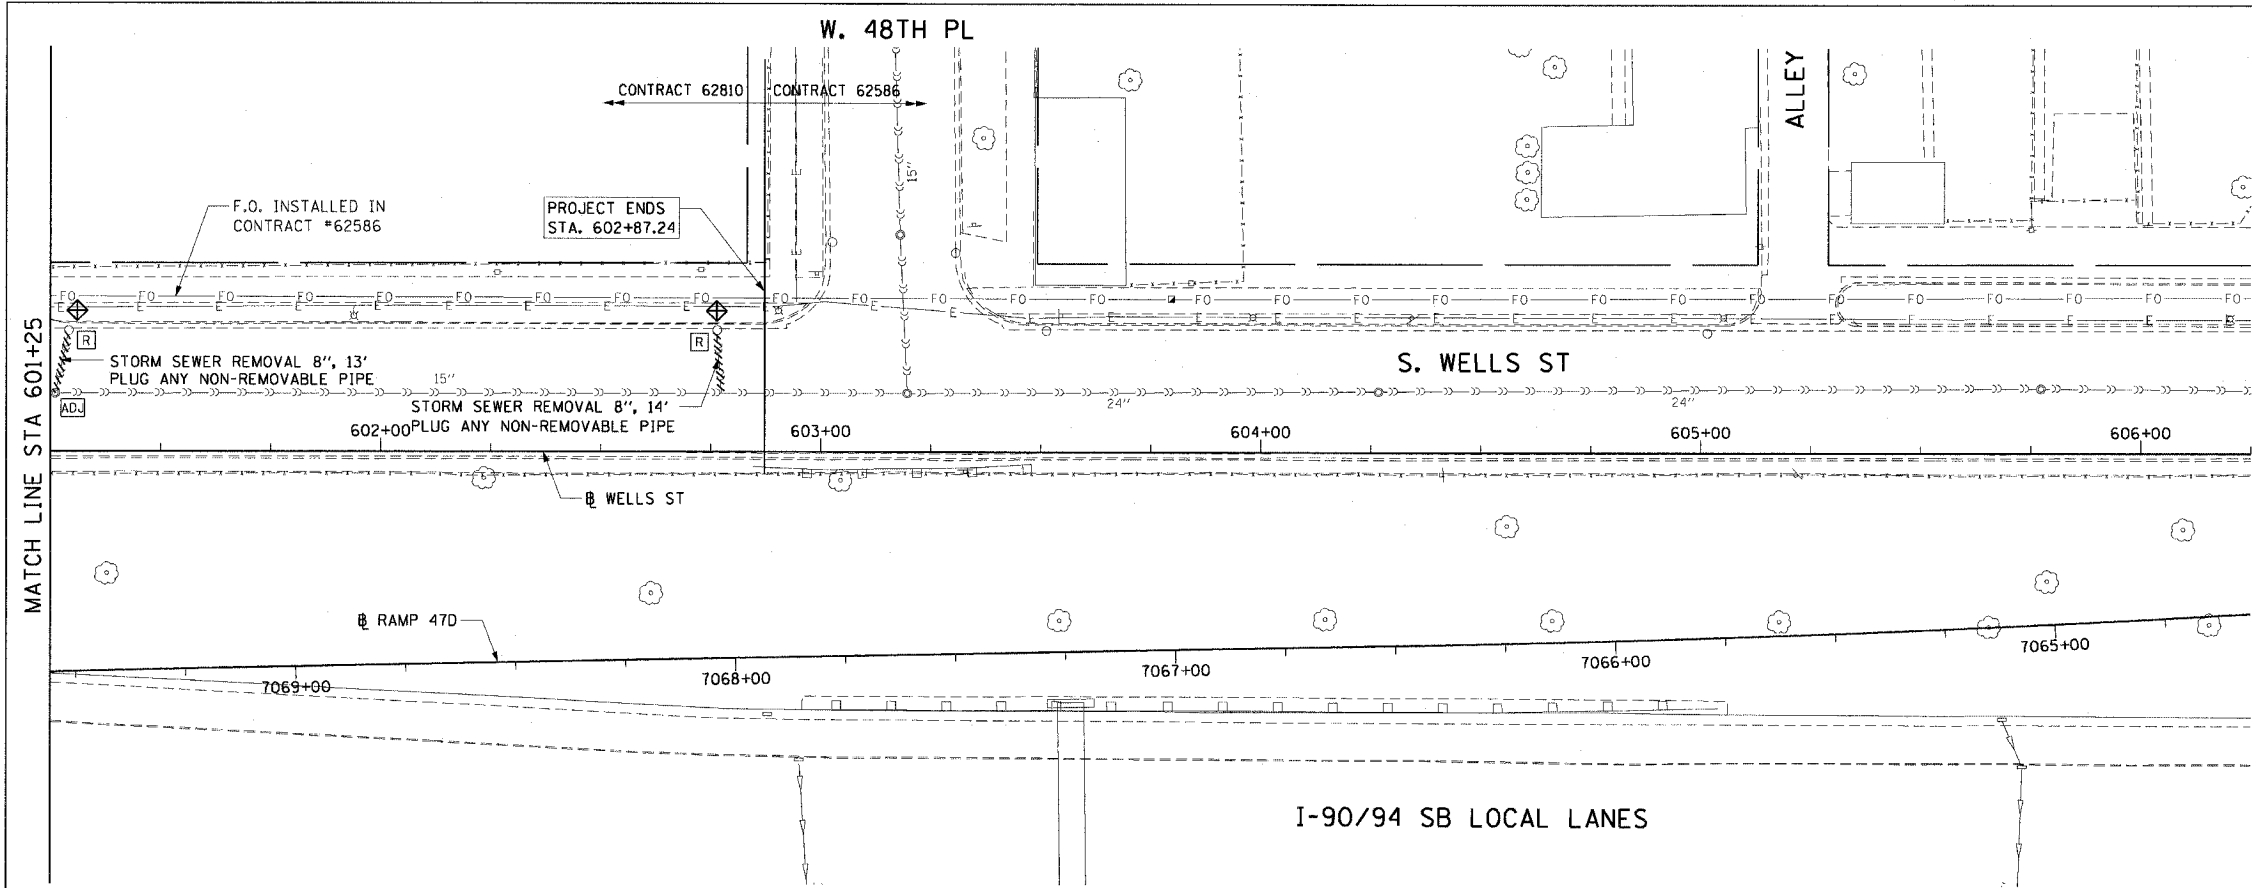

LEGEND: EXISTING

- INLET
- CATCH BASIN
- MANHOLE
- STORM SEWER
- COMBINED SEWER
- PIPE UNDERDRAIN
- [R] STRUCTURE TO BE REMOVED
- [AD] STRUCTURE TO BE ADJUSTED
- //// STORM SEWER REMOVAL
- //// COMBINED SEWER REMOVAL
- ⊕ INLET FILTER

NOTE:
ALL EXISTING OPEN LID DRAINAGE STRUCTURES TO REMAIN THRU STAGE 2 OF CONTRACT 62586 SHALL HAVE INLET FILTERS INSTALLED.

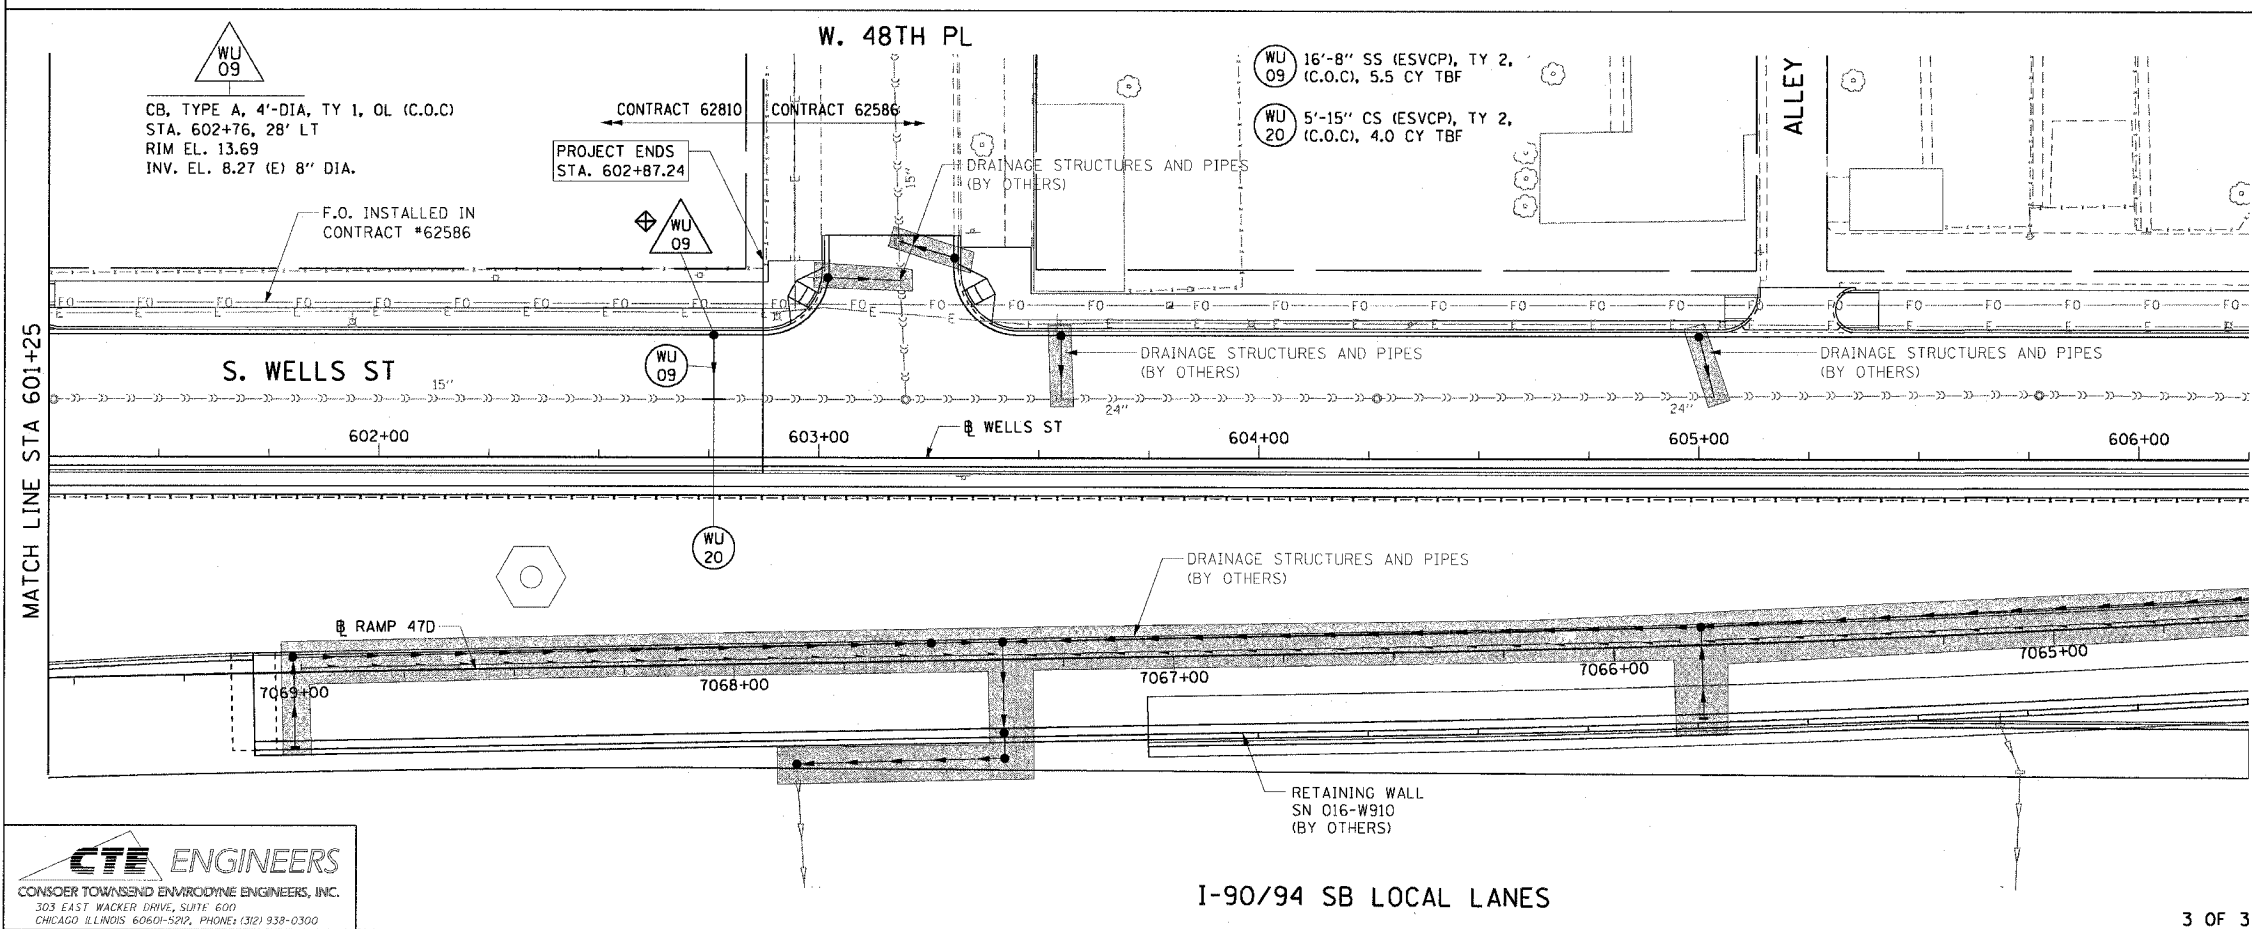

EXISTING CONDITIONS AND REMOVAL PROPOSED IMPROVEMENTS

LEGEND: PROPOSED

- INLET
- CATCH BASIN
- MANHOLE
- STORM SEWER
- COMBINED SEWER
- PIPE UNDERDRAIN
- PROPOSED SWALE
- ⊕ PROPOSED STORM SEWER PIPE
- ⊕ PROPOSED STRUCTURE
- ⊕ INLET FILTER
- WORK TO BE DONE BY OTHERS

- NOTES:
- INLET FILTERS TO BE INSTALLED ON ALL PROPOSED OPEN-LID DRAINAGE STRUCTURES AND EXISTING OPEN-LID DRAINAGE STRUCTURES THAT SHALL REMAIN IN PLACE DURING STAGE 2 CONSTRUCTION.
 - CONTRACTOR SHALL COORDINATE WITH THE FIBER OPTIC INSTALLATION IN CONTRACT 62586

REVISIONS	NAME	DATE

ILLINOIS DEPARTMENT OF TRANSPORTATION
F.A.I. 90/94 (DAN RYAN EXPRESSWAY)
51st ST TO 48th PL (WELLS STREET)

**DRAINAGE AND UTILITY PLANS
WELLS STREET**

SCALE: 1"=20'
DATE: December 17, 2004

DRAWN BY: JB
CHECKED BY: NJH



I-90/94 SB LOCAL LANES

12/19/2004 9:06:42 AM