
 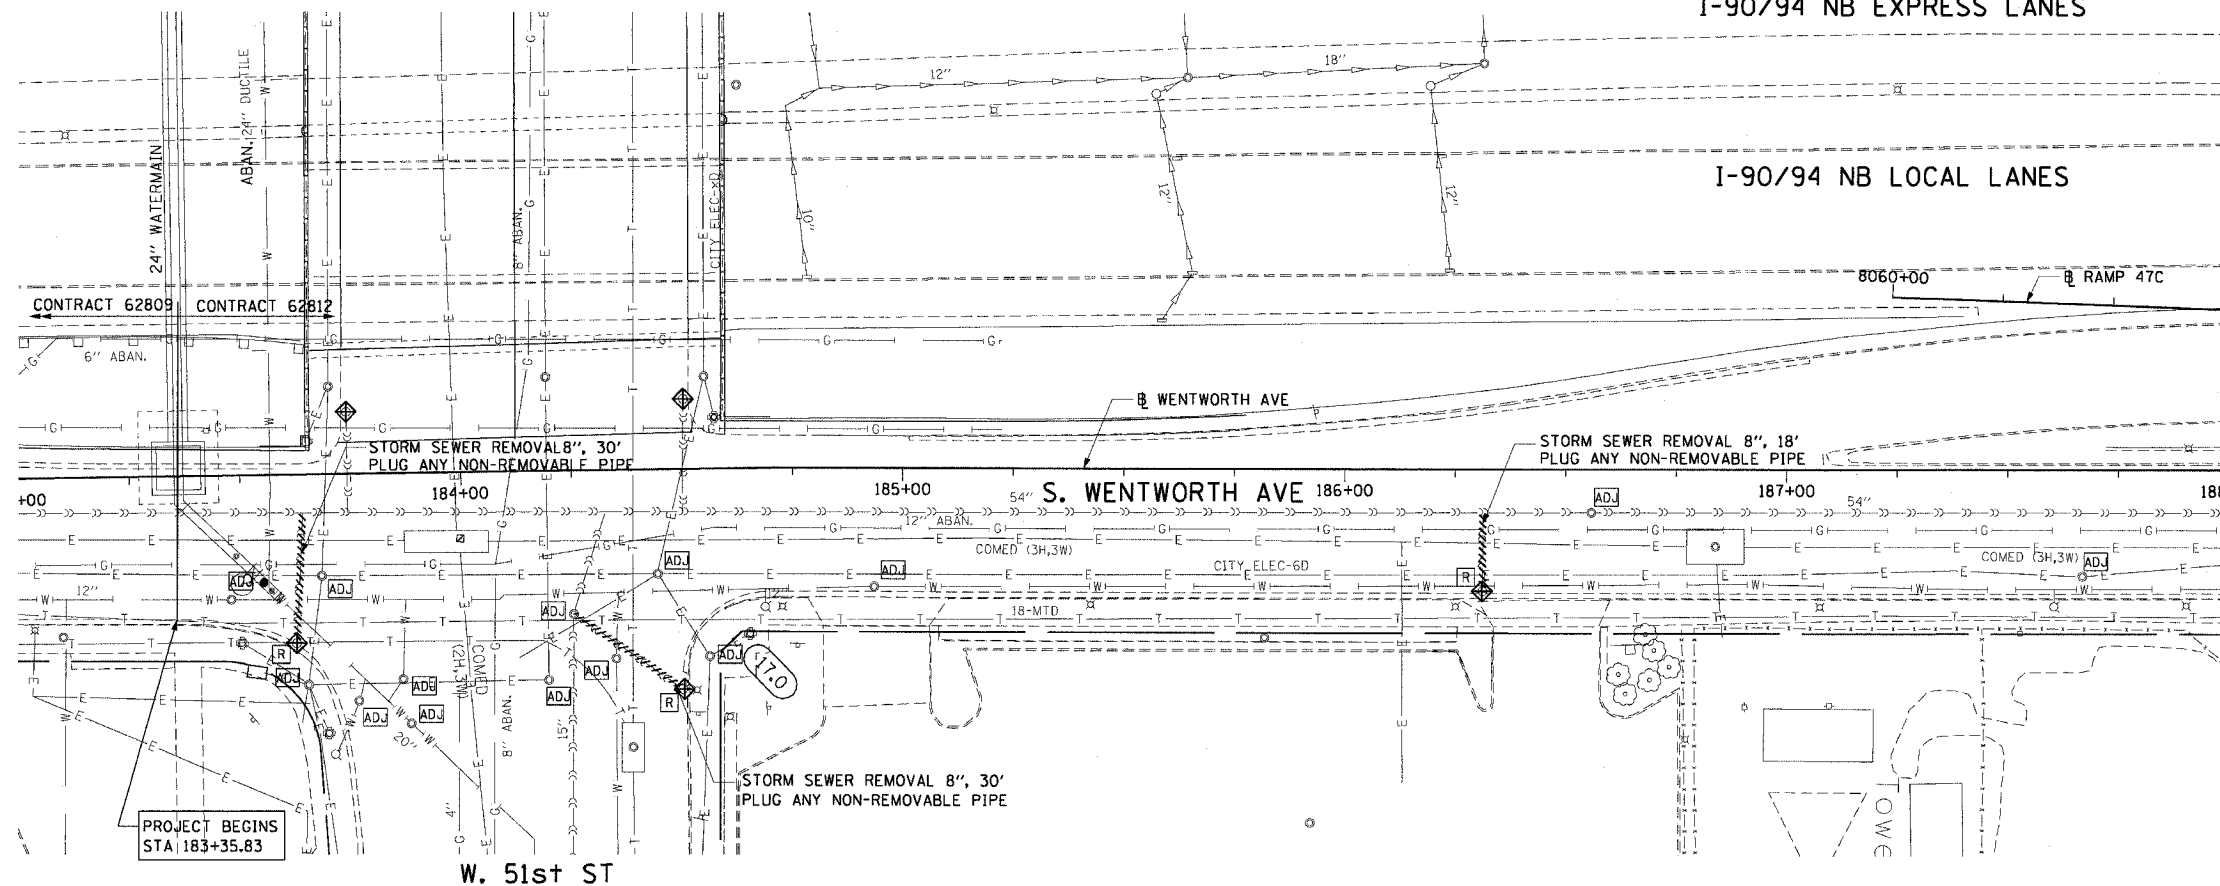


F.A.I. RTE.	SECTION	COUNTY	TOTAL SHEETS	SHEET NO.
90/94	2004-073RS	COOK	74	34
STA. 183+00	TO STA. 188+00			
FED. ROAD DIST. NO. 1 ILLINOIS FED. AID PROJECT				
62812				

I-90/94 NB EXPRESS LANES

I-90/94 NB LOCAL LANES



LEGEND: EXISTING

- INLET
- CATCH BASIN
- MANHOLE
- STORM SEWER
- COMBINED SEWER
- PIPE UNDERDRAIN
- [R] STRUCTURE TO BE REMOVED
- [ADJ] STRUCTURE TO BE ADJUSTED
- //// STORM SEWER REMOVAL
- //// ABANDON STORM SEWER

NOTE:
ALL EXISTING OPEN LID DRAINAGE STRUCTURES TO REMAIN THRU STAGE 2 OF CONTRACT 62586 SHALL HAVE INLET FILTERS INSTALLED.

EXISTING CONDITIONS AND REMOVAL

PROPOSED IMPROVEMENTS

LEGEND: PROPOSED


- INLET
- CATCH BASIN
- MANHOLE
- STORM SEWER
- COMBINED SEWER
- PIPE UNDERDRAIN
- PROPOSED SWALE
- EA 01 PROPOSED STORM SEWER PIPE
- △ EA 01 PROPOSED STRUCTURE
- WORK TO BE DONE BY OTHERS
- ◆ INLET FILTERS
- HANDHOLE

NOTES:

- SEE DRAINAGE SCHEDULES FOR ADDITIONAL STRUCTURE AND PIPE INFORMATION.
- INLET FILTERS TO BE INSTALLED ON ALL PROPOSED DRAINAGE STRUCTURES.
- THE CONTRACTOR SHALL USE ALL MEANS NECESSARY TO PROTECT THE EXISTING CONDUIT FROM DAMAGE DURING CONCRETE REMOVAL IN THIS AREA. THE CONTRACTOR IS RESPONSIBLE FOR REPLACING ALL CONDUIT AND WIRES DAMAGED DURING THE CONSTRUCTION WORK AT NO ADDITIONAL COST TO IDOT.

I-90/94 NB EXPRESS LANES

I-90/94 NB LOCAL LANES

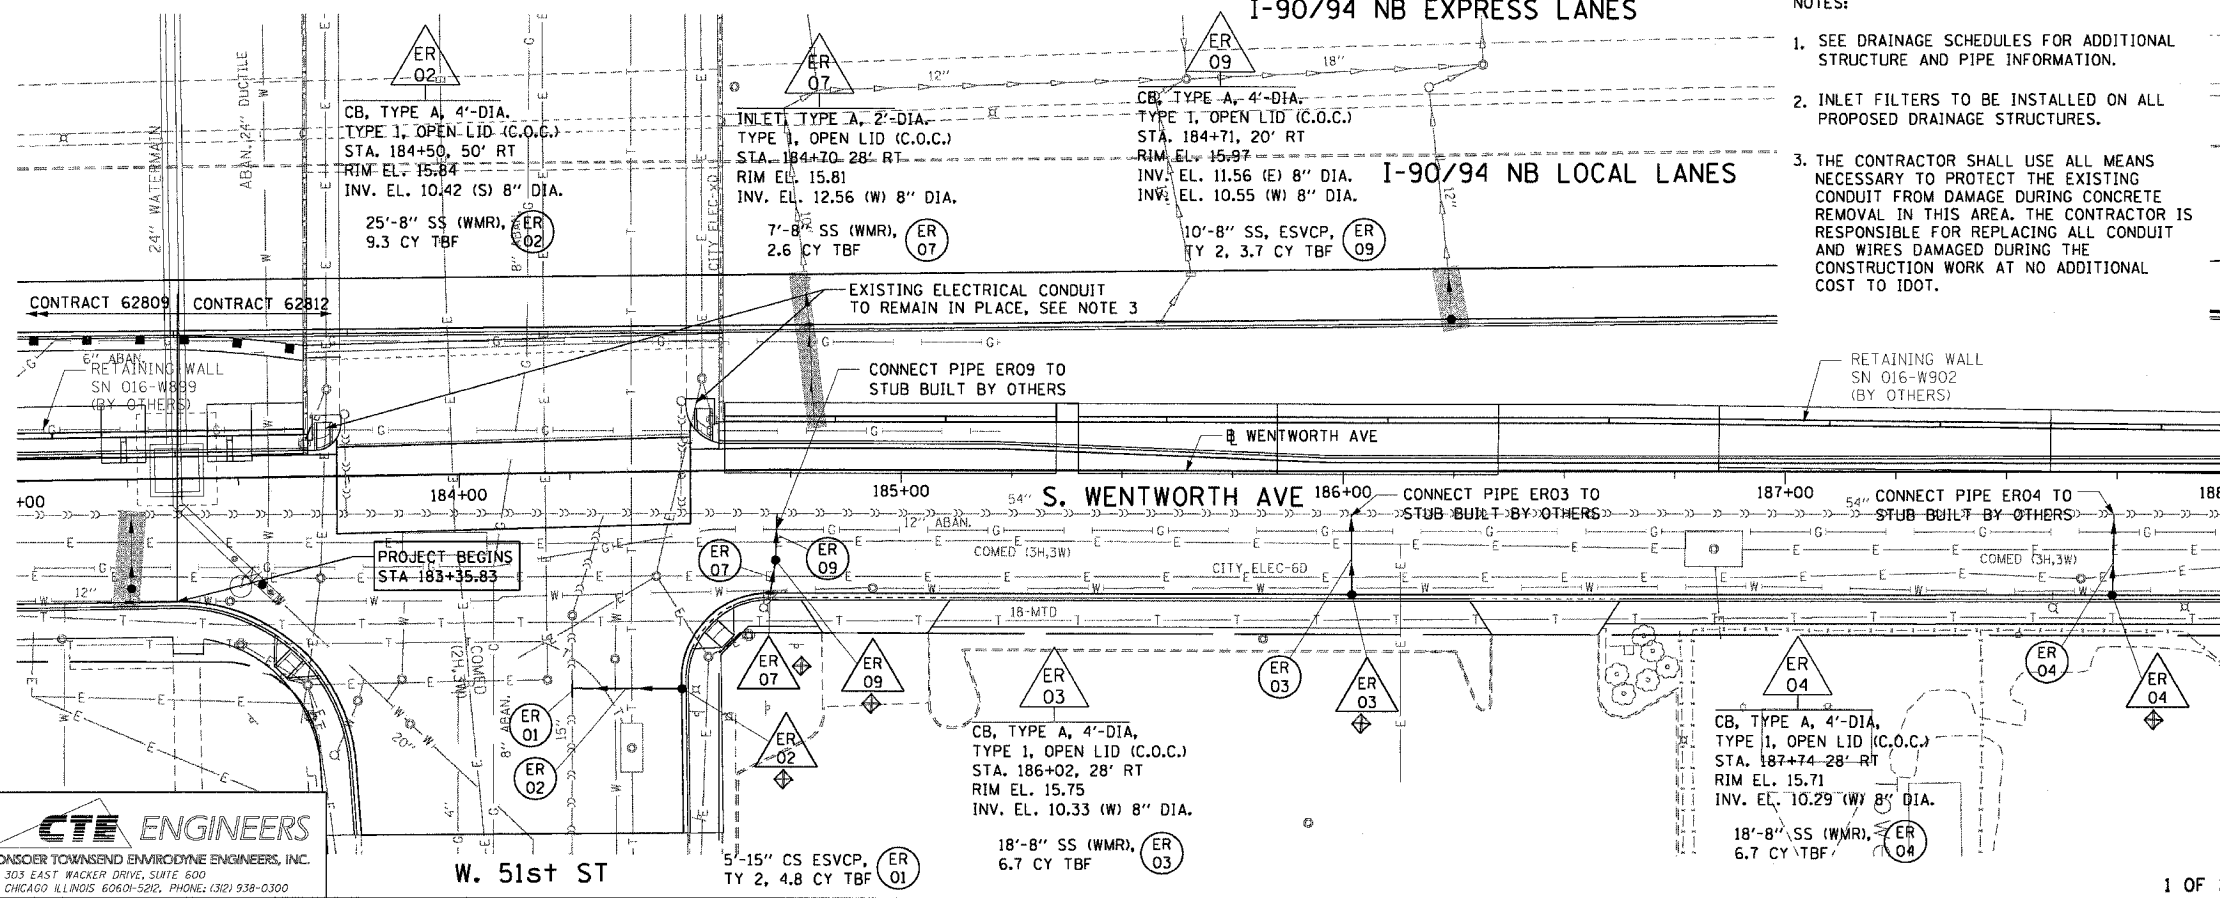

MATCH LINE STA 188+00

REVISIONS	
NAME	DATE

ILLINOIS DEPARTMENT OF TRANSPORTATION
F.A.I. 90/94 (DAN RYAN EXPRESSWAY)
51st ST (WENTWORTH AVE AND WELLS ST)
DRAINAGE AND UTILITY PLANS
WENTWORTH AVENUE

SCALE: 1"=20'
DATE: December 23, 2004
DRAWN BY: LC
CHECKED BY: JAL

CTE ENGINEERS
CONSOER TOWNSEND ENVIRONMENTAL ENGINEERS, INC.
303 EAST WACKER DRIVE, SUITE 600
CHICAGO, ILLINOIS 60601-5202, PHONE: (312) 938-0300