


| | | | | |
|---|------------|----------------|--------------|-----------|
| F.A.I. RTE. | SECTION | COUNTY | TOTAL SHEETS | SHEET NO. |
| 90/94 | 2004-074RS | COOK | 63 | 32 |
| STA. 536+75 | | TO STA. 541+50 | | |
| FED. ROAD DIST. NO. 1 ILLINOIS FED. AID PROJECT | | | | |


62813

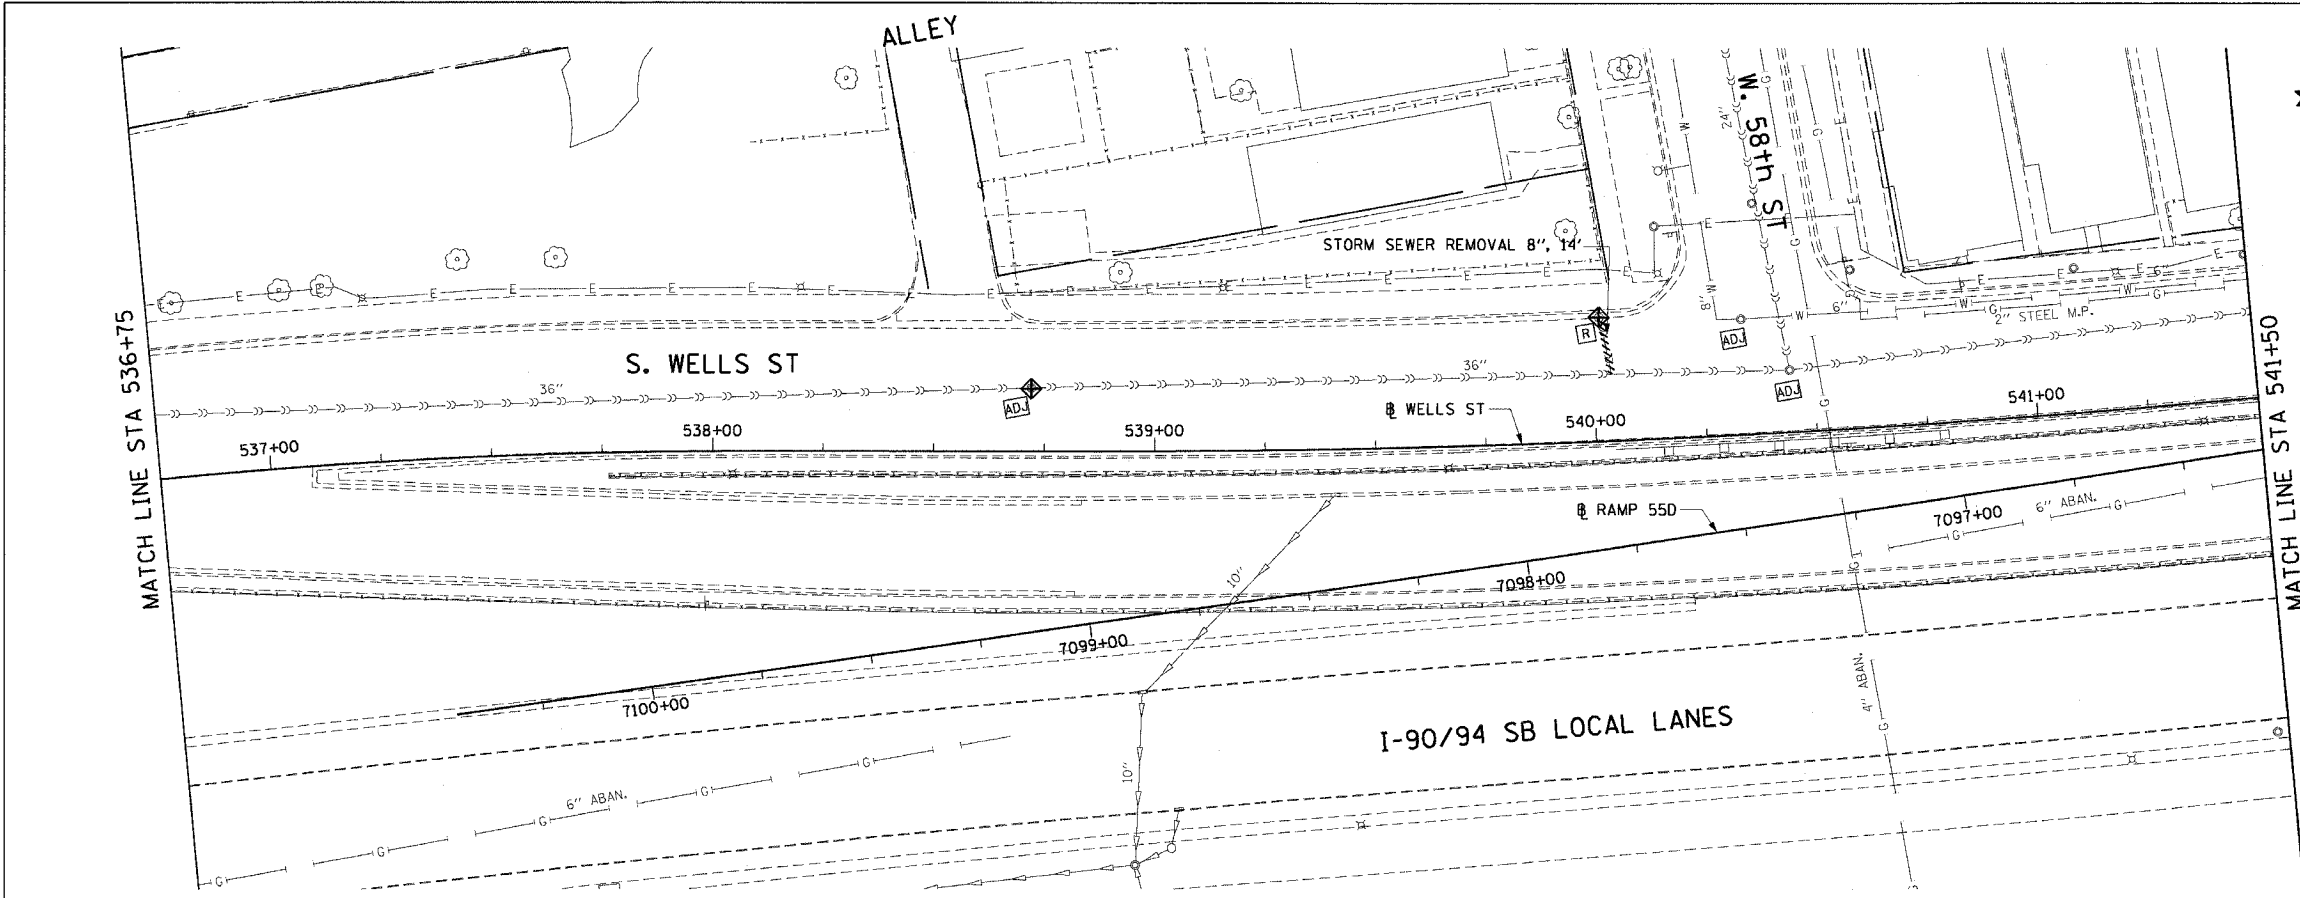

- LEGEND: EXISTING**
- INLET
 - CATCH BASIN
 - MANHOLE
 - STORM SEWER
 - COMBINED SEWER
 - PIPE UNDERDRAIN
 - [R] STRUCTURE TO BE REMOVED
 - [AD] STRUCTURE TO BE ADJUSTED
 - STORM SEWER REMOVAL
 - COMBINED SEWER REMOVAL

NOTE:
ALL EXISTING OPEN LID DRAINAGE STRUCTURES TO REMAIN THRU STAGE 2 OF CONTRACT 62586 SHALL HAVE INLET FILTERS INSTALLED.

EXISTING CONDITIONS AND REMOVAL PROPOSED IMPROVEMENTS

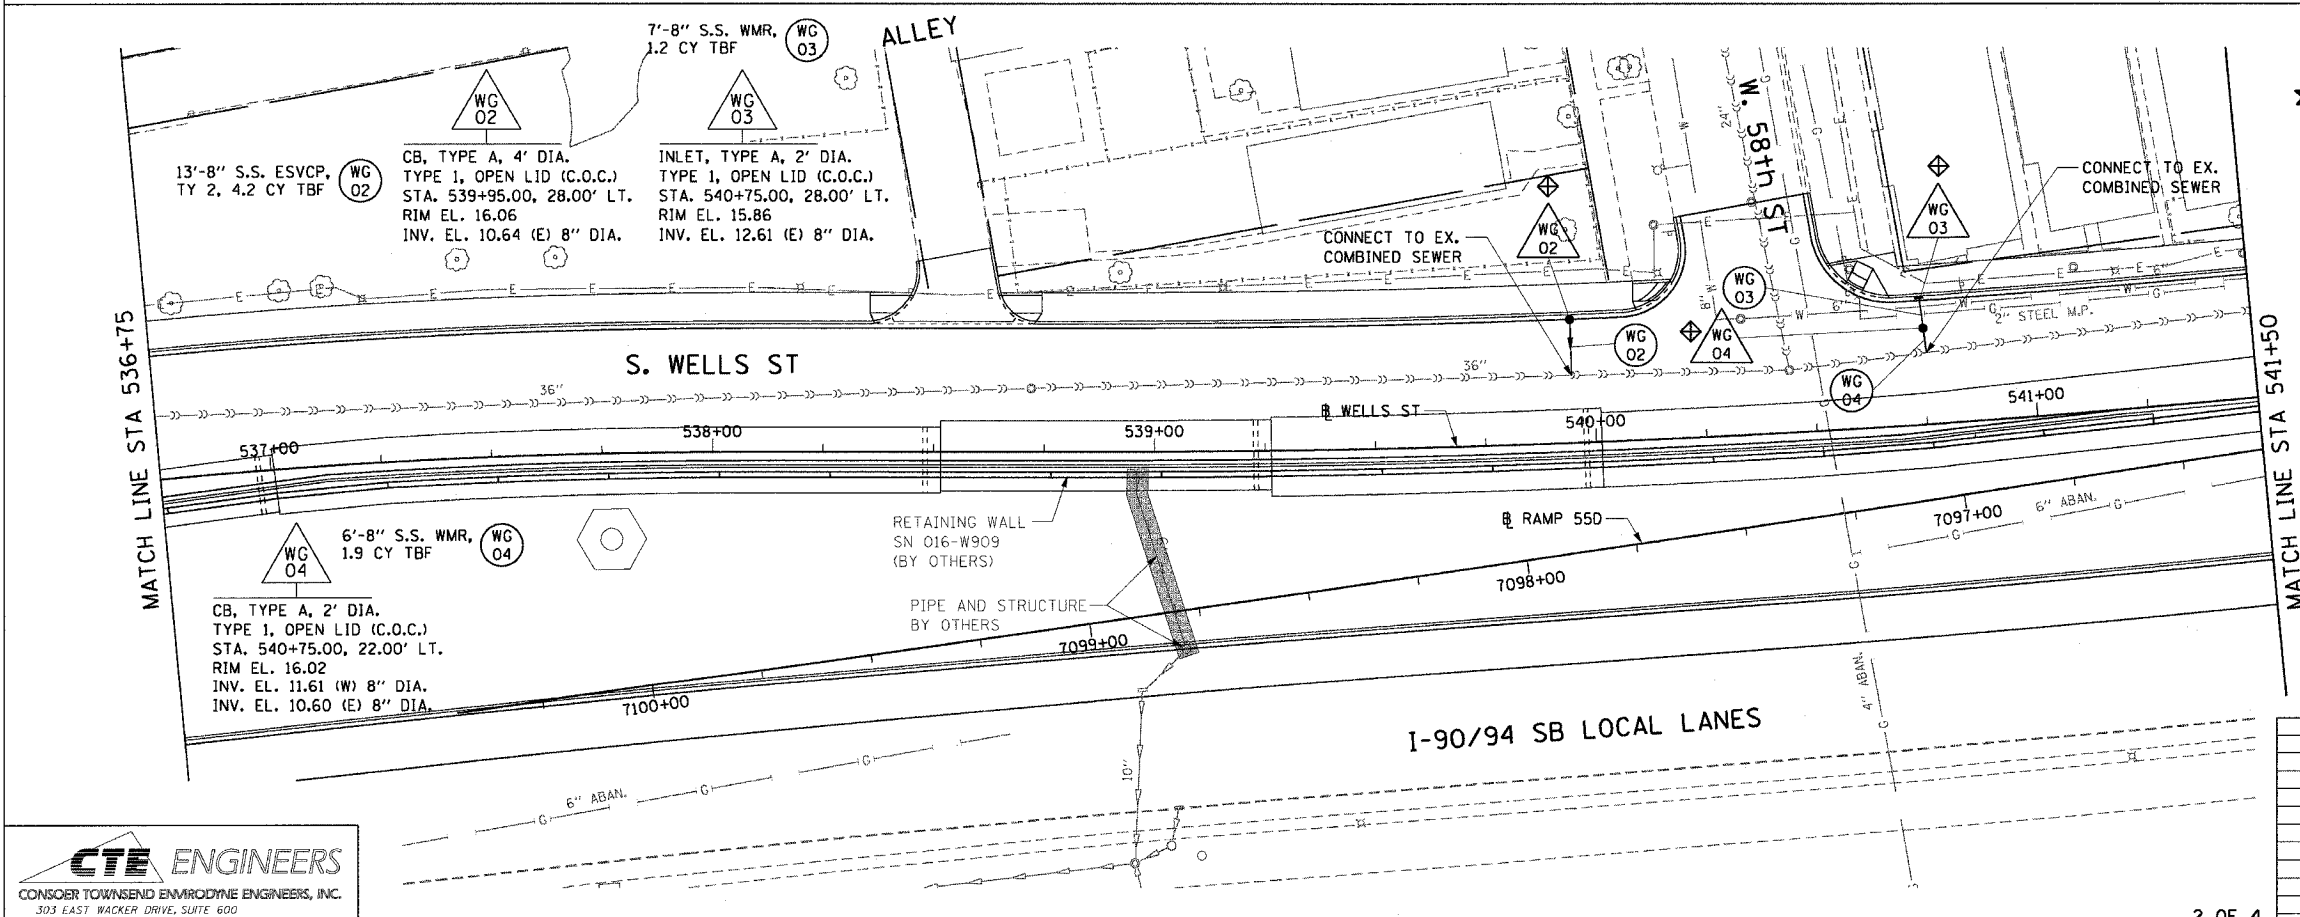

- LEGEND: PROPOSED**
- INLET
 - CATCH BASIN
 - MANHOLE
 - STORM SEWER
 - COMBINED SEWER
 - PIPE UNDERDRAIN
 - PROPOSED SWALE
 - (EA 01) PROPOSED STORM SEWER PIPE
 - △(EA 01) PROPOSED STRUCTURE
 - WORK TO BE DONE BY OTHERS
 - ◊ INLET FILTER

- NOTES:**
- SEE DRAINAGE SCHEDULES FOR STRUCTURE AND PIPE INFORMATION.
 - INLET FILTERS TO BE INSTALLED ON ALL PROP. DRAINAGE STR.

| REVISIONS | |
|-----------|------|
| NAME | DATE |
| | |
| | |
| | |
| | |
| | |

ILLINOIS DEPARTMENT OF TRANSPORTATION
F.A.I. 90/94 (DAN RYAN EXPRESSWAY)
59th ST TO 57th ST (WELLS STREET)

**DRAINAGE AND UTILITY PLANS
WELLS STREET**

SCALE: 1"=20'
DATE: December 17, 2004
DRAWN BY: PHP
CHECKED BY: JB

12/14/2004 4:56:14 PM