 



CONTRACT 62829	F.A.P. RTE.	SECTION	COUNTY	TOTAL SHEETS	SHEET NO.
	305	2004-088B	COOK	145	49
	STA.	TO STA.			



P:\000019\04\advance\contract\lighting\19 5 lighting plan.dwg

- NOTES:**
- SEE SHEET LTG-6 FOR UNDERPASS LIGHTING PLAN.
 - INTERCEPT CIRCUITS IN EXISTING LIGHT POLE FOUNDATION AND EXTEND TO NEW UNDERPASS LIGHTING FIXTURES.

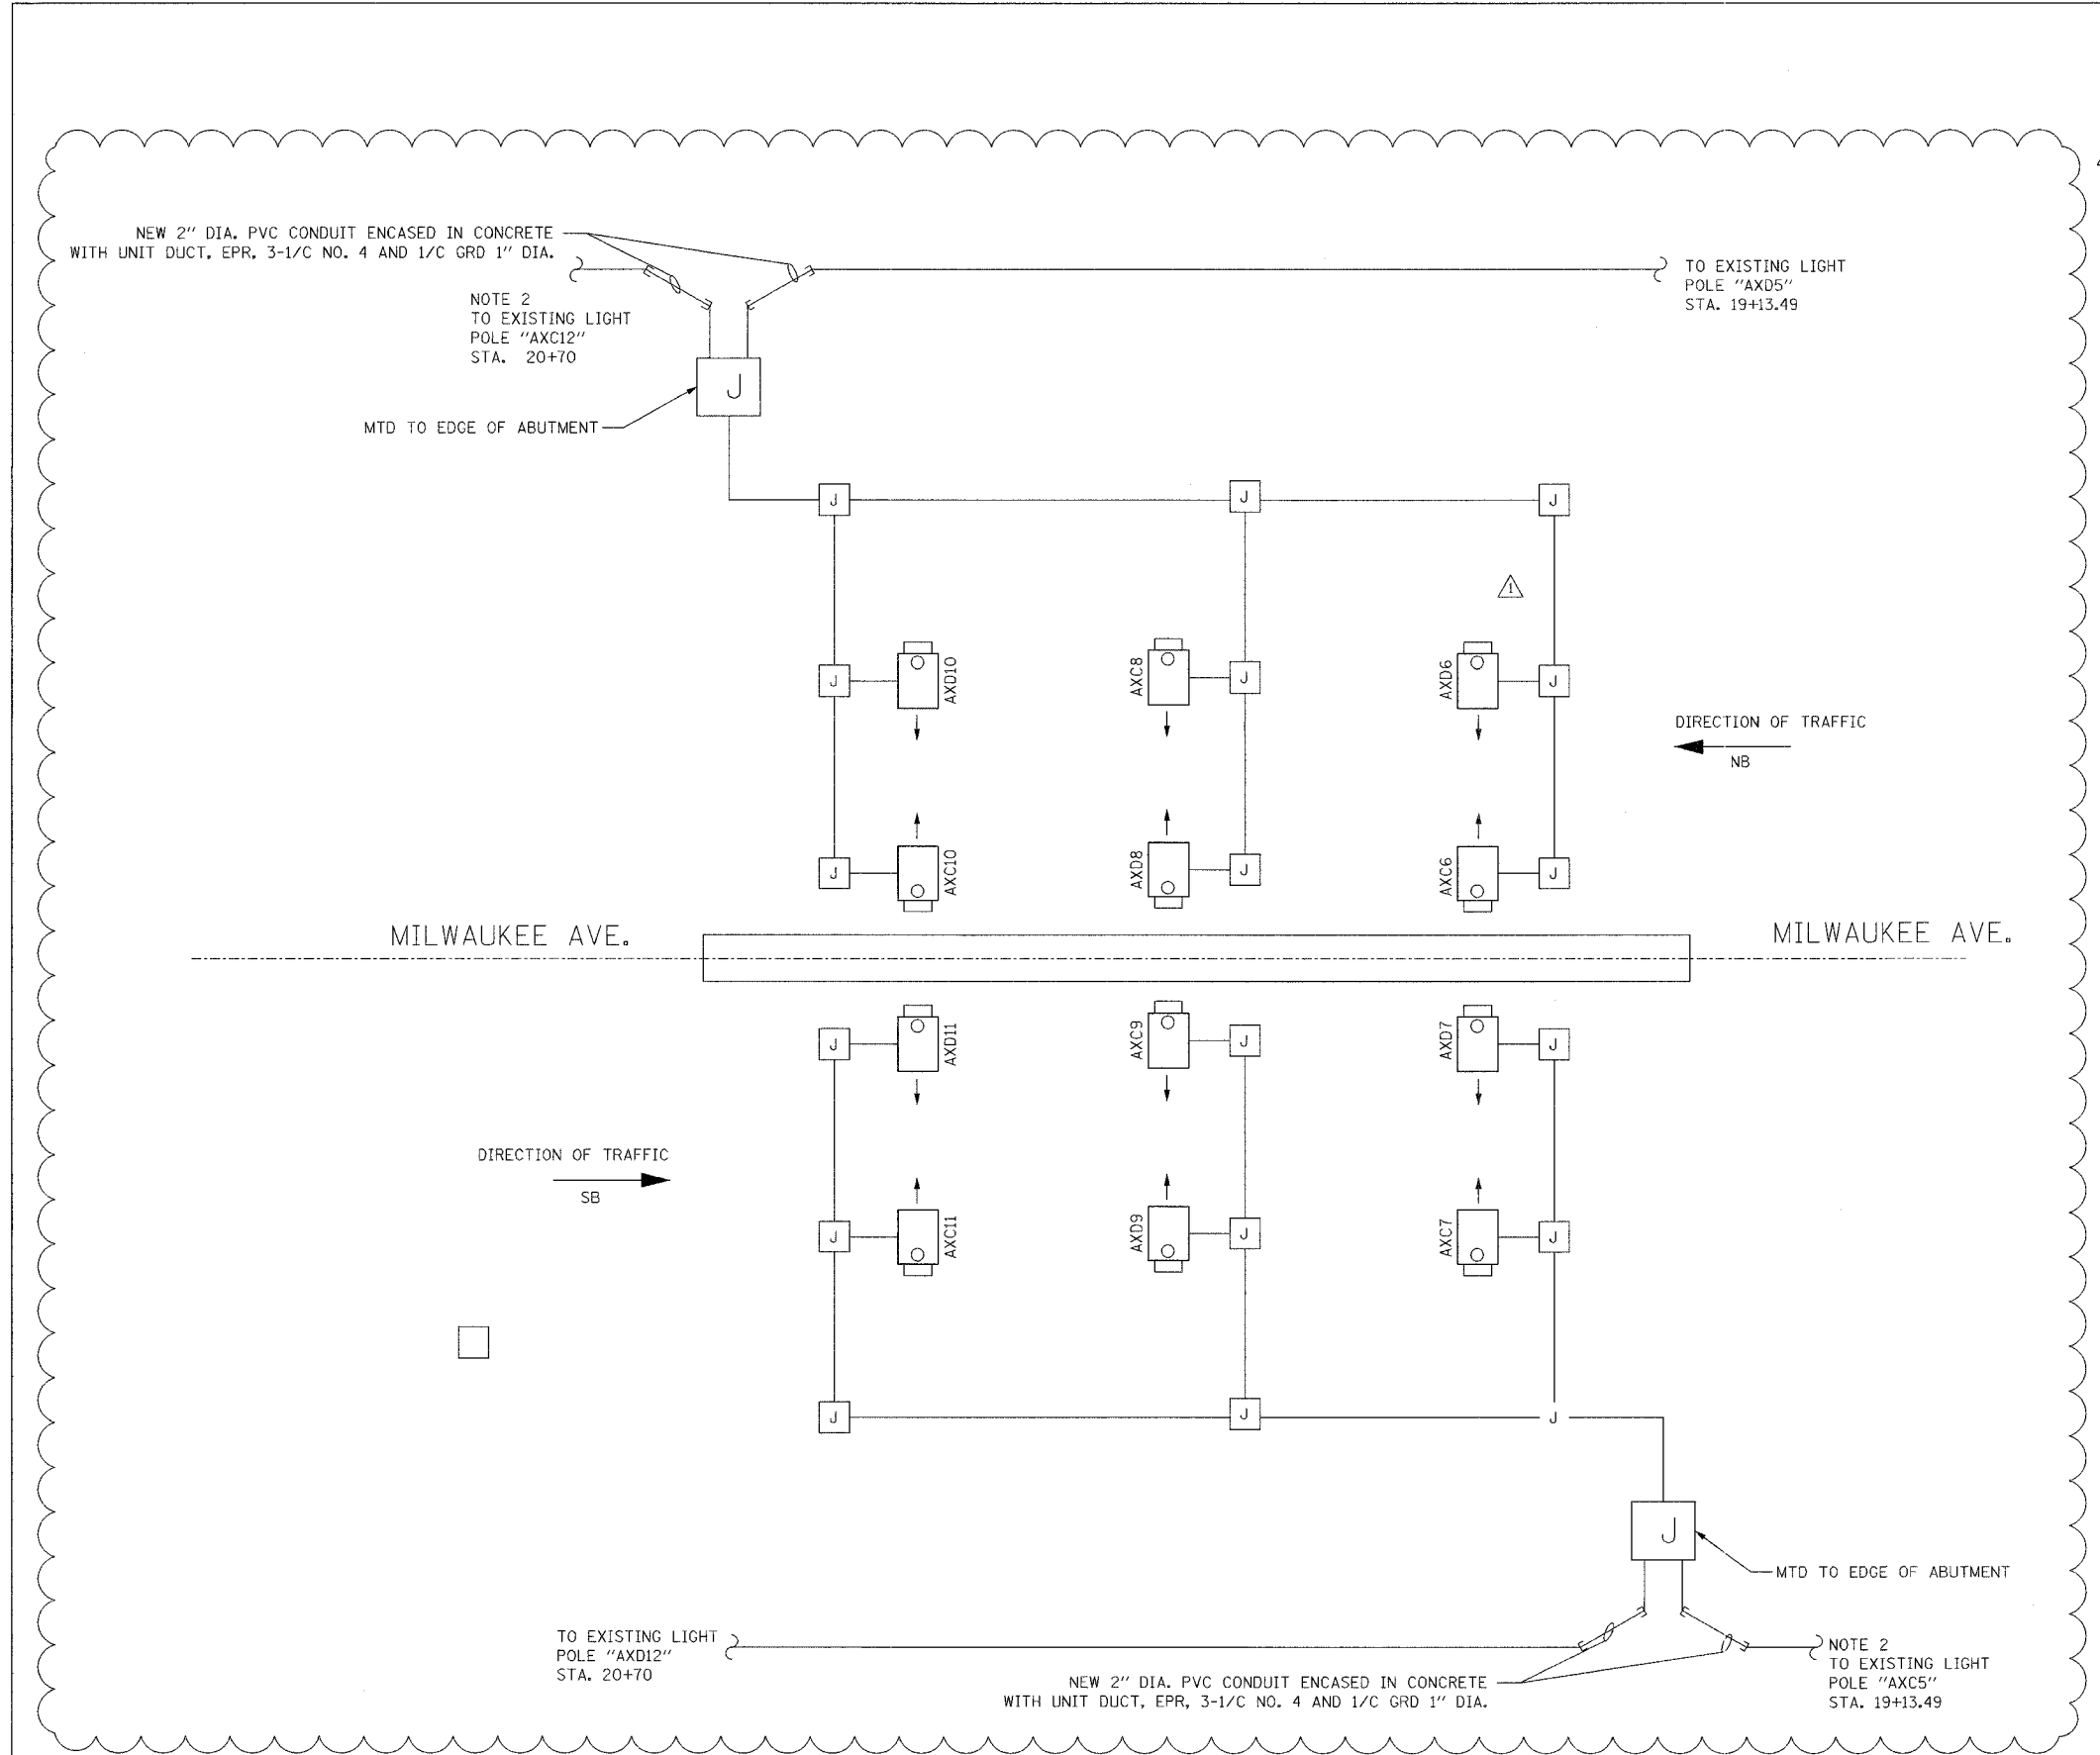

Edwards and Kelcey

REVISIONS	
NAME	DATE
ADDENDUM 1	2/22/05

ILLINOIS DEPARTMENT OF TRANSPORTATION

WILLOW RD. & MILWAUKEE AVE UNDERPASS WIRING DETAIL

WILLOW ROAD OVER US 45/IL 21 (MILWAUKEE AVE) AND OVER DES PLAINES RIVER

SCALE 1"=30'

DATE JANUARY 2005

DRAWN BY CADD SC

CHECKED BY CDS

LTG-5

02/22/2005 03:54:58 PM