




SCALES:
 PLAN: 1"=20'
 PROFILE: 1"=20' H
 1"=5' V

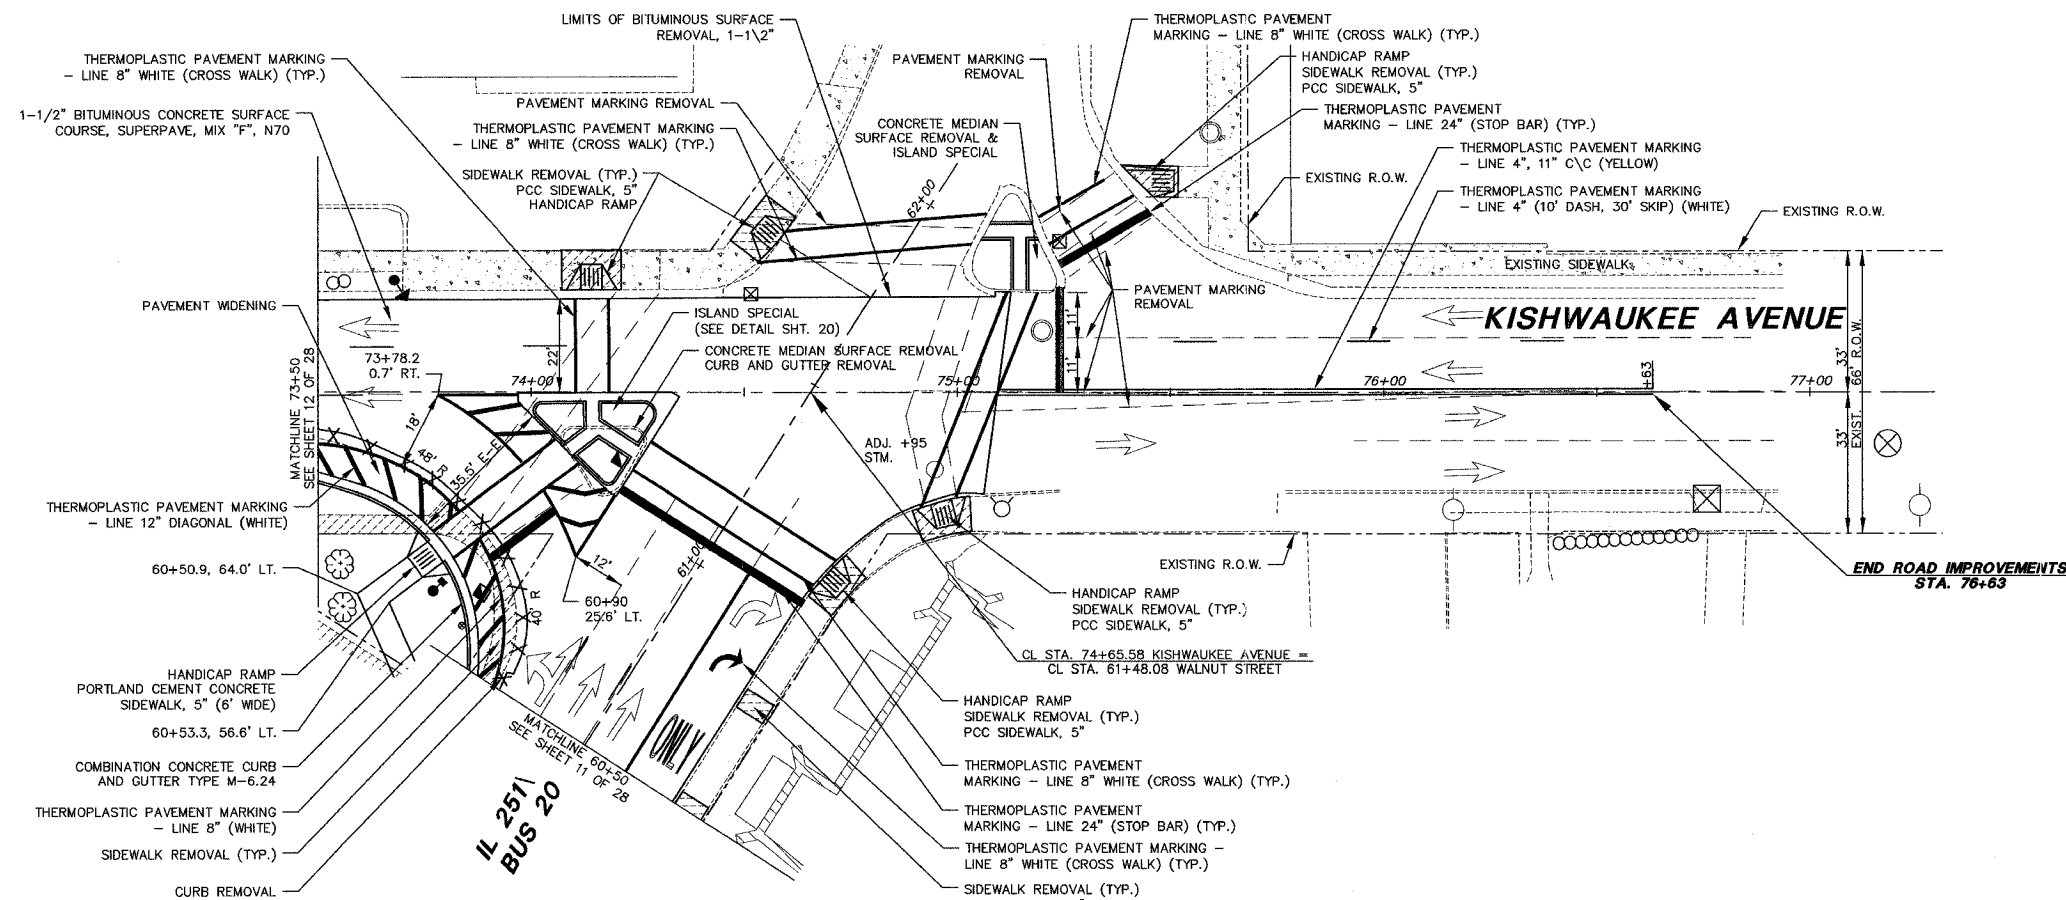

END ROAD IMPROVEMENTS
 STA. 76+63

										BENCHMARKS			
										DESCRIPTION	ELEVATION		
770											BM #6: TOP OF SW BOLT ON FIRE HYDRANT AT THE NW CORNER OF WALNUT AND 3rd STREET.	760.64	770
765											BM #7: TOP OF SW BOLT ON FIRE HYDRANT AT THE NE CORNER OF WALNUT AND 2nd STREET.	751.59	765
760													760
755													755
750													750
745													745
740													740
735													735
730													730
	EXIST. C												
	PROP. C												
		755.8	756.5	756.8	756.7	756.6	756.1	756.3					
			74+00		75+00		76+00						

© Copyright 2004 by McClure Engineering Associates, Inc.

REVISIONS		
NO.	ITEM	DATE

PLOTTING SCALE: 1"=1'
 DRAWN BY: BSL
 CHECKED BY: JWH
 DATE: DECEMBER 1, 2004

McCLURE ENGINEERING ASSOCIATES, INC.
 7282 Argus Drive Rockford, Illinois 61107
 (815) 398-2332 FAX (815) 398-2496
 Design Firm License: Illinois #184-000816

PLAN AND PROFILE STA. 73+50 - 75+09.44
 CITY OF ROCKFORD
 WALNUT STREET (HEB) ROCKFORD, ILLINOIS
 FILE NAME: H:\SecondSt.-2004(HES)\Kishwaukee-pa2.dwg SEC. 140CS-TS-3 JOB NUMBER: 04-28-04-045

SHEET NO.
13 OF 28