
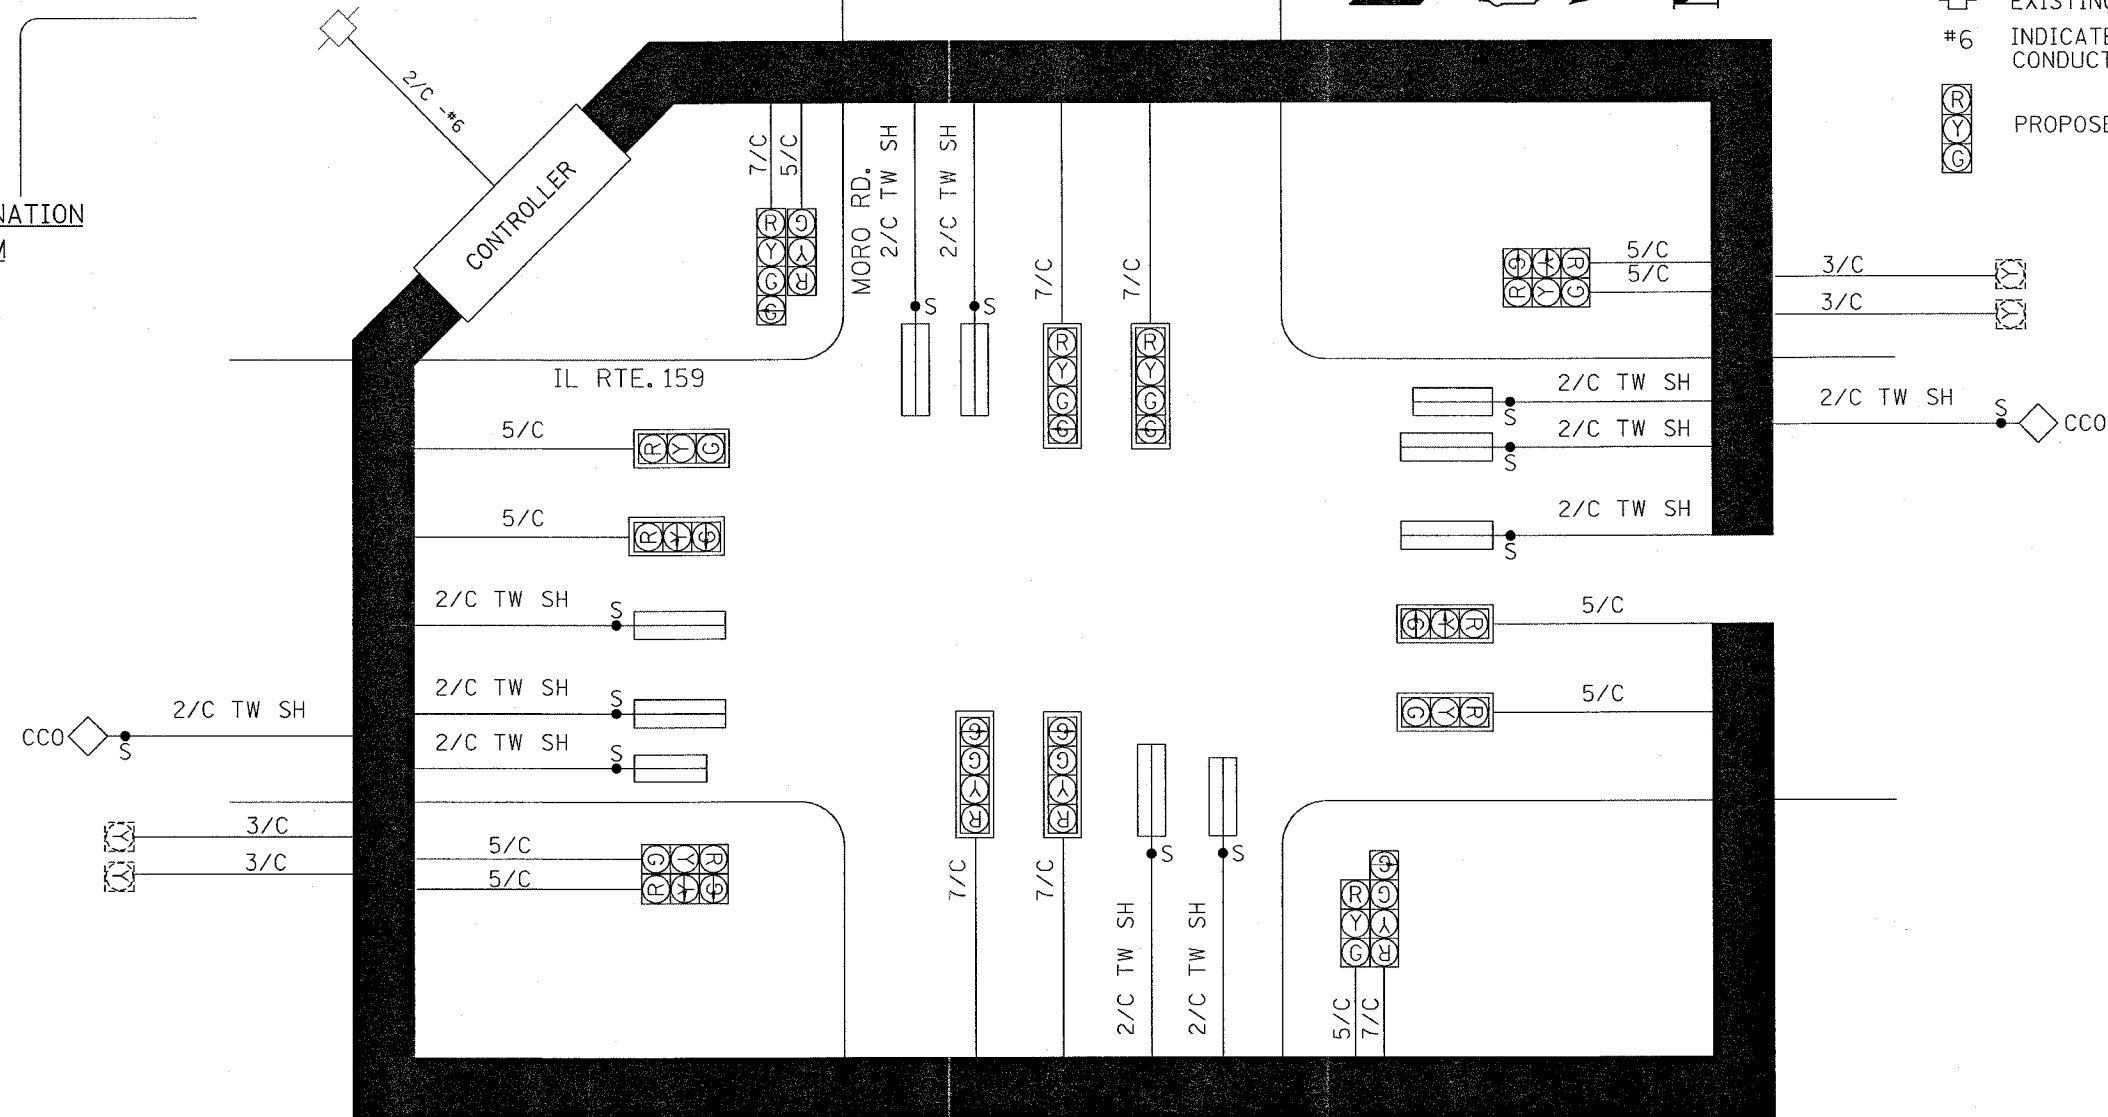


FAP ROUTE	SECTION	COUNTY	TOTAL SHEETS	SHEET NO
604	102TS	MADISON	37	23
STA.		TO STA.		
CONTRACT NO.: 76798				

CABLE DIAGRAM LEGEND

- ELECTRIC CABLE IN CONDUIT
- CABLE SPLICE (SEE GENERAL NOTES)
- 2/C INDICATES NUMBER OF CONDUCTORS IN CABLE
- CCO CALL CARRY OVER (SEE GENERAL NOTES)
- EXISTING SERVICE INSTALLATION
- #6 INDICATES AMERICAN WIRE GAUGE (AWG) SIZE 6 CONDUCTORS (SEE GENERAL NOTES)
- PROPOSED SIGNAL HEAD WITH BACKPLATE

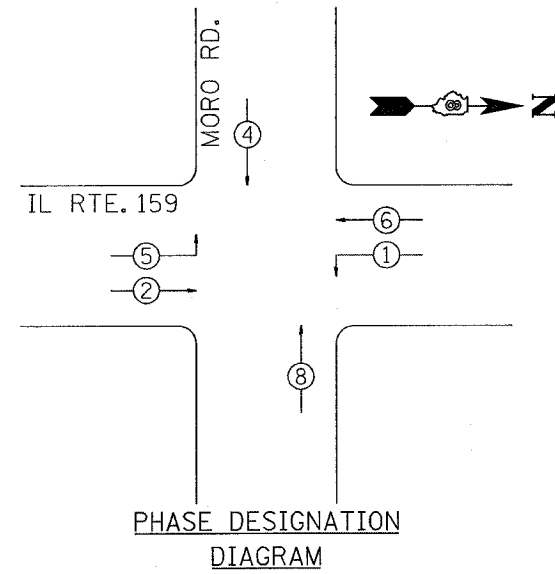

FULL-ACTUATED CONTROLLER SEQUENCE
8 PHASES, IN TYPE IV CABINET

PROPOSED SEQUENCE OF OPERATION								
PHASE	1	2	3	4	5	6	7	8
MOVEMENT	←	→	NOT	↓	→	←	NOT	↑
CONCURRENT MOVEMENT PERMITTED	5 OR 6	5 OR 6	USED	NONE	1 OR 2	1 OR 2	USED	NONE

REVISIONS	
NAME	DATE

ILLINOIS DEPARTMENT OF TRANSPORTATION
**CABLE DIAGRAM
 PHASE DESIGNATION DIAGRAM
 SEQUENCE OF OPERATION
 IL 159 AT MORO RD.**
 FAP ROUTE 604
 SECTION 102TS
 MADISON COUNTY
 DRAWN BY:

PLAN	DATE
SUBMITTED	
NOTE BOOK	
NO.	
ADD FILE NAME	

1/7/2005
 Friday, January 07, 2005 @ 11:33:42 AM
 C:\p\projects\604\102TS\cable\cable.dgn LV1-63