





MATCH LINE  
 STA. 1061+00 F.A.I. 55  
 SEE SHEET NO. 205E

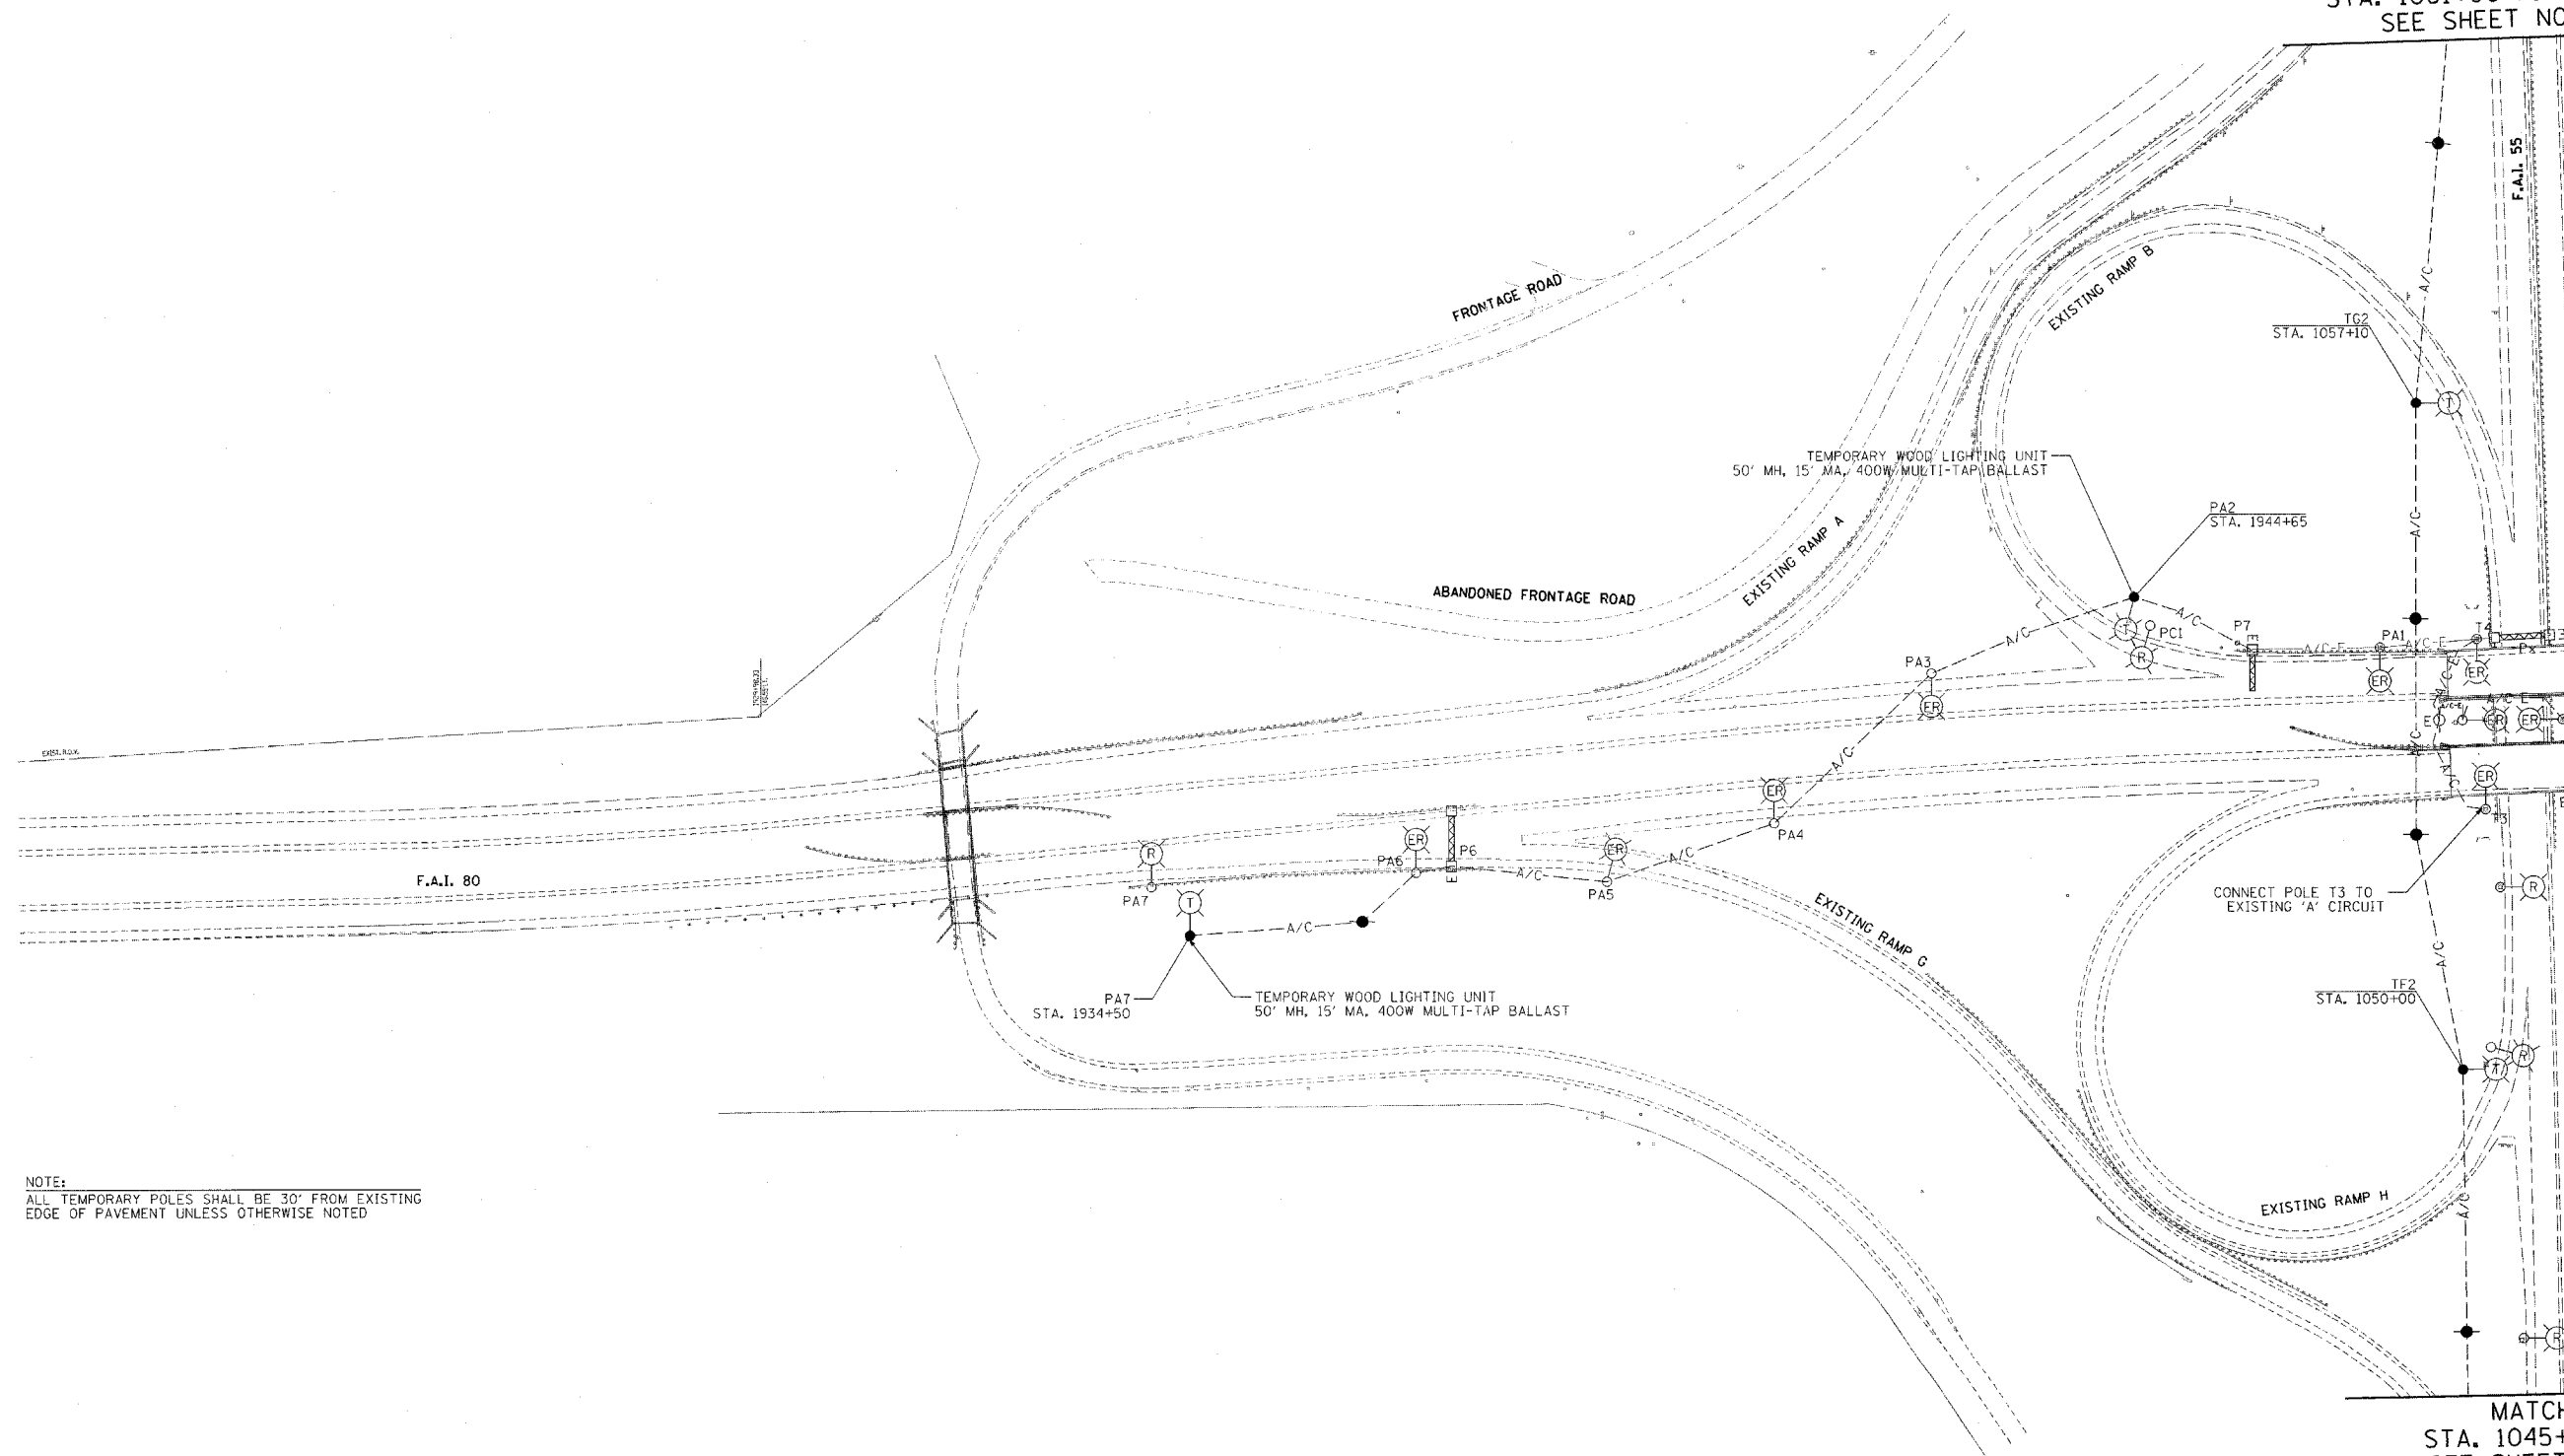

NOTE:  
 ALL TEMPORARY POLES SHALL BE 30' FROM EXISTING  
 EDGE OF PAVEMENT UNLESS OTHERWISE NOTED

MATCH LINE  
 STA. 1045+50 F.A.I. 55  
 SEE SHEET NO. 205B

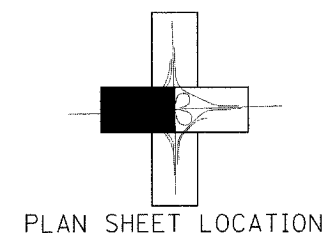

REVISIONS	
NAME	DATE

STATE OF ILLINOIS  
 DEPARTMENT OF TRANSPORTATION  
 F.A.I. 80 & F.A.I. 55 INTERCHANGE  
 TEMPORARY LIGHTING PLAN  
 PRE-STAGE

SCALE: 1" = 100'  
 DATE: JANUARY, 2005

DRAWN BY: JMV  
 CHECKED BY: AC