



| | | | | |
|---------------------------|------------------|------------------|--------------|-----------|
| F.A.I. ROUTE | SECTION | COUNTY | TOTAL SHEETS | SHEET NO. |
| 80-55 | 99-1(K,B,Y&AC-B) | WILL | 497 | 205E |
| STA. | TO STA. | | | |
| FED. ROAD DIST. NO. 1 | ILLINOIS | FED. AID PROJECT | | |
| CONTRACT NO. 80906 | | | | |

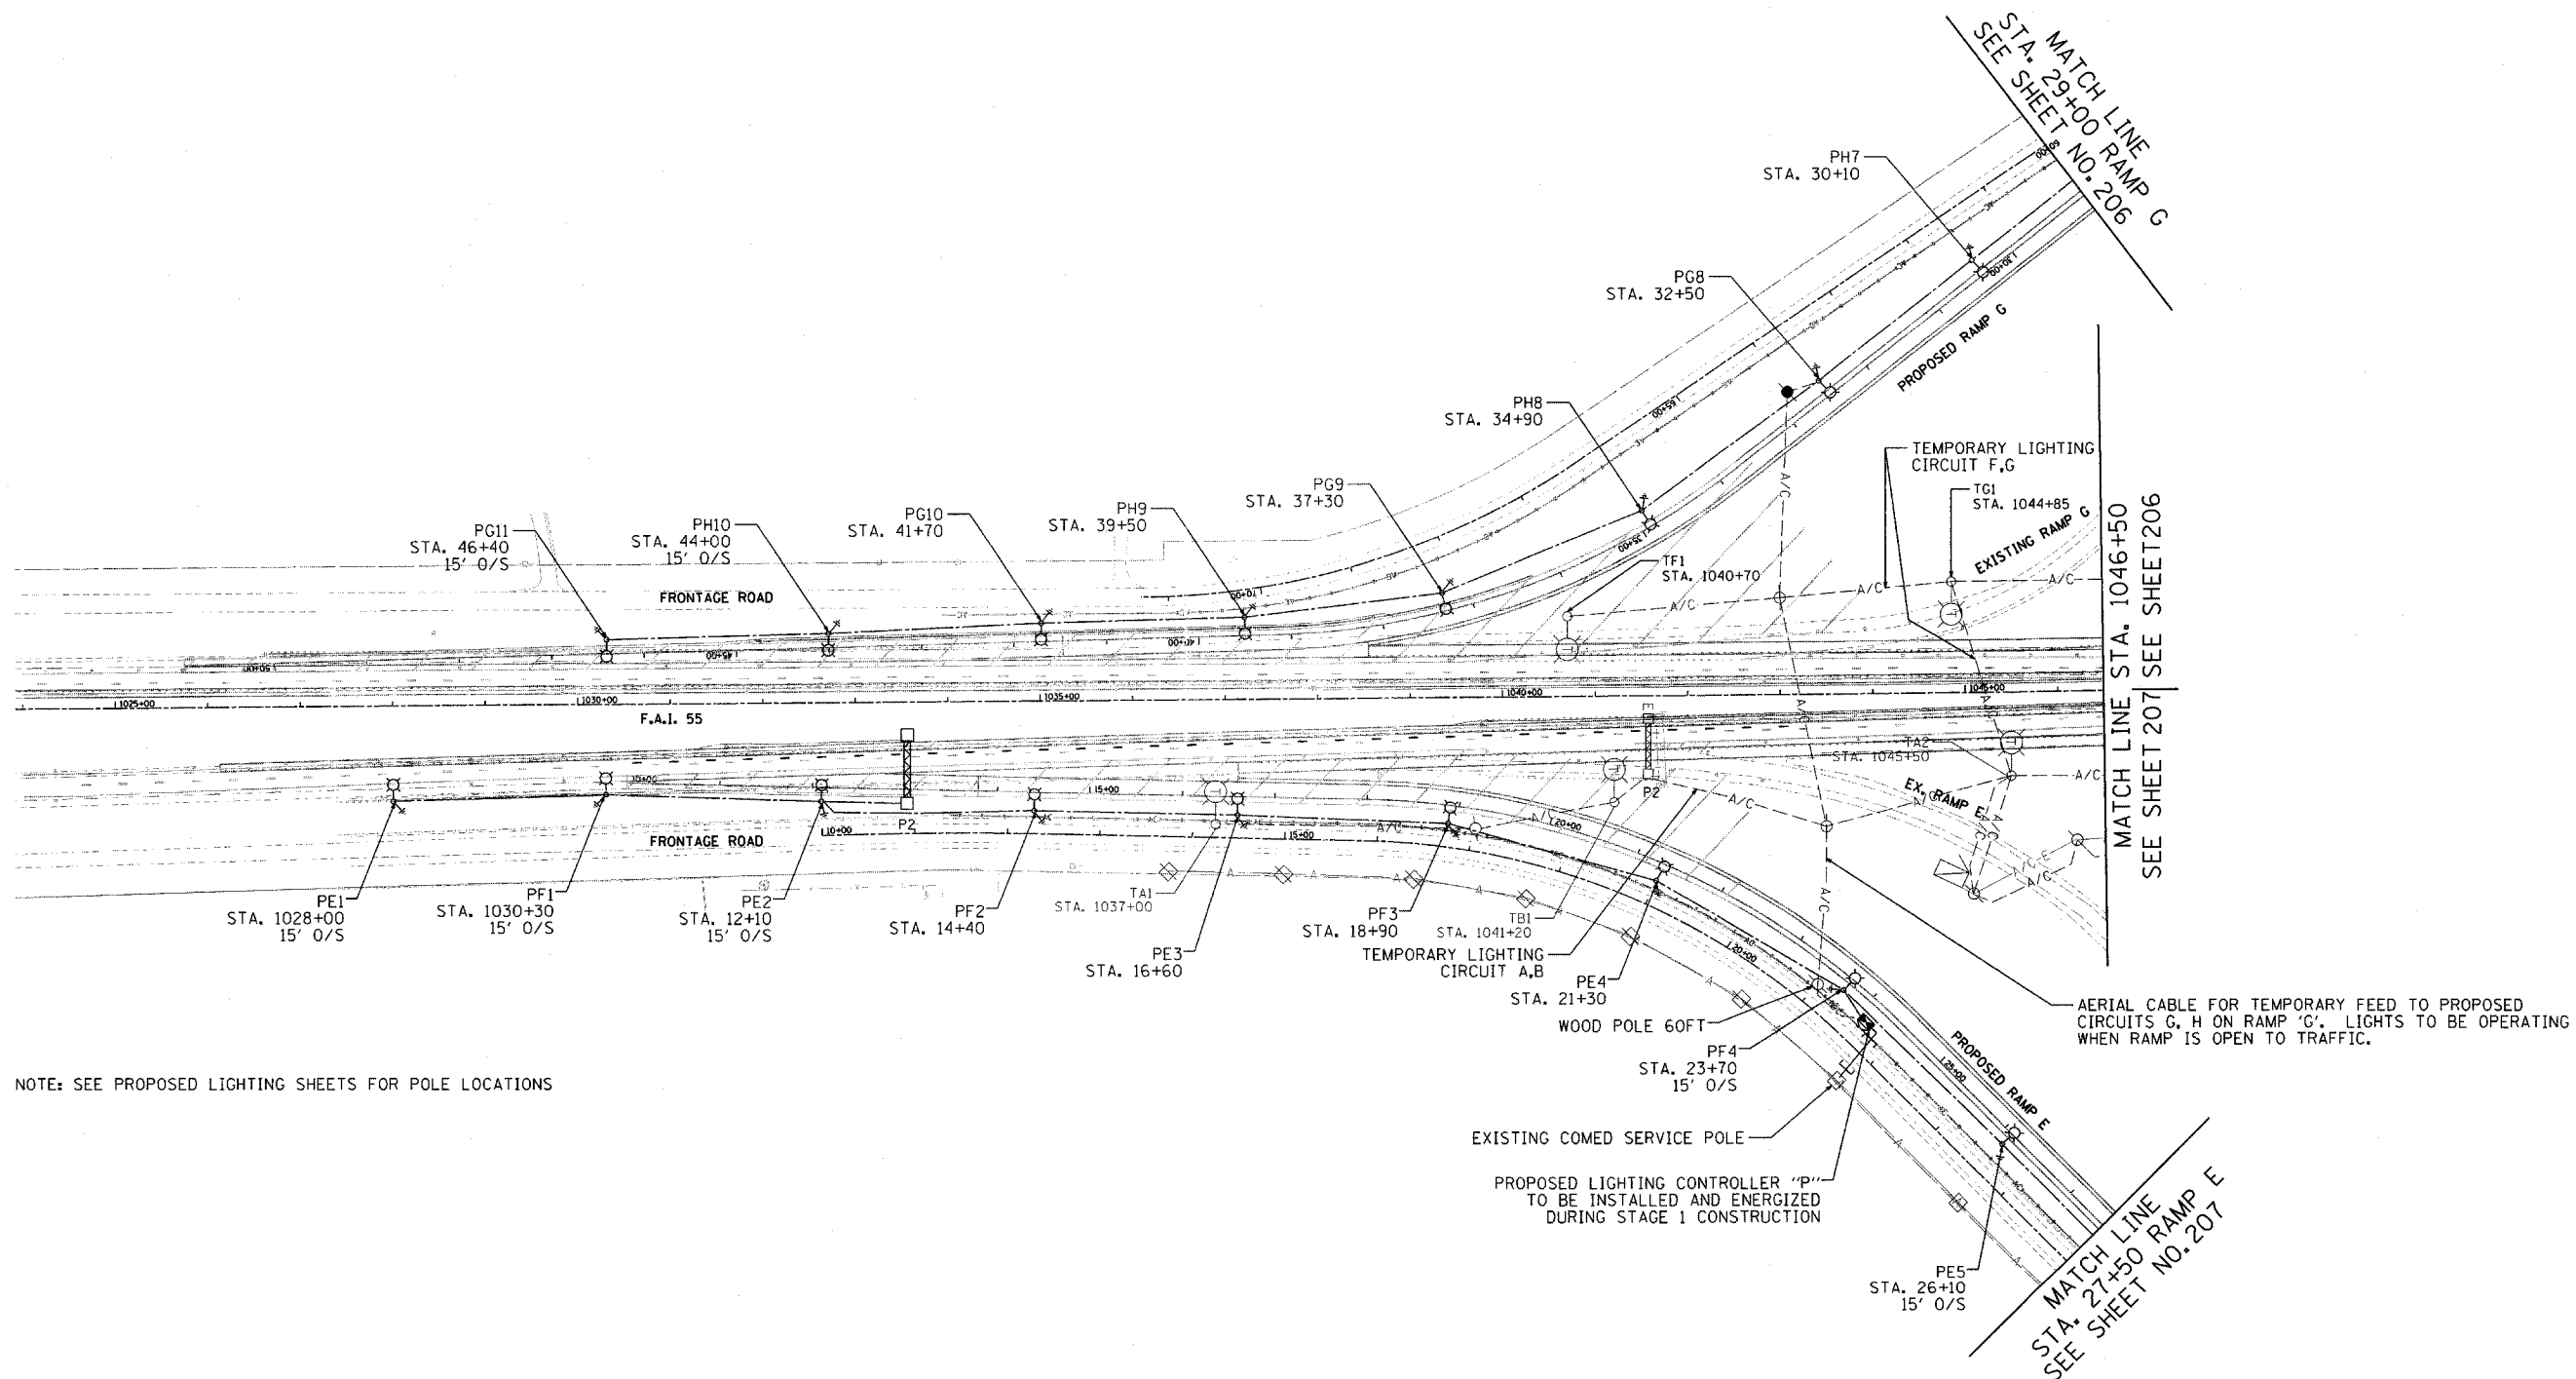

NOTE: SEE PROPOSED LIGHTING SHEETS FOR POLE LOCATIONS

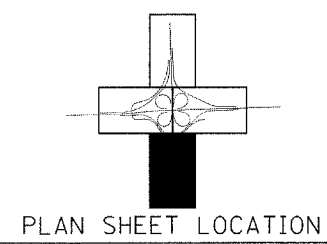

| REVISIONS | |
|-----------|------|
| NAME | DATE |
| | |
| | |
STATE OF ILLINOIS
DEPARTMENT OF TRANSPORTATION
F.A.I. 80 & F.A.I. 55 INTERCHANGE
**TEMPORARY LIGHTING PLAN
STAGE 1**

SCALE: 1" = 100'
DATE: JANUARY, 2005

DRAWN BY: JMV
CHECKED BY: AC