


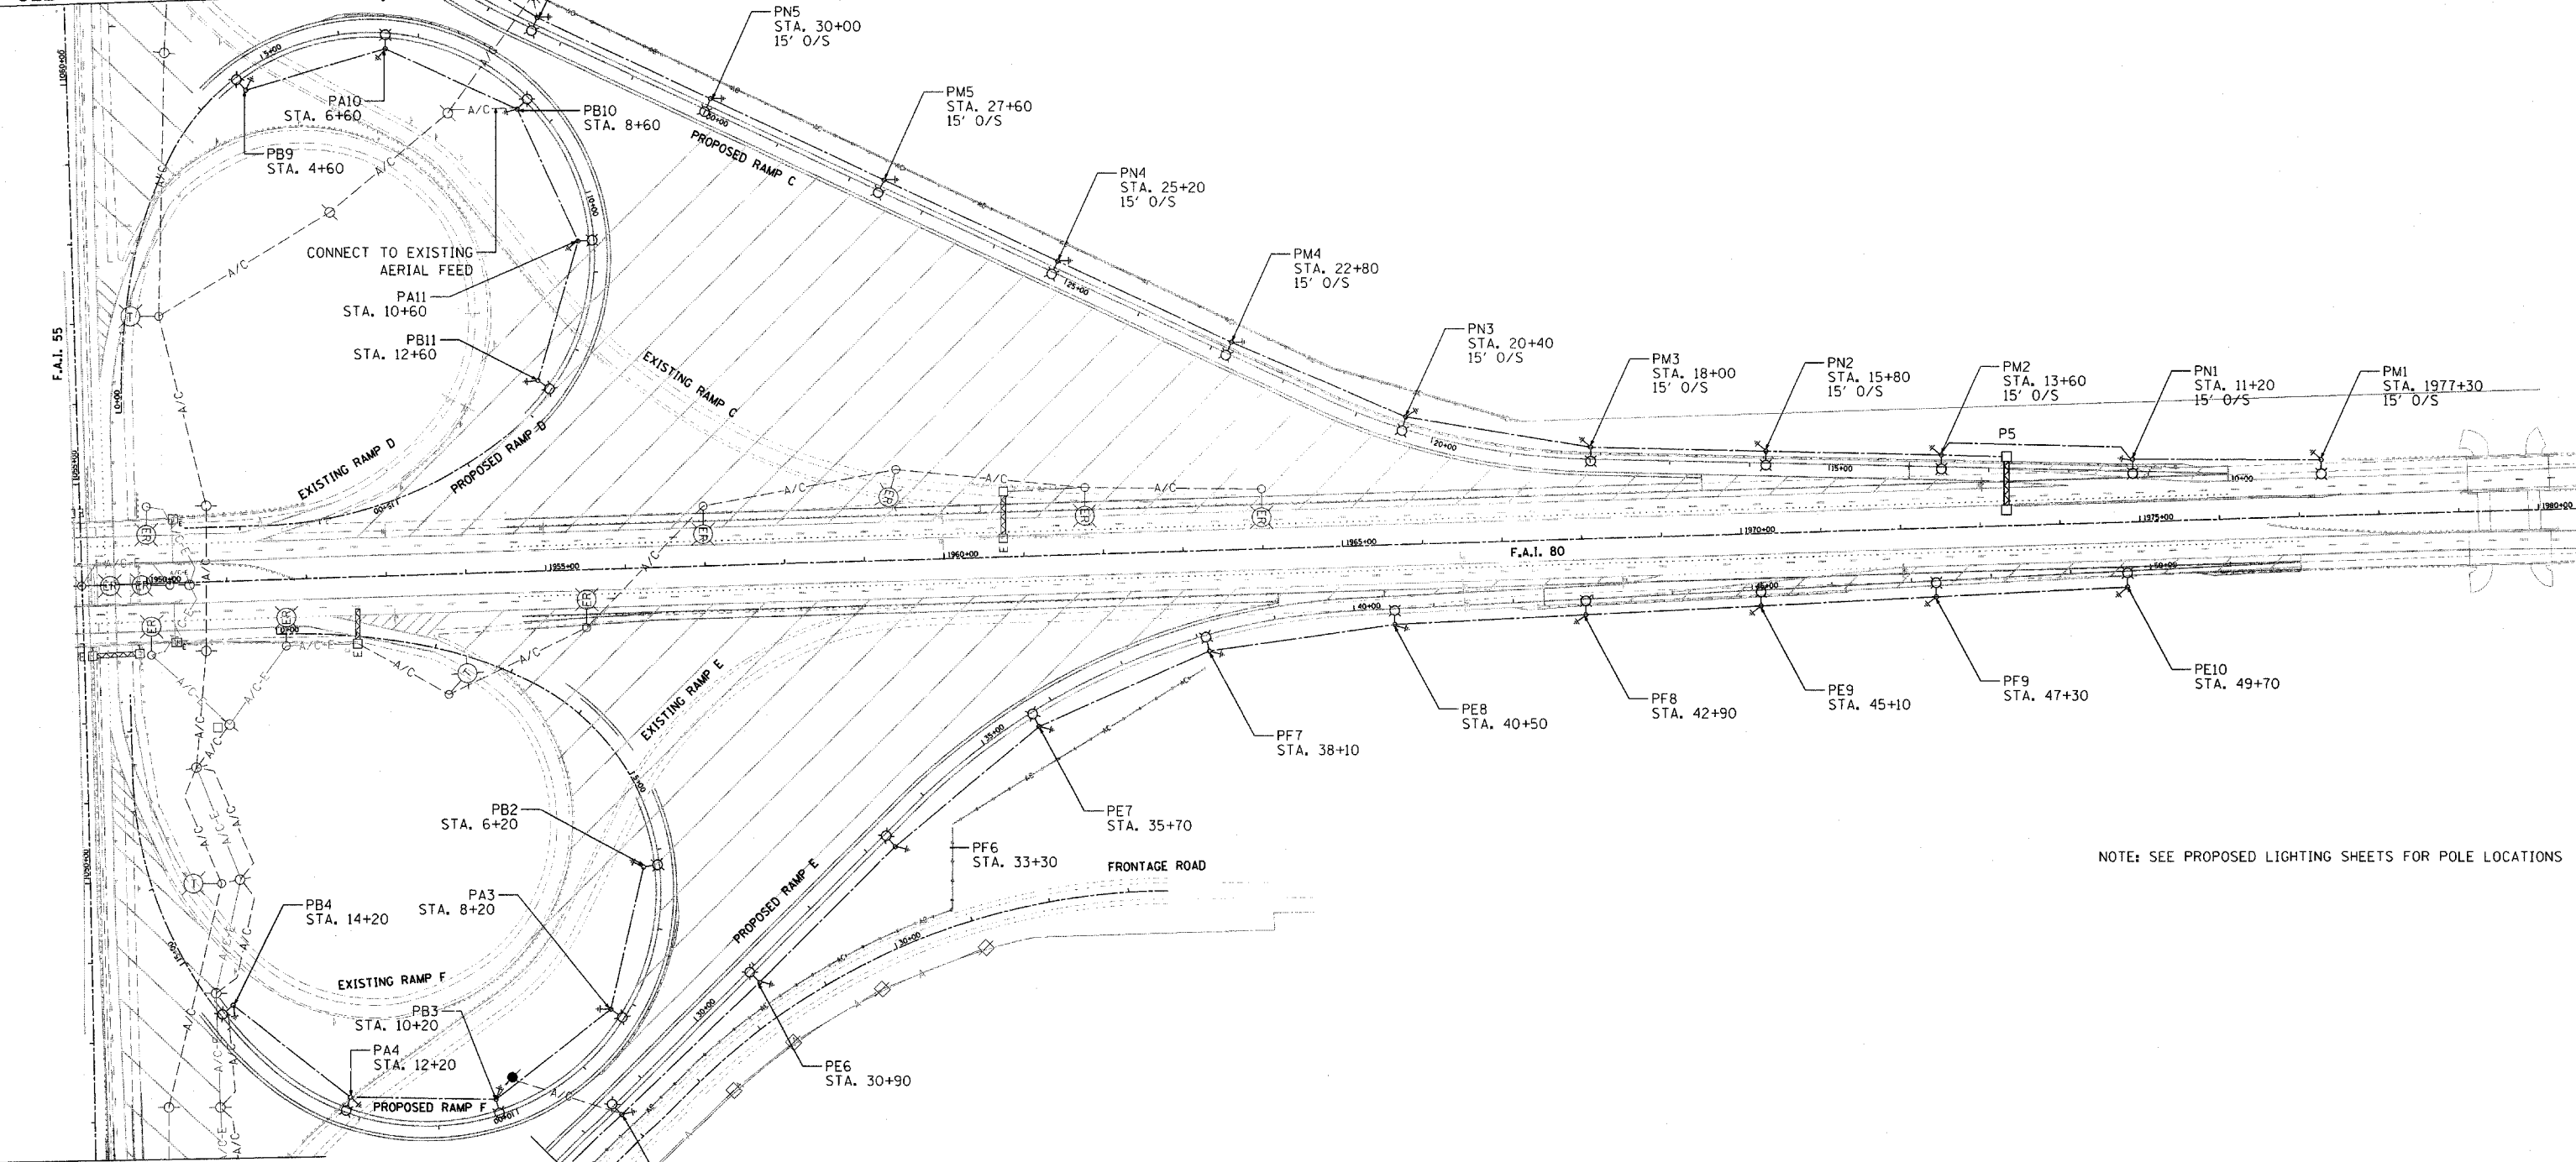

MATCH LINE
STA. 1061+00 F.A.I. 55
SEE SHEET NO. 212


MATCH LINE
STA. 34+00 RAMP C
SEE SHEET NO. 212



MATCH LINE
STA. 1046+50 F.A.I. 55
SEE SHEET NO. 209

MATCH LINE
STA. 27+50 RAMP E
SEE SHEET NO. 209

NOTE: SEE PROPOSED LIGHTING SHEETS FOR POLE LOCATIONS

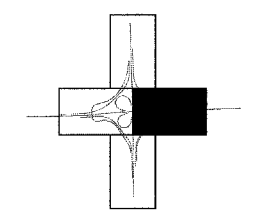

PLAN SHEET LOCATION

| REVISIONS | |
|-----------|------|
| NAME | DATE |
| | |
| | |
STATE OF ILLINOIS
DEPARTMENT OF TRANSPORTATION
F.A.I. 80 & F.A.I. 55 INTERCHANGE
TEMPORARY LIGHTING PLAN
STAGE 2

SCALE: 1" = 100'
DATE: JANUARY, 2005

DRAWN BY: JMV
CHECKED BY: AC