


F.A.I. ROUTE	SECTION	COUNTY	TOTAL SHEETS	SHEET NO.
80-55	99-1K, BY&AC-B1	WILL	497	215
STA.		TO STA.		
FED. ROAD DIST. NO. 1		ILLINOIS FED. AID PROJECT		
CONTRACT NO. 80906				



MATCH LINE
STA. 1061+00 F.A.I. 55
SEE SHEET NO. 216


MATCH LINE
STA. 34+00 RAMP C
SEE SHEET NO. 216

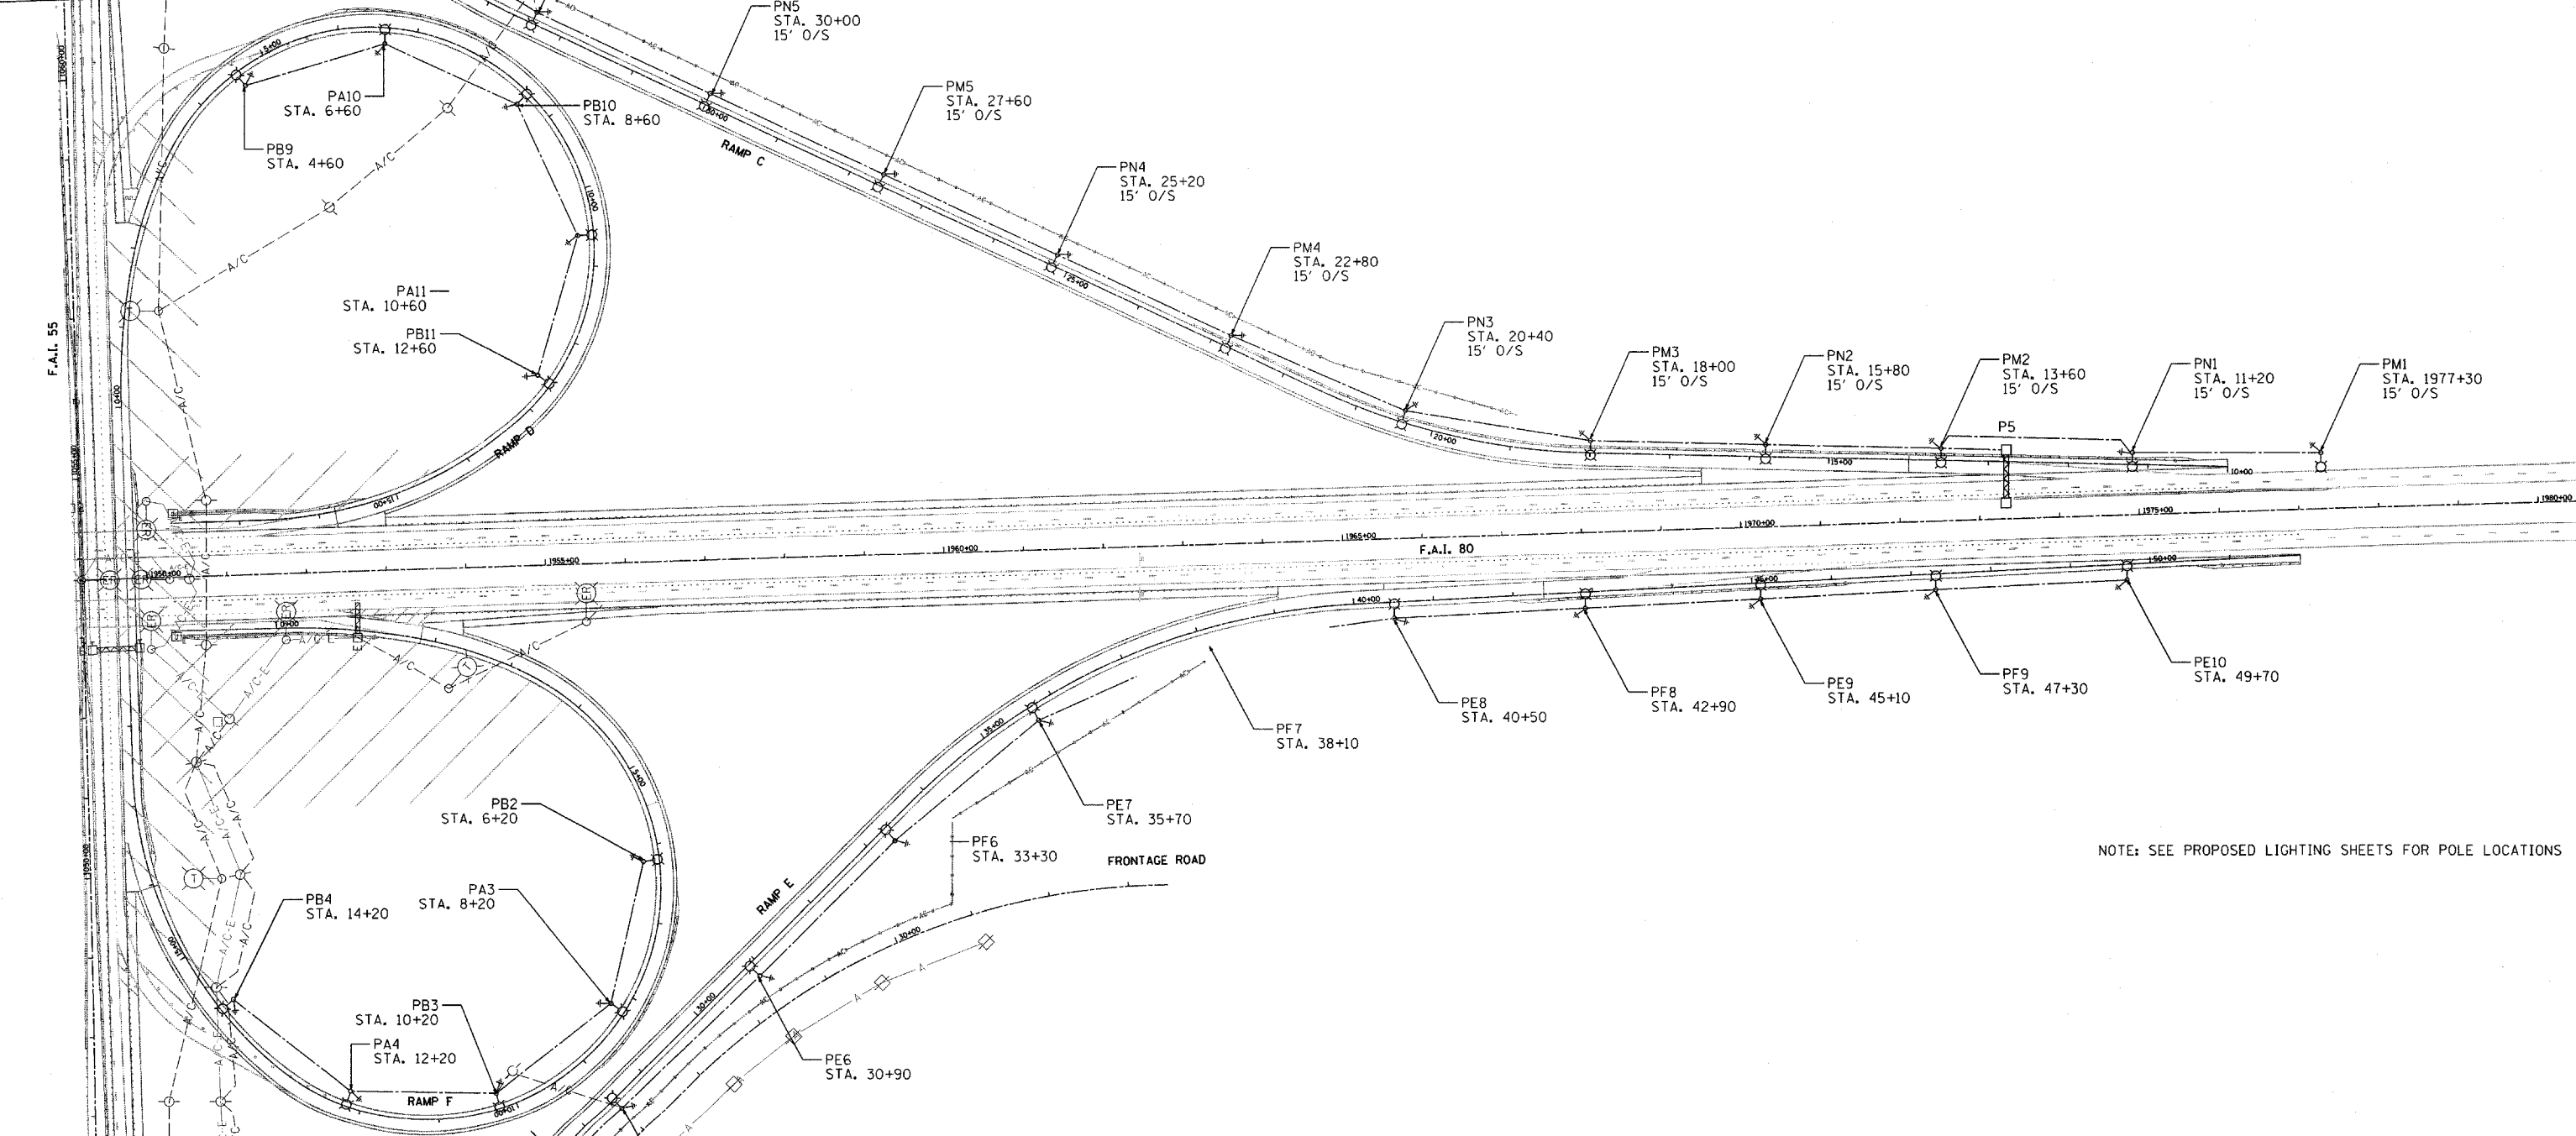

MATCH LINE
STA. 1046+50 F.A.I. 55
SEE SHEET NO. 213

MATCH LINE
STA. 27+50 RAMP E
SEE SHEET NO. 213

NOTE: SEE PROPOSED LIGHTING SHEETS FOR POLE LOCATIONS

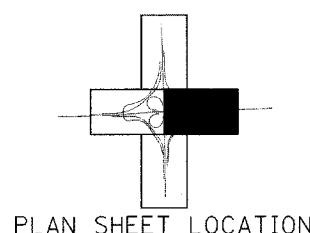

PLAN SHEET LOCATION

REVISIONS	
NAME	DATE

STATE OF ILLINOIS
DEPARTMENT OF TRANSPORTATION
F.A.I. 80 & F.A.I. 55 INTERCHANGE
**TEMPORARY LIGHTING PLAN
STAGE 3**

SCALE: 1" = 100'
DATE: JANUARY, 2005

DRAWN BY: JMV
CHECKED BY: AC