


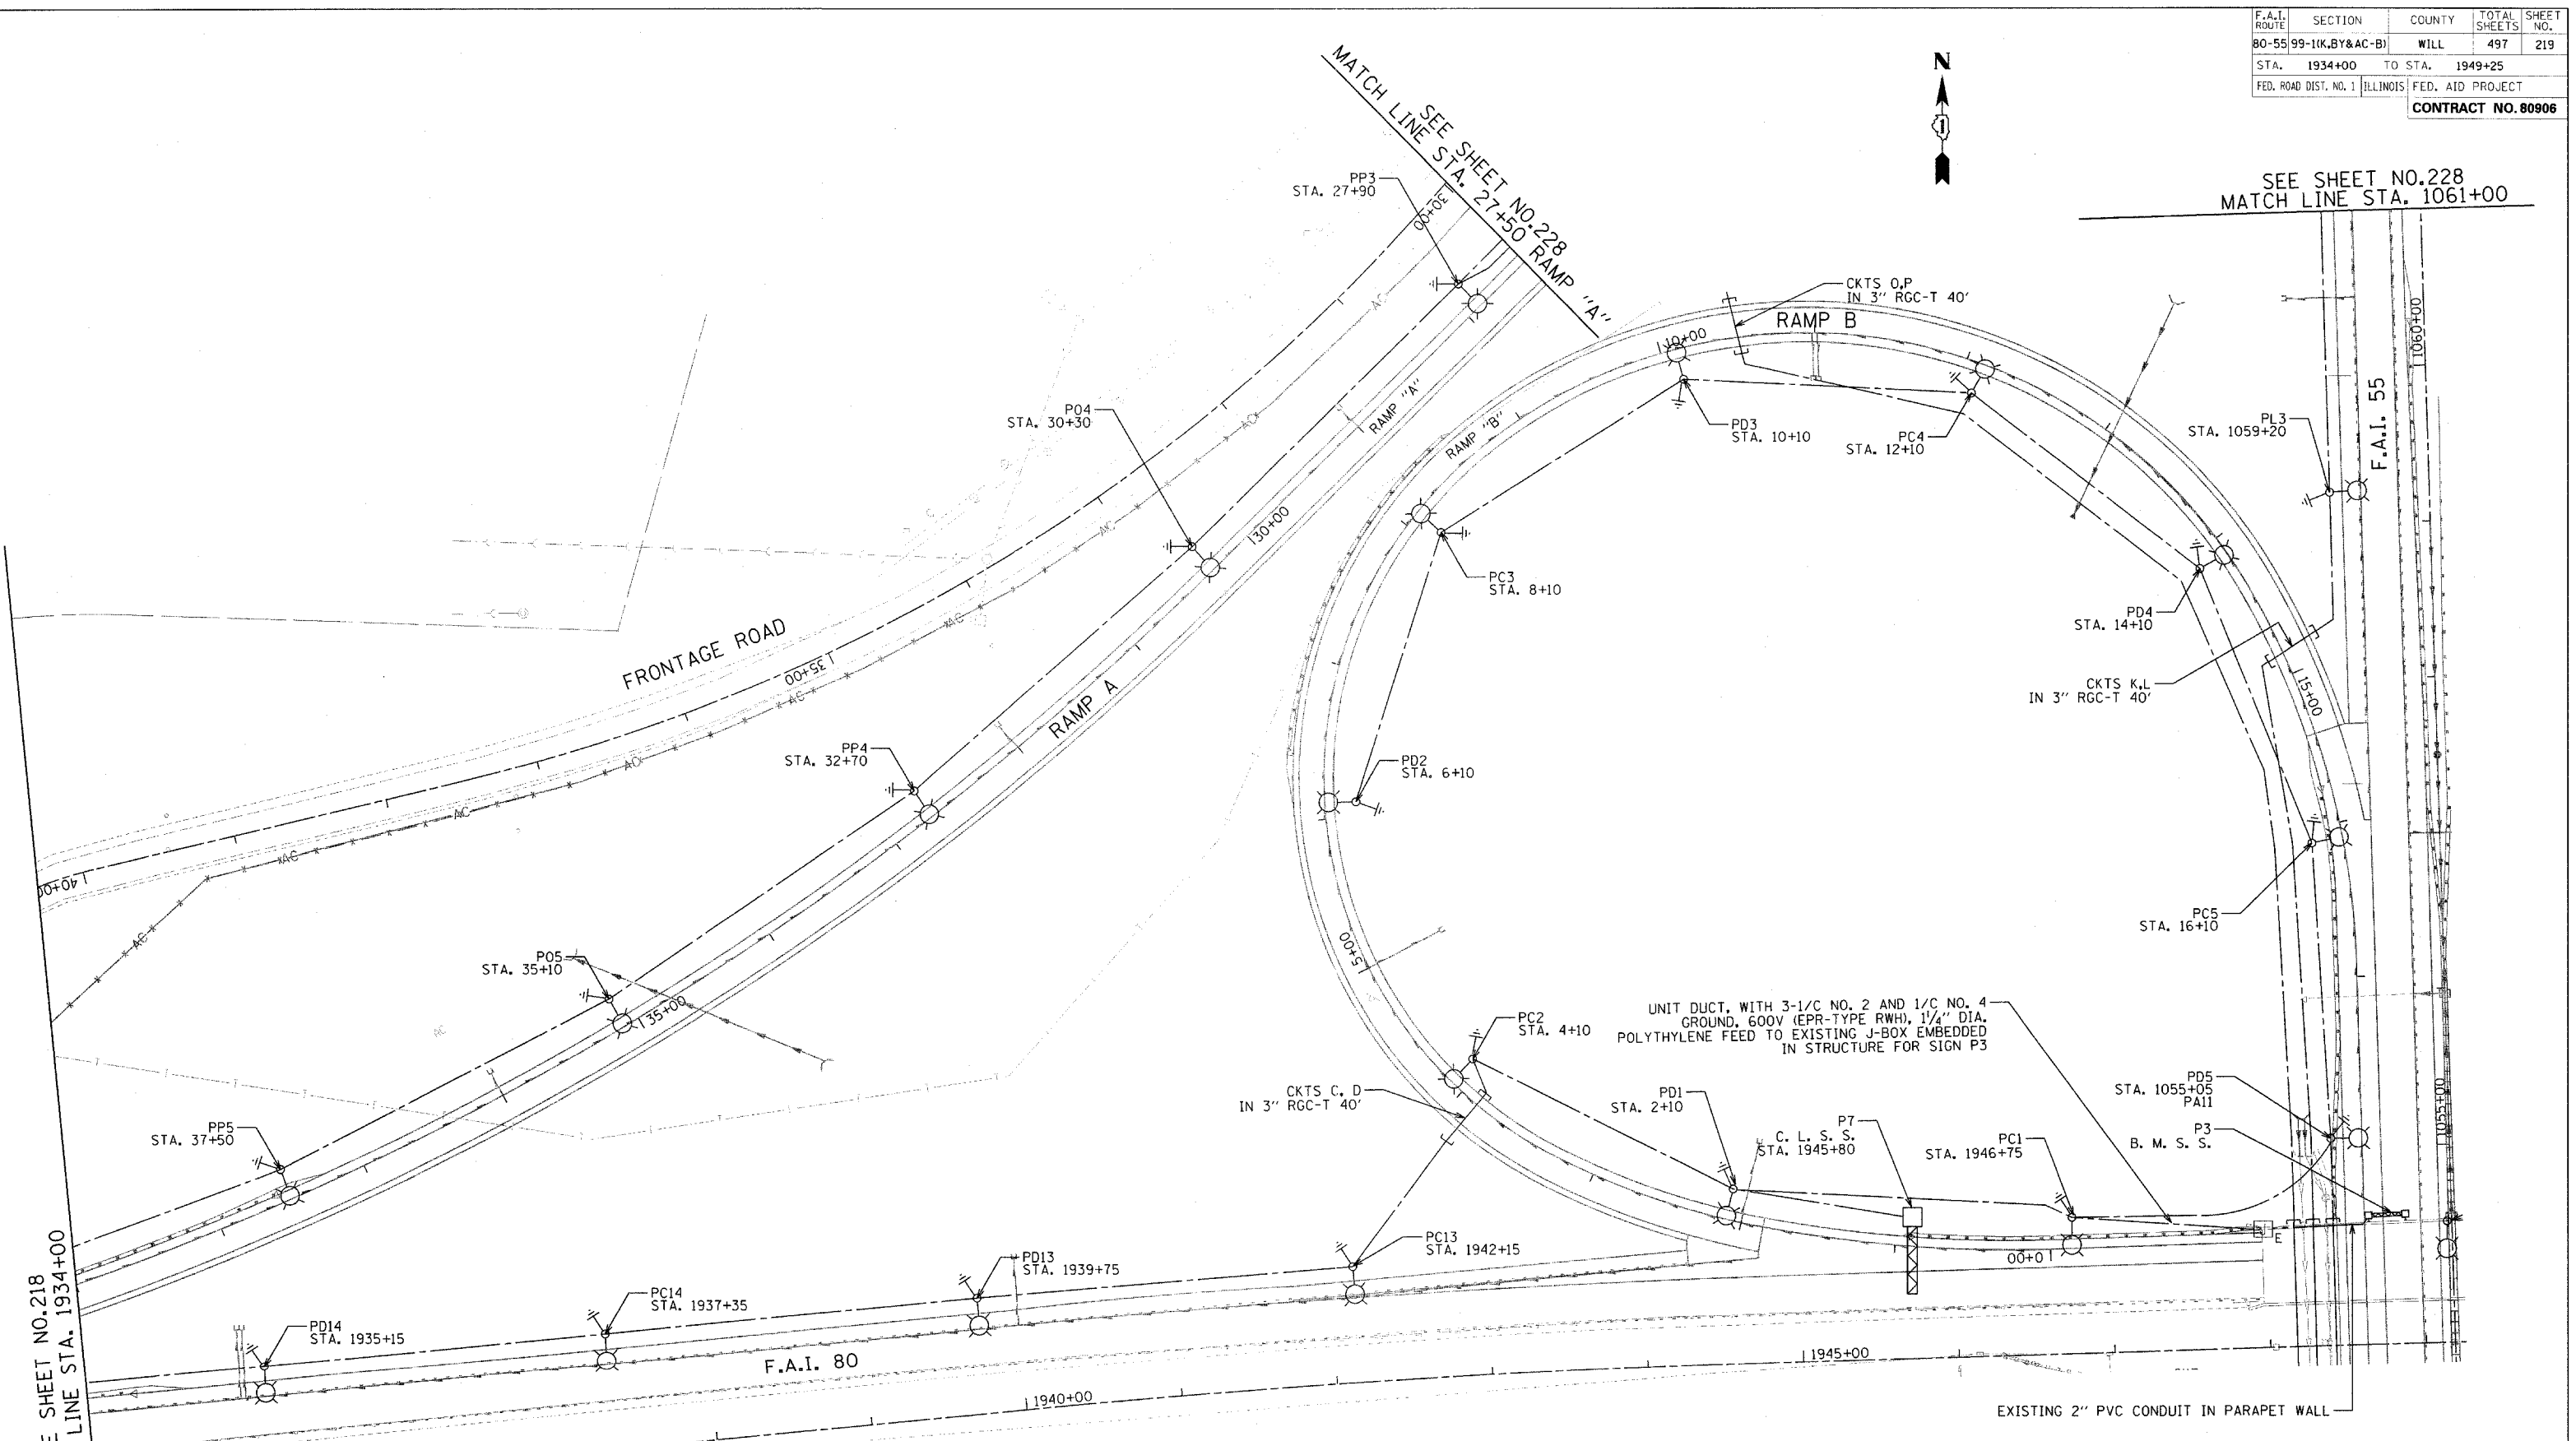


MATCH LINE SEE SHEET NO. 228  
STA. 27+50 RAMP "A"

SEE SHEET NO. 228  
MATCH LINE STA. 1061+00



SEE SHEET NO. 218  
MATCH LINE STA. 1934+00

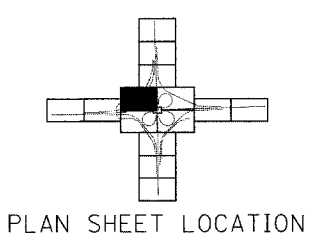

PLAN SHEET LOCATION

REVISIONS	
NAME	DATE

STATE OF ILLINOIS  
DEPARTMENT OF TRANSPORTATION  
F.A.I. 80 & F.A.I. 55 INTERCHANGE  
**LIGHTING PLAN**  
F.A.I. 80, F.A.I. 55,  
RAMPS "A" & "B"

SCALE: 1" = 50'  
DATE: JANUARY, 2005

DRAWN BY: JMV  
CHECKED BY: AC

FILENAME: c:\proj\28802980-02\design\lighting\2880-lighting-03.dgn