





EXISTING 2" PVC CONDUIT IN PARAPET WALL

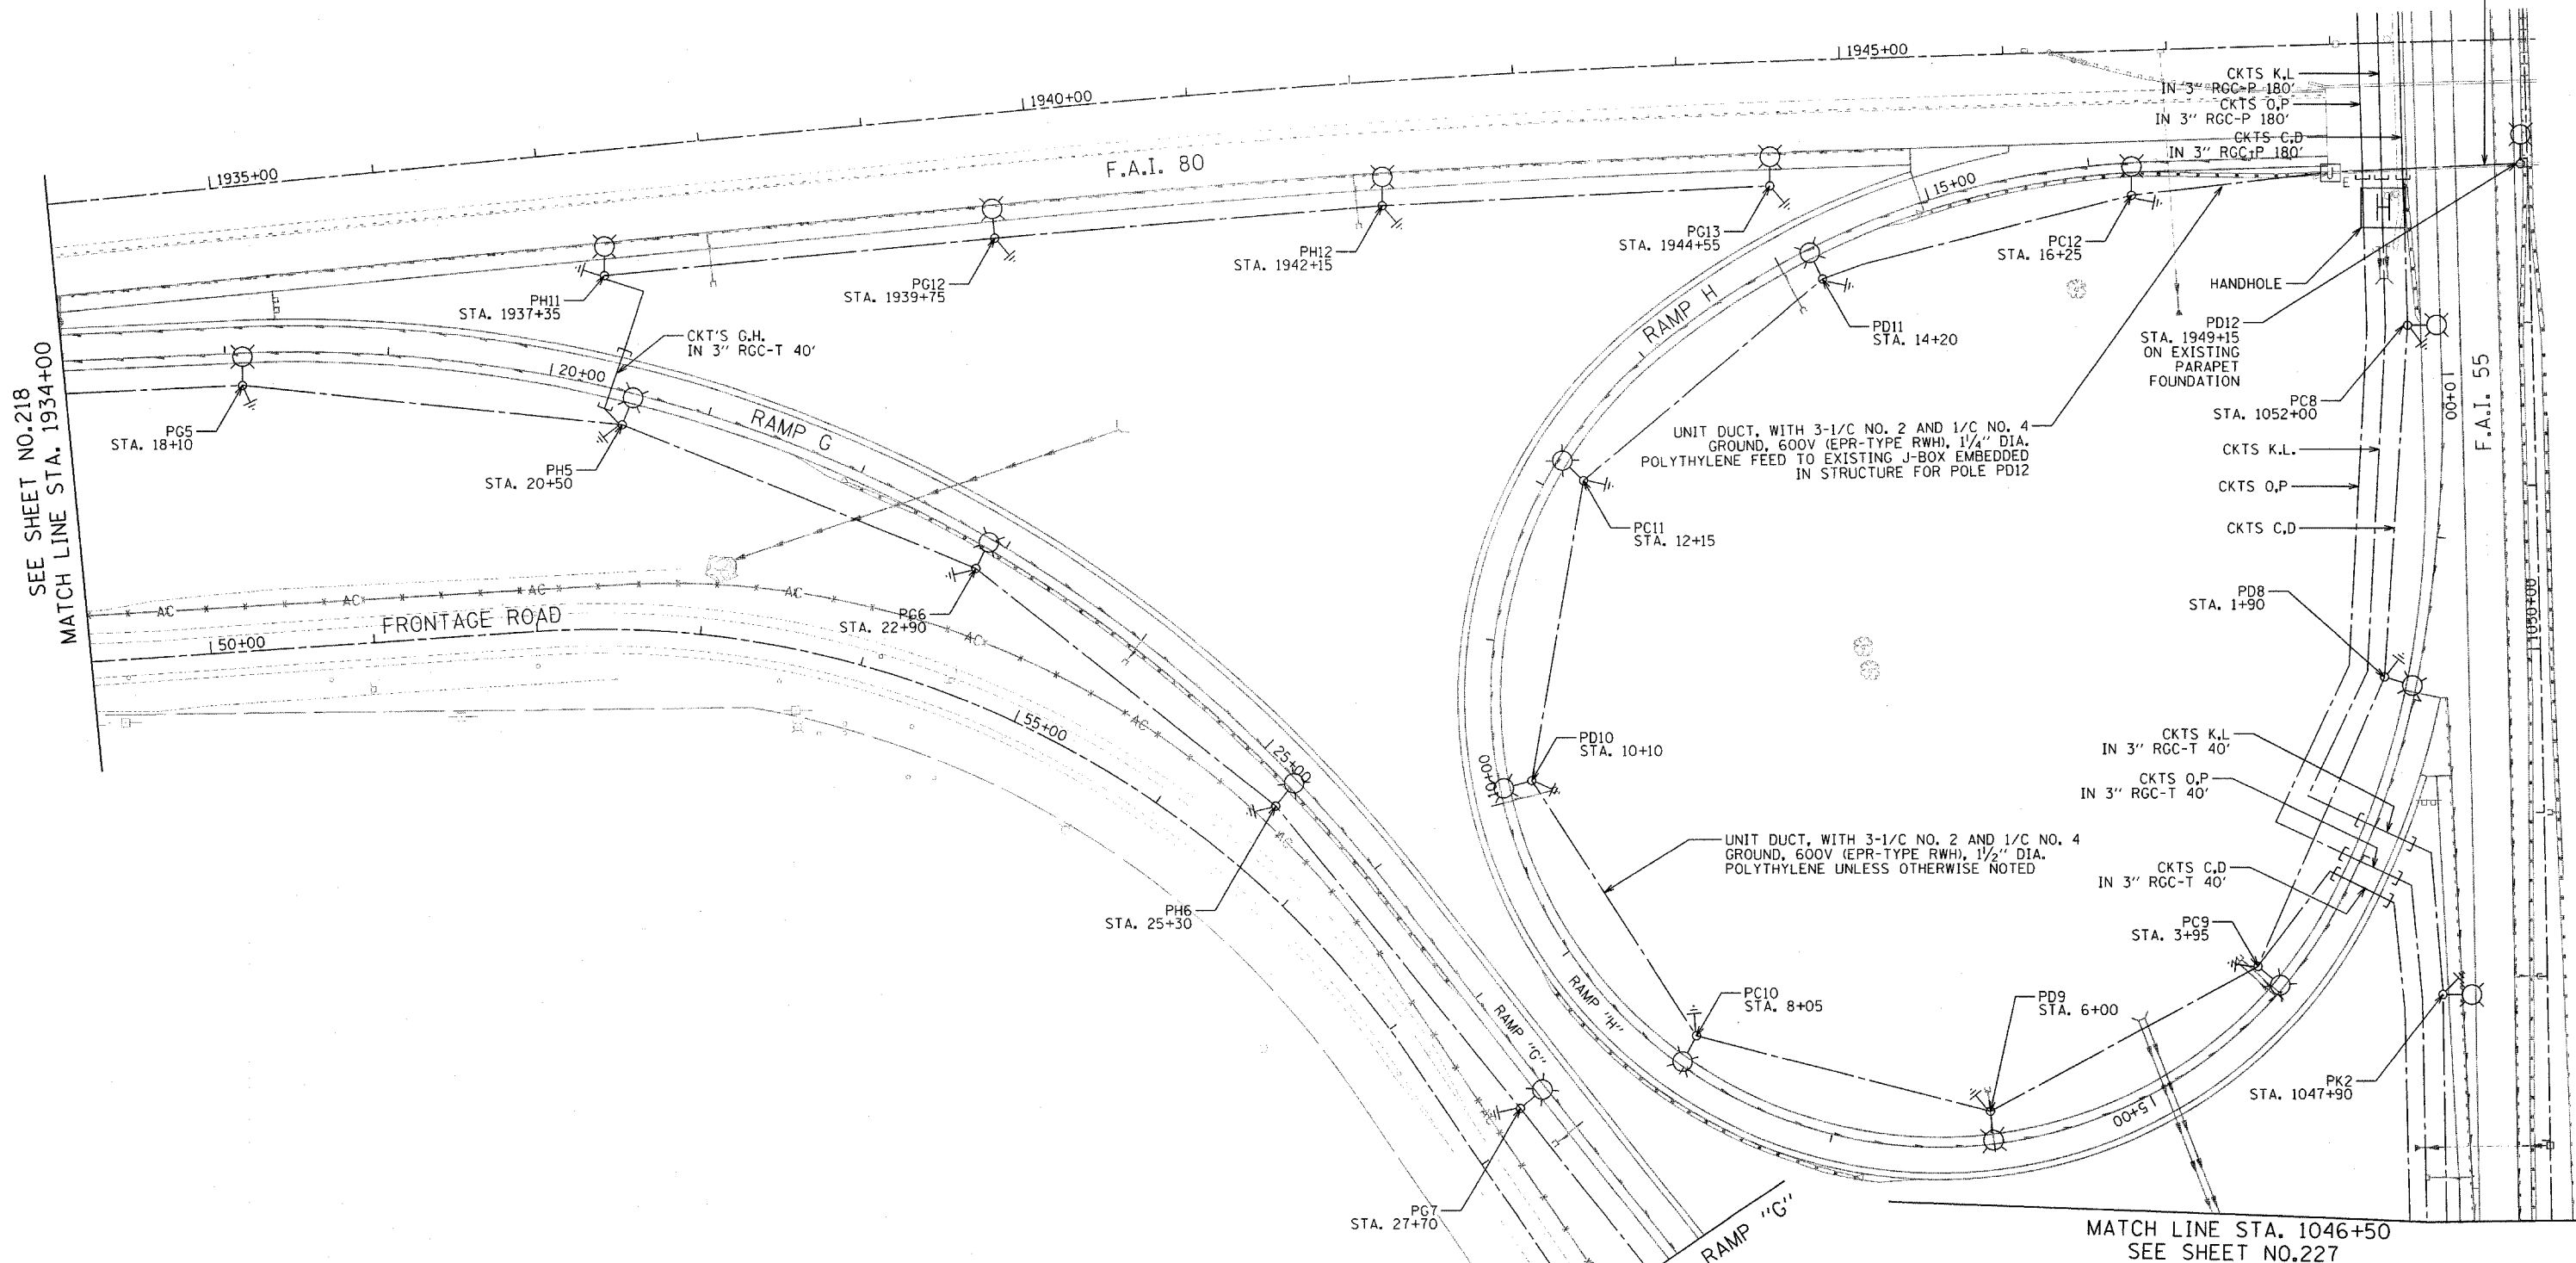

SEE SHEET NO. 218
MATCH LINE STA. 1934+00

MATCH LINE STA. 29+00 RAMP "G"
SEE SHEET NO. 227

MATCH LINE STA. 1046+50
SEE SHEET NO. 227

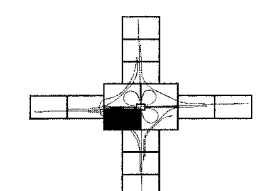

PLAN SHEET LOCATION

REVISIONS	
NAME	DATE

STATE OF ILLINOIS
DEPARTMENT OF TRANSPORTATION
F.A.I. 80 & F.A.I. 55 INTERCHANGE

LIGHTING PLAN
F.A.I. 80, F.A.I. 55,
RAMPS "G" & "H"

SCALE: 1" = 50'
DATE: JANUARY, 2005

DRAWN BY: JMV
CHECKED BY: AC