 


F.A.I. ROUTE	SECTION	COUNTY	TOTAL SHEETS	SHEET NO.
80-55	99-1(K,BY&AC-B)	WILL	497	221
STA. 1949+25	TO STA. 1964+50			
FED. ROAD DIST. NO. 1	ILLINOIS	FED. AID PROJECT		
CONTRACT NO. 80906				





SEE SHEET NO.228
MATCH LINE STA. 1061+00

SEE SHEET NO.228
MATCH LINE STA. 34+00 RAMP "C"

MATCH LINE STA. 22+00 RAMP "C"
SEE SHEET NO.223

MATCH LINE STA. 1964+50
SEE SHEET NO.223

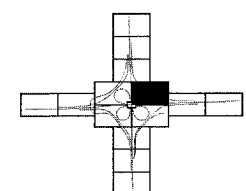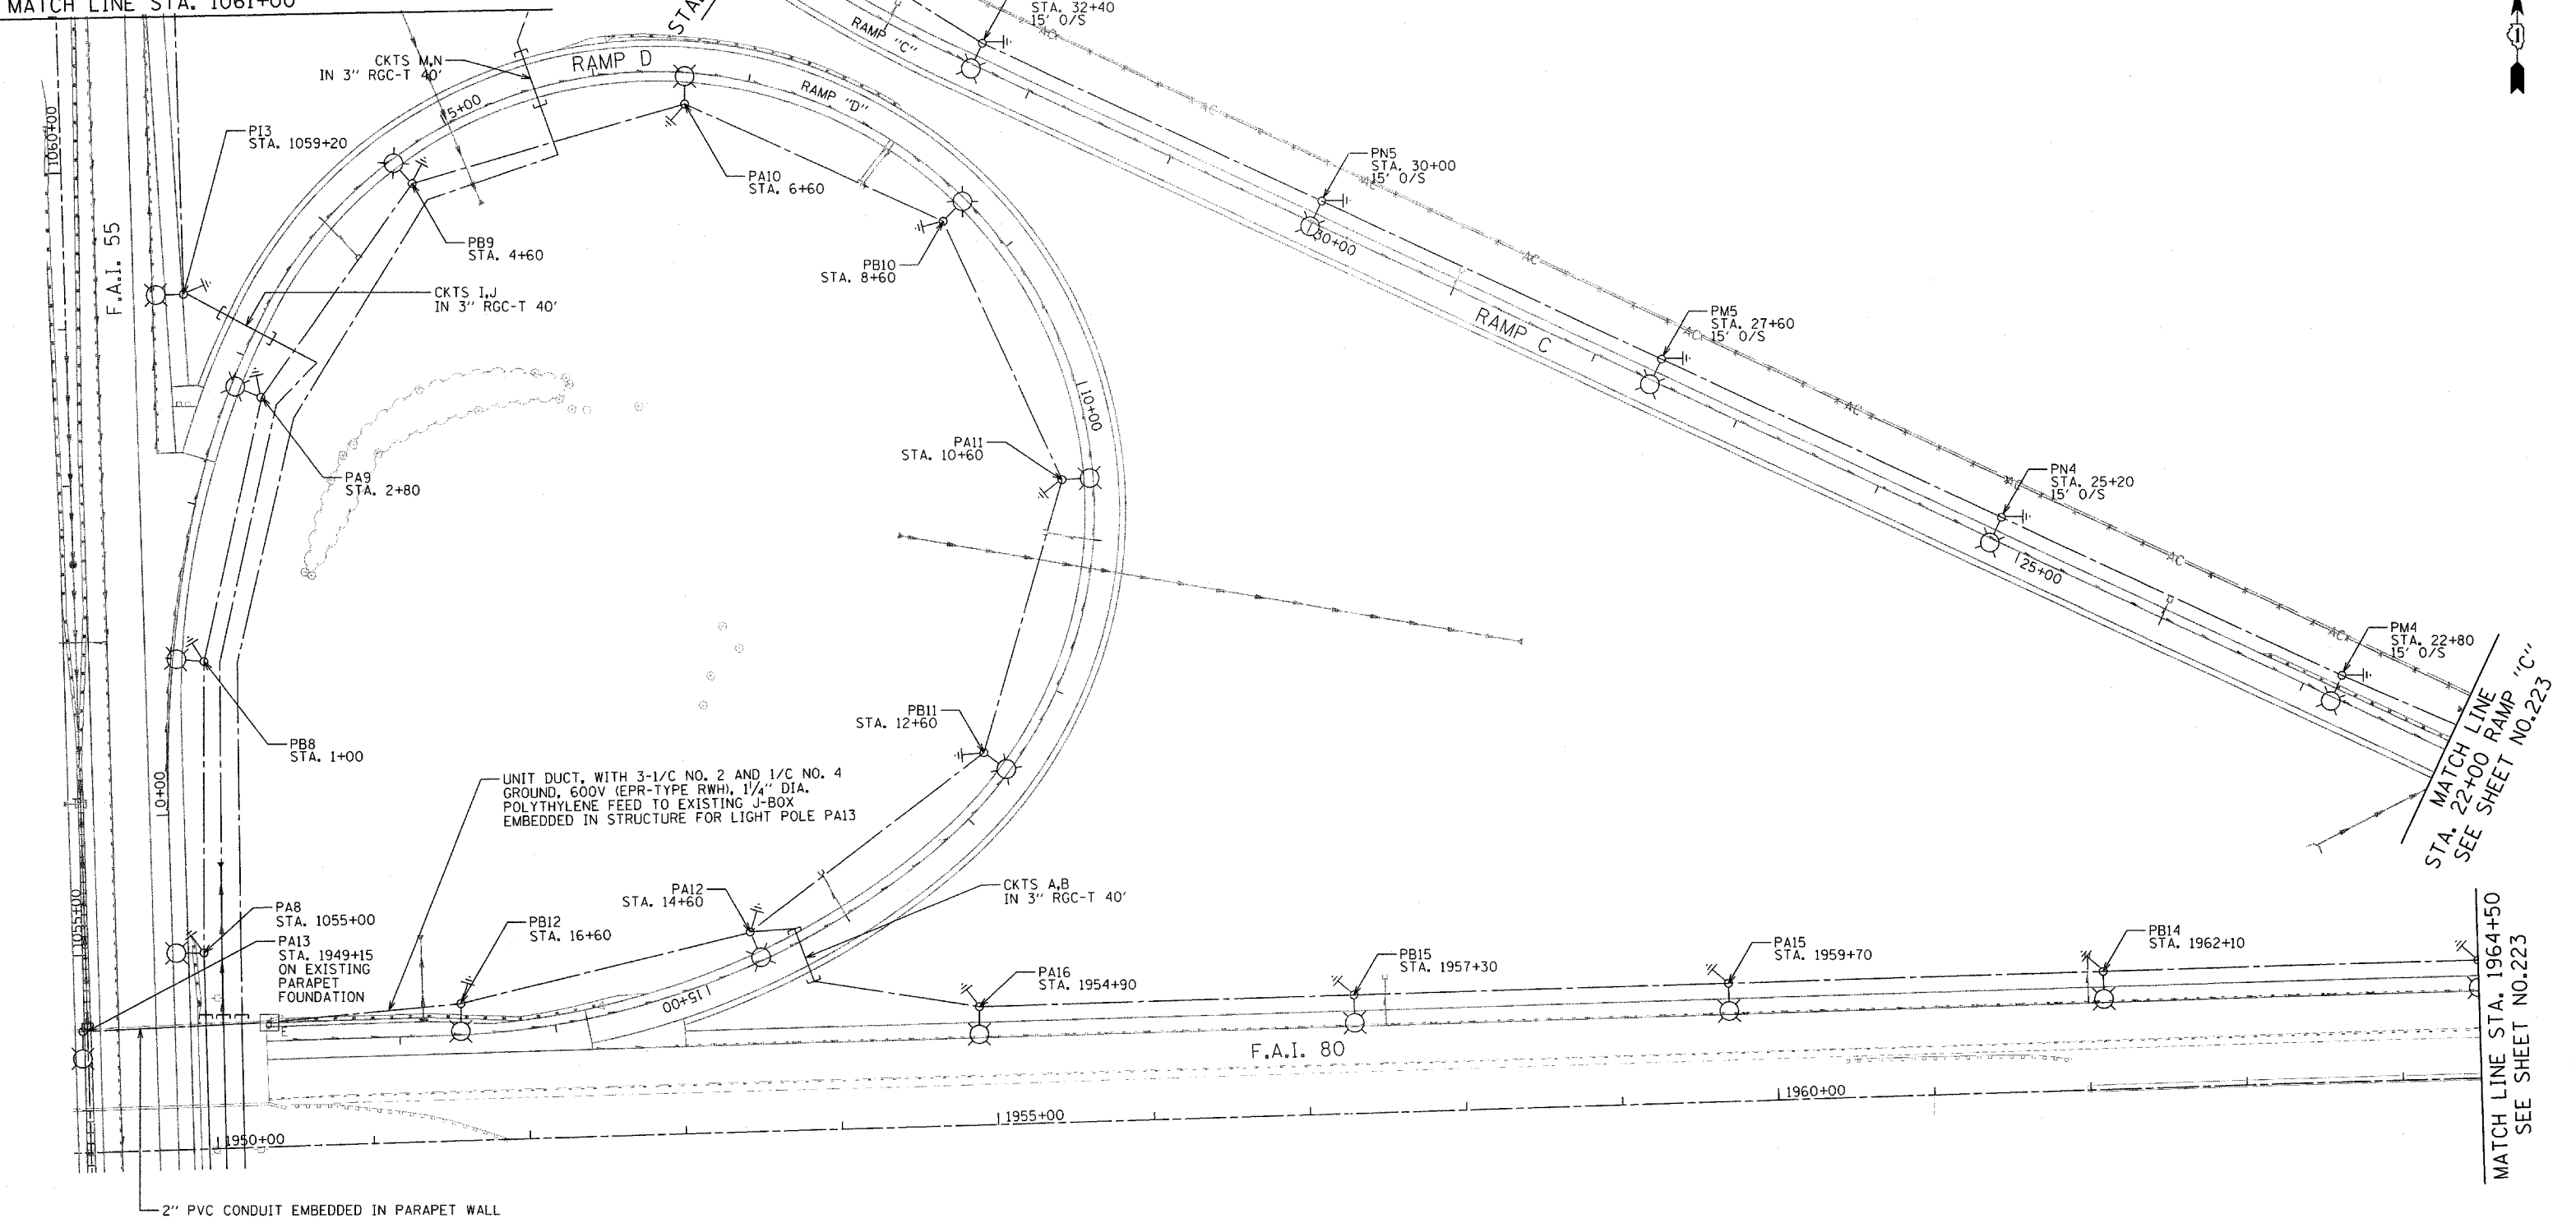

PLAN SHEET LOCATION

REVISIONS	
NAME	DATE

STATE OF ILLINOIS
DEPARTMENT OF TRANSPORTATION
F.A.I. 80 & F.A.I. 55 INTERCHANGE

LIGHTING PLAN
F.A.I. 55, F.A.I. 80,
RAMPS "C" & "D"

SCALE: 1" = 50'
DATE: JANUARY, 2005

DRAWN BY: JMV
CHECKED BY: AC