
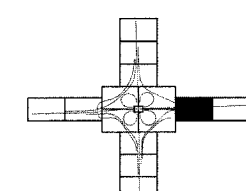


F.A.I. ROUTE	SECTION	COUNTY	TOTAL SHEETS	SHEET NO.
80-55	99-1(K,BY&AC-B)	WILL	497	223
STA. 1964+50		TO STA. 1980+00		
FED. ROAD DIST. NO. 1		ILLINOIS		FED. AID PROJECT
CONTRACT NO. 80906				

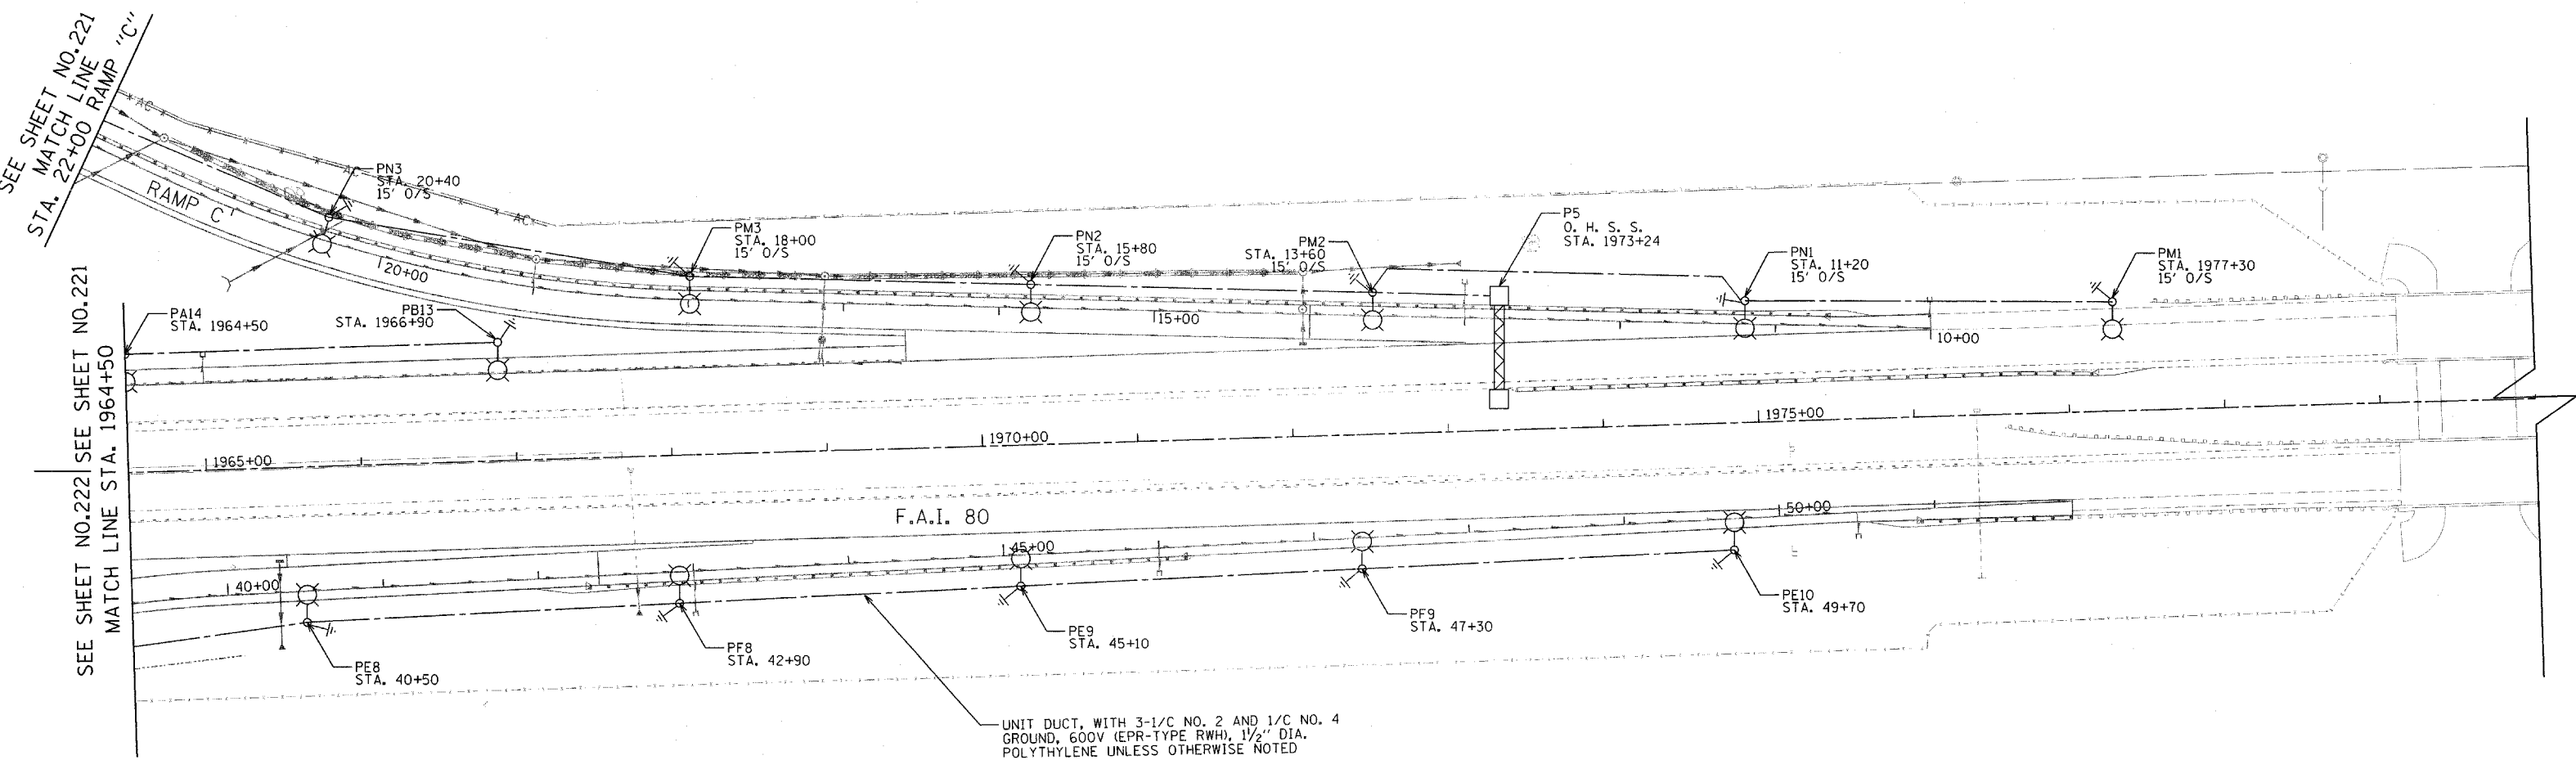

PLAN SHEET LOCATION

REVISIONS	
NAME	DATE

STATE OF ILLINOIS
DEPARTMENT OF TRANSPORTATION
F.A.I. 80 & F.A.I. 55 INTERCHANGE

LIGHTING PLAN
F.A.I. 80, RAMPS "C" & "E"

SCALE: 1" = 50'
DATE: JANUARY, 2005

DRAWN BY: JMV
CHECKED BY: AC