
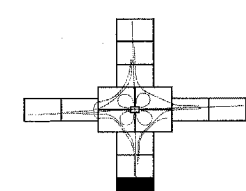
 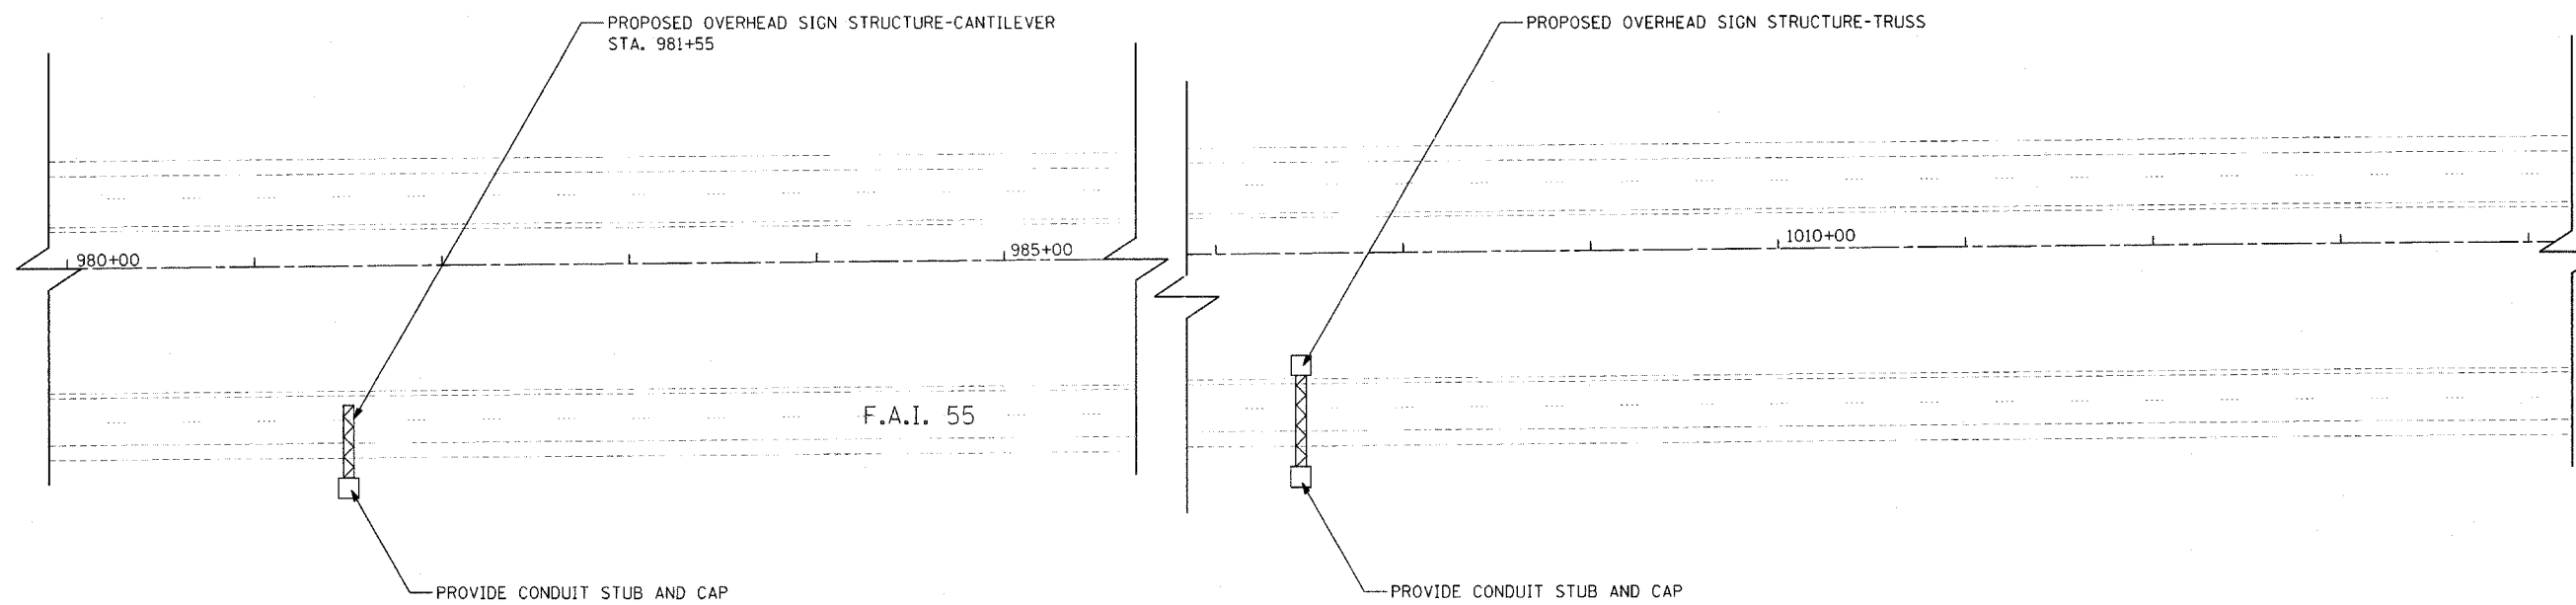


F.A.I. ROUTE	SECTION	COUNTY	TOTAL SHEETS	SHEET NO.
80-55/99-1(K,BY&AC-B)	WILL		497	225
STA. 955+00		TO STA. 1008+00		
FED. ROAD DIST. NO. 1		ILLINOIS FED. AID PROJECT		
<b>CONTRACT NO. 80906</b>				



PLAN SHEET LOCATION

REVISIONS	
NAME	DATE

STATE OF ILLINOIS  
DEPARTMENT OF TRANSPORTATION  
F.A.I. 80 & F.A.I. 55 INTERCHANGE  
**LIGHTING PLAN**  
**F.A.I. 55**

SCALE: 1" = 50'  
DATE: JANUARY, 2005

DRAWN BY: JMV  
CHECKED BY: AC