


F.A.I. ROUTE	SECTION	COUNTY	TOTAL SHEETS	SHEET NO.
80-55-99-1(K,BY&AC-B)		WILL	497	228
STA. 1061+00 TO STA. 1069+00		FED. AID PROJECT		

CONTRACT NO. 80906


SEE SHEET NO.229
MATCH LINE STA. 1069+00

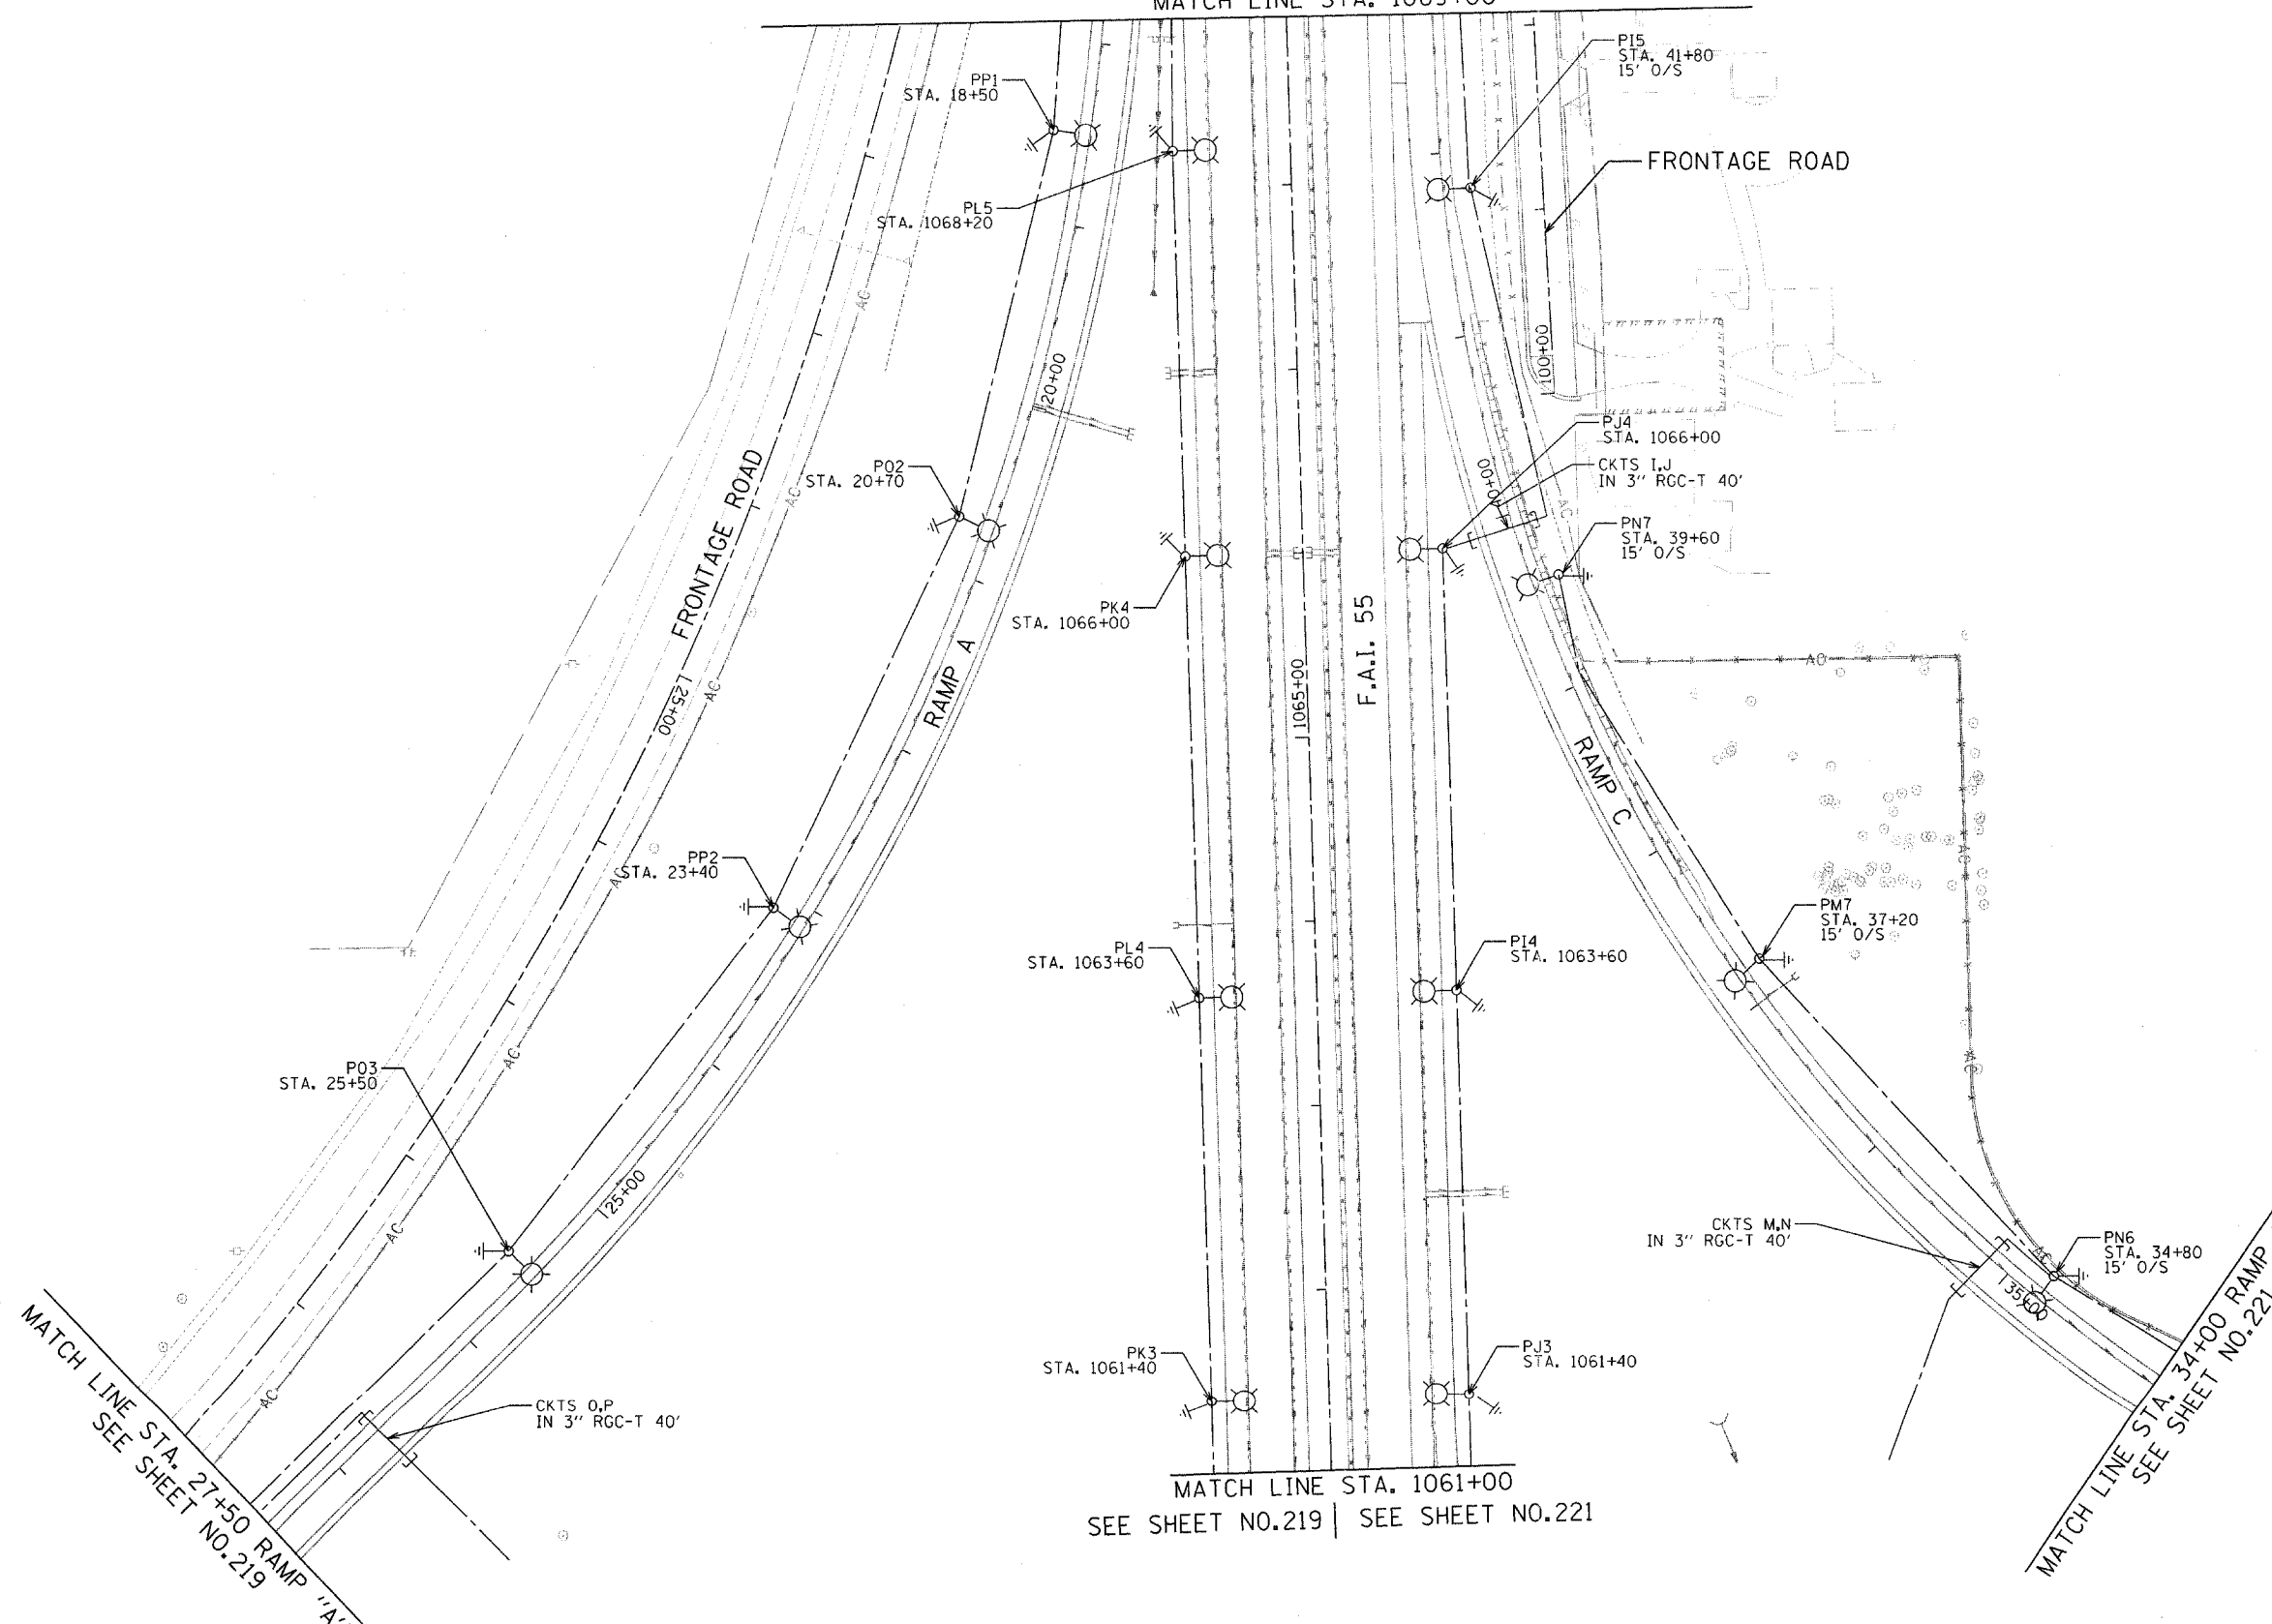

MATCH LINE STA. 27+50 RAMP "A"
SEE SHEET NO.219

MATCH LINE STA. 1061+00
SEE SHEET NO.219 | SEE SHEET NO.221

MATCH LINE STA. 34+00 RAMP "C"
SEE SHEET NO.221

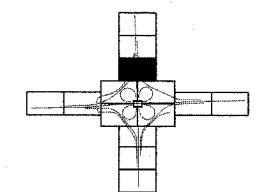

PLAN SHEET LOCATION

REVISIONS	
NAME	DATE

STATE OF ILLINOIS
DEPARTMENT OF TRANSPORTATION
F.A.I. 80 & F.A.I. 55 INTERCHANGE

LIGHTING PLAN
F.A.I. 55, RAMPS "A" & "C"

SCALE: 1" = 50'
DATE: JANUARY, 2005
DRAWN BY: JMV
CHECKED BY: AC