
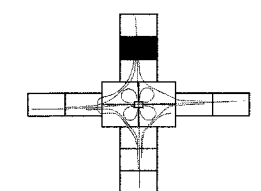
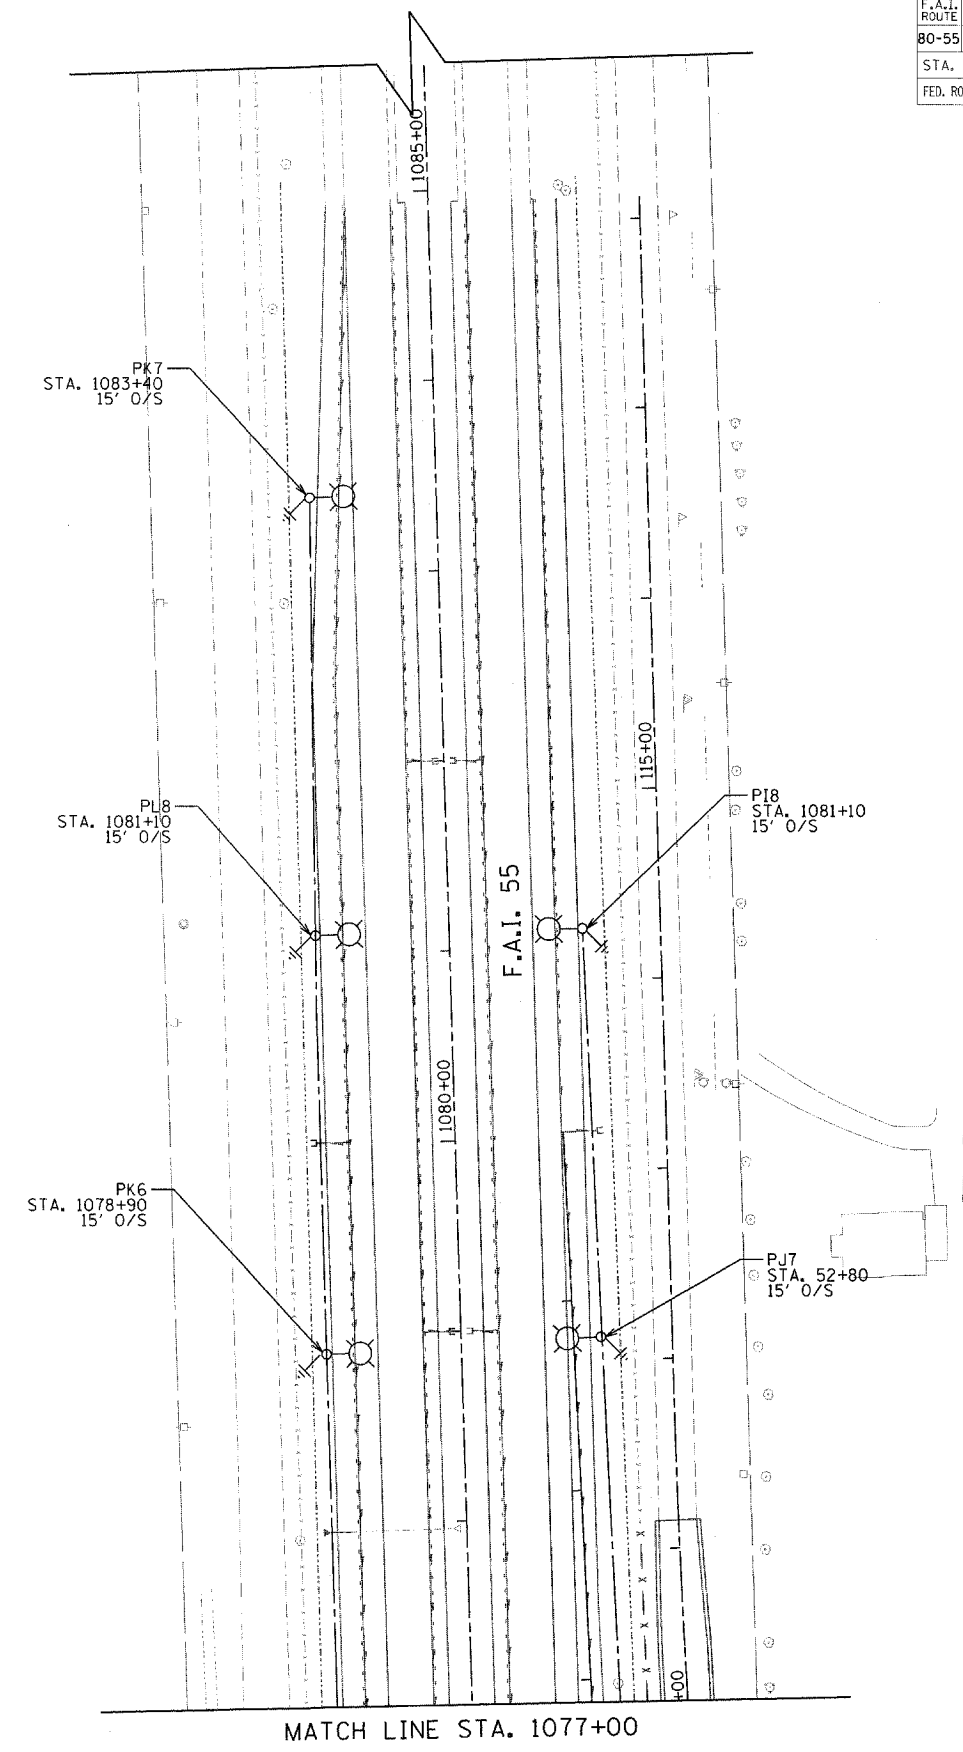


F.A.I. ROUTE	SECTION	COUNTY	TOTAL SHEETS	SHEET NO.
80-55	99-1(K,BY&AC-B)	WILL	497	229
STA. 1069+00		TO STA. 1081+00		
FED. ROAD DIST. NO. 1		ILLINOIS		FED. AID PROJECT
CONTRACT NO. 80906				

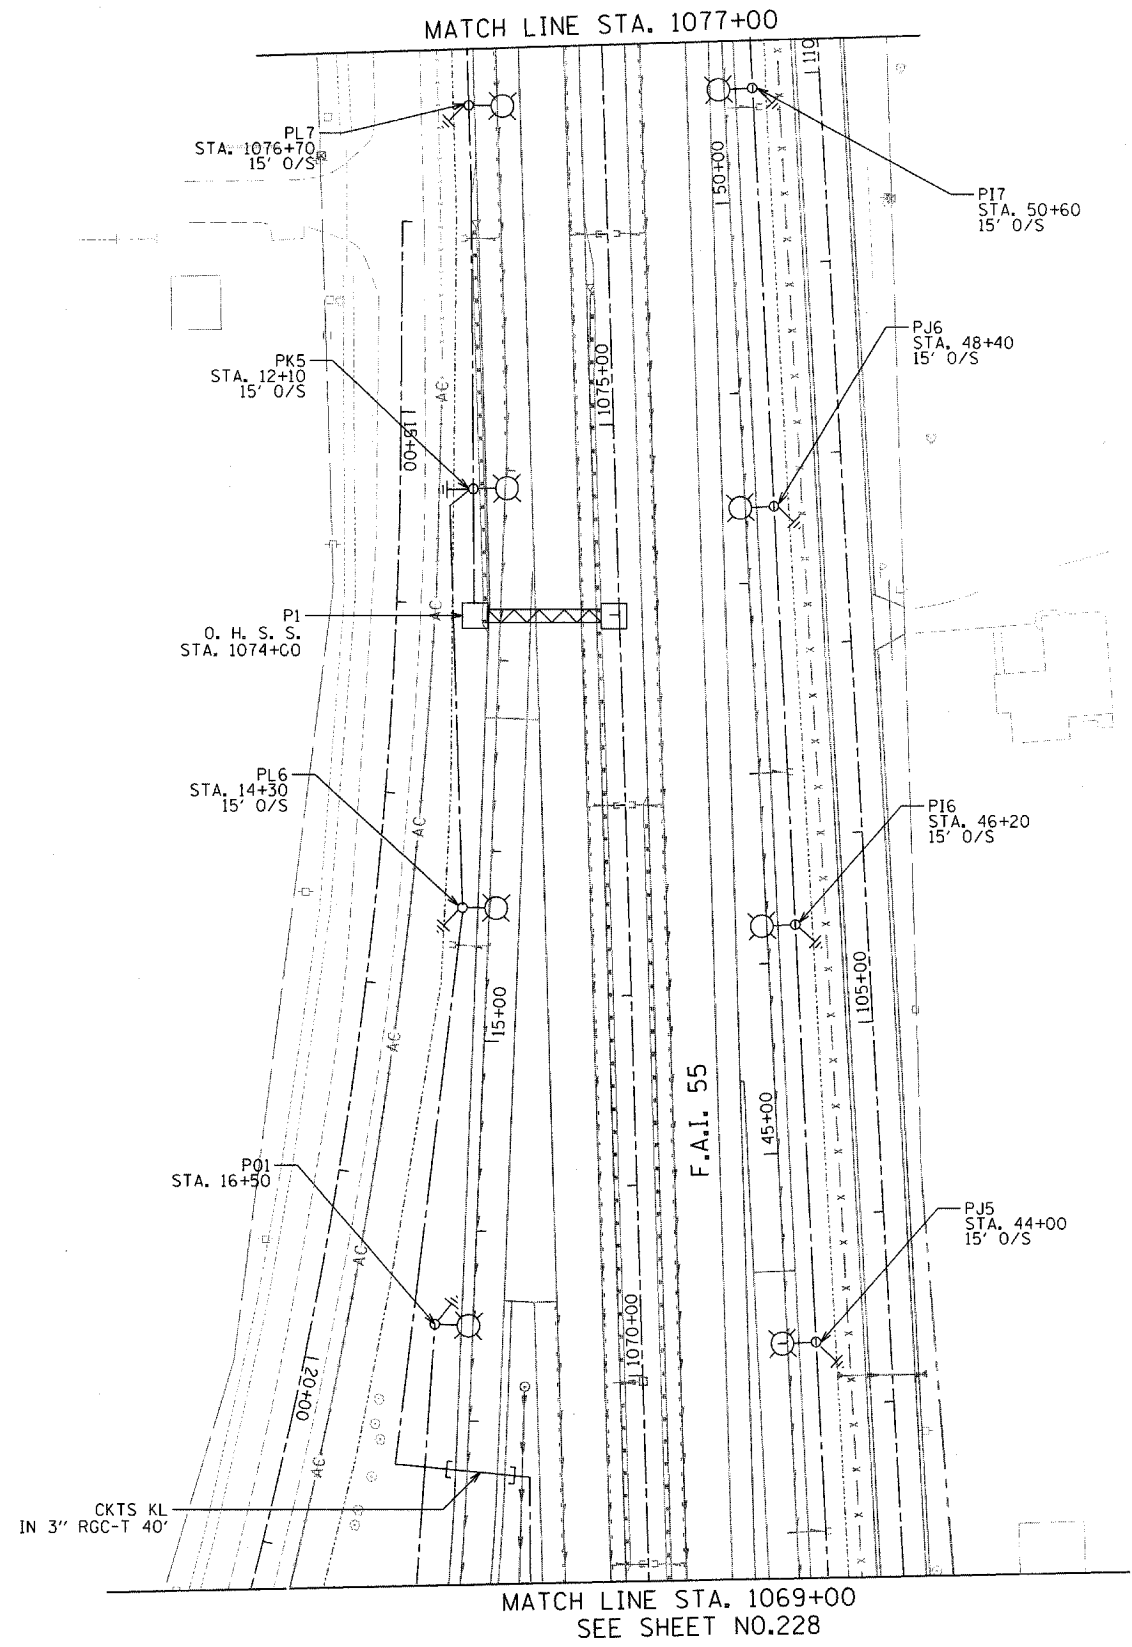

PLAN SHEET LOCATION

REVISIONS	
NAME	DATE

STATE OF ILLINOIS
DEPARTMENT OF TRANSPORTATION
F.A.I. 80 & F.A.I. 55 INTERCHANGE

LIGHTING PLAN
F.A.I. 55, RAMPS "A" & "C"

SCALE: 1" = 50'
DATE: JANUARY, 2005

DRAWN BY: JMV
CHECKED BY: AC