
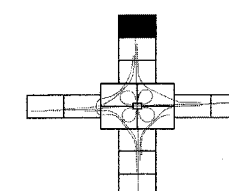


F.A.I. ROUTE	SECTION	COUNTY	TOTAL SHEETS	SHEET NO.
80-55 99-1(K, BY&AC-B)	WILL		497	230
STA. 1085+50		TO STA. 1126+00		
FED. ROAD DIST. NO. 1 ILLINOIS FED. AID PROJECT				
CONTRACT NO. 80906				

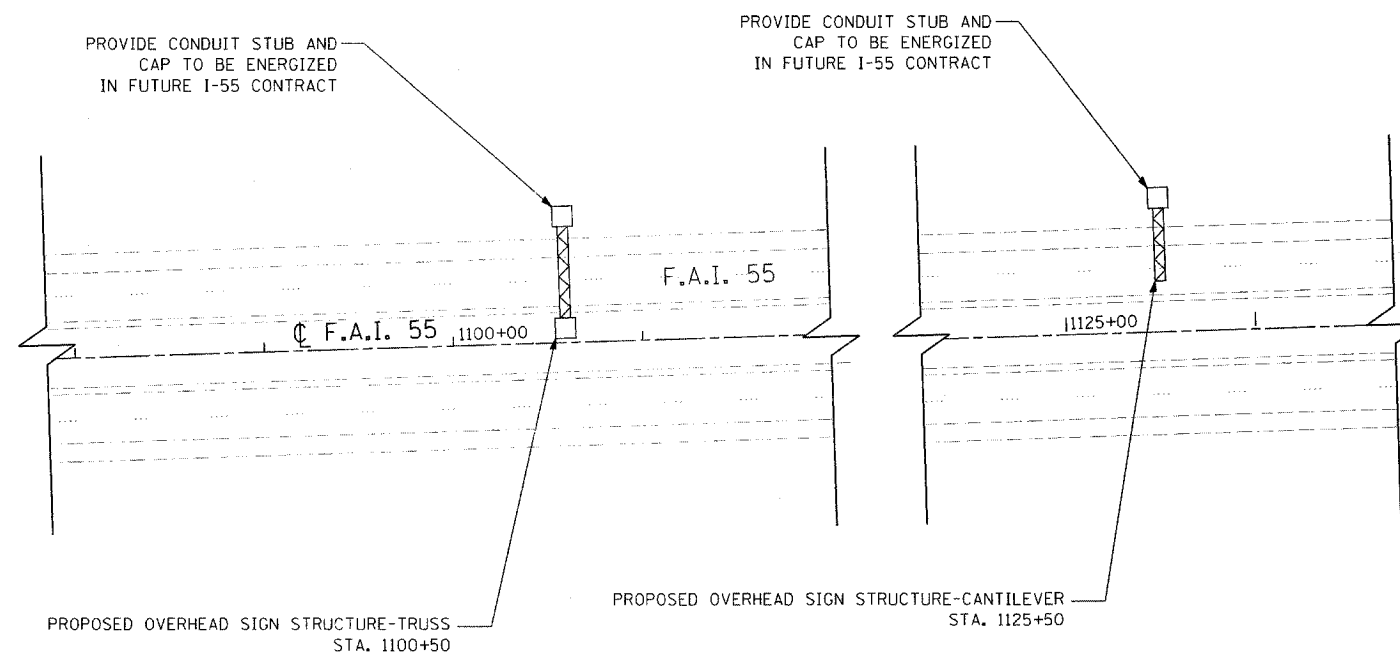

PLAN SHEET LOCATION

REVISIONS	
NAME	DATE

STATE OF ILLINOIS
DEPARTMENT OF TRANSPORTATION
F.A.I. 80 & F.A.I. 55 INTERCHANGE
LIGHTING PLAN
F.A.I. 55

SCALE: 1" = 50'
DATE: JANUARY, 2005

DRAWN BY: JMV
CHECKED BY: AC

FILENAME: n:\proj\28802890-02\esign\lighting\2880-lighting-14.dgn